

Attachment 1


DRAWING ABBREVIATIONS

AAV	AUTOMATIC AIR VENT
ABV	ABOVE
AC	AIR CONDITIONING UNIT
AD	ACCESS DOOR
ADR	AREA DRAIN (SEE SYMBOLS)
AFF	ABOVE FINISHED FLOOR
AH	AIR HANDLER (SPLIT REFRIG)
AHU	AIR HANDLING UNIT
AL	ACOUSTICAL LINING
ALUM	ALUMINUM
AP	ACCESS PANEL
ATC	AUTOMATIC TEMP. CONTROL
AVER	AVERAGE
AWT	AVERAGE WATER TEMP.
B	BOILER
BB	ELECTRIC BASEBOARD RADIATION
BDO	BACK DRAFT DAMPER
BFC	BELOW FINISHED CEILING
BFP	BACK FLOW PREVENTOR
BLDG	BUILDING
BLW	BELOW
BOB	BOTTOM OF BEAM
BOD	BOTTOM OF DUCT
BOP	BOTTOM OF PIPE
BSMT	BASMENT
BTU	BRITISH THERMAL UNIT
C	CHILLER
CAP	CAPACITY
CBV	CIRCUIT BALANCING VALVE
CD	CEILING DIFFUSER
CFH	CUBIC FEET PER HOUR
CFM	CUBIC FEET PER MINUTE
CFM	CUBIC FEET PER MINUTE
CHP	CONCRETE HOUSEKEEPING PAD
CHWP	CHILLED WATER PUMP
CHWR	CHILLED WATER RETURN
CHWS	CHILLED WATER SUPPLY
CI	CAST IRON
CL	CENTER LINE
CLG	CEILING
CMU	CONCRETE MASONRY UNIT
CO	CLEAN OUT
COL	COLUMN
COMP	COMPRESSOR
CON	CONCENTRIC
CONC	CONCRETE
COND	CONDENSATE
CONN	CONNECTION
CONT'N	CONTINUATION
CONTR	CONTRACTOR
CP	CONDENSATE PUMP
CT	COOLING TOWER
CU	CONDENSING UNIT
CUH	CABINET UNIT HEATER
CVB	CONSTANT VOLUME BOX
CWP	CONDENSER WATER PUMP
CWR	CONDENSER WATER RETURN
CWS	CONDENSER WATER SUPPLY
DA	DIRECT ACTING
DAMP	DAMP DAMPER
DB	DRY BULB
DEPT	DEPARTMENT
DIA	DIAMETER
DIAG	DIAGRAM
DIFF	DIFFERENTIAL
DISCH	DISCHARGE
DIV	DIVISION
DIW	DOWN IN WALL
DL	DOOR LOUVER
DN	DOWN
DS	DUCT SILENCER
DWG	DRAWING
DWP	DOMESTIC WATER PUMP
DX	DIRECT EXPANSION
EA	EACH
EAT	ENTERING AIR TEMPERATURE
EC	ELECTRICAL CONTRACTOR
ECC	ECCENTRIC
EF	EXHAUST FAN
EFF	EFFICIENCY
EJ	EXPANSION JOINT
EL	ELEVATION
ELEC	ELECTRIC
ELEV	ELEVATOR
ENT	ENTERING
EQ	EQUAL
EQUIP	EQUIPMENT
EQUIV	EQUIVALENT
ER	EXHAUST REGISTER
ES	END SWITCH
ESP	EXTERNAL STATIC PRESSURE
ET	EXPANSION TANK
EWC	ELECTRIC WATER COOLER
EWT	ENTERING WATER TEMPERATURE
EX	EXHAUST
EXPAN	EXPANSION
EXT	EXTERNAL
F	DEGREES FAHRENHEIT
F/D	FIRE DAMPER
F/S/D	WITH FIRE/SMOKE DAMPER ACCESS DOOR
FA	FROM ABOVE
FB	FREE AREA
FC	FROM BELOW
FD	FROM BELOW
FE	FEEL
FCU	FAN COIL UNIT
FCV	FLOW CONTROL VALVE
FD	FLOOR DRAIN
FD	FIRE DAMPER
FIN	FINISHED
FL	FLANGE
FLA	FULL LOAD AMPS
FLEX	FLEXIBLE
FLR	FLOOR
FO	FAIL OPEN
FOP	FLAT ON BOTTOM
FOP	FUEL OIL PUMP
FOT	FLAT ON TOP
LIQ	LIQUID
LRA	LOCK ROTOR AMPS
LVG	LEAVING
LVR	LOUVER
LWT	LEAVING WATER TEMPERATURE
LWT	LEAVING WATER TEMPERATURE
MBH	THOUSANDS OF BTU PER HOUR
MC	MECHANICAL CONTRACTOR
MED	MEDIUM
MFR	MANUFACTURER
MH	MANHOLE
MIN	MINIMUM
MISC	MISCELLANEOUS
MOD	MOTOR OPERATED DAMPER
MTD	MOUNTED
MUA	MAKE-UP AIR UNIT
NC	NORMALLY CLOSED
NEG	NEGATIVE
NIC	NOT IN CONTRACT
NK	NECK
NO	NORMALLY OPEN
NO	NUMBER
NO	NORMALLY OPEN
NOM	NOMINAL
NTS	NOT TO SCALE
OA	OUTSIDE AIR
OAI	OUTSIDE AIR INTAKE
OAT	OUTSIDE AIR TEMPERATURE
OB	OFF BOTTOM
OB	OPPOSED BLADE DAMPER
OC	ON CENTER
OCC	OCCUPIED
OD	OUTSIDE DIMENSION
OD	OUTSIDE DIAMETER
OGH	OUTSIDE GROUND HYDRANT
OPG	OPENING
OIL	OFF TOP
OZ	OUNCE
PART	PARTIAL
PBD	PARALLEL BLADE DAMPER
PD	PRESSURE DROP (SEE SCHEDULE)
PDR	PLENUM DRAIN
PERF	PERFORATED
PH	PHASE
PNEU	PNEUMATIC
POS	POSITIVE PRESS
PRESS	PRESSURE
PRV	PRESSURE REDUCING VALVE
PS	PRESSURE SWITCH
PSI	POUNDS PER SQUARE INCH
PT	PRESSURE TRANSMITTER
PTAC	PACKAGED TERMINAL AIR CONDITIONER
PV	PLUG VALVE
PVC	POLYVINYL CHLORIDE
QUAN	QUANTITY
R	REGISTER
RA	RETURN AIR
RAG	RETURN AIR GRILLE
RAR	RETURN AIR REGISTER
RCP	REFLECTED CEILING PLAN
RD	ROOF DRAIN
RE	ROUNDED ENTRANCE/EXIT
REL	RELIEF
REQD	REQUIRED
RET	RETURN
RF	RETURN FAN
RH	RELATIVE HUMIDITY
RHC	REHEAT COIL
RICW	RUN IN CASEWORK
RIE	RUN IN ENCLOSURE
RIW	RISE IN WALL
RLA	RATED LOAD AMPS
RM	ROOM
ROD	ROOF OVERFLOW DRAIN
RPM	REVOLUTIONS PER MINUTE
SA	SUPPLY AIR
SAD	SUPPLY AIR DIFFUSER
SAR	SUPPLY AIR REGISTER
SCG	SMOKE CONTROL GRILLE
SCH	SCHEDULE
SCHEM	SCHEMATIC
SD	SMOKE DAMPER
SEF	SMOKE EXHAUST FAN
SF	SUPPLY FAN
SH	SENSIBLE HEAT
SP	STATIC PRESSURE
SPEC	SPECIFICATION
SQ	SQUARE
SS	STAINLESS STEEL
STD	STANDARD
STL	STEEL
STM	STEAM
STR	STRUCTURAL
SUCT	SUCTION
SYS	SYSTEM
TAD	TRANSFER AIR DUCT
TDM	TOTAL DYNAMIC HEAD
TEMP	TEMPERATURE
TG	TRANSFER GRILLE
TH	TOTAL HEAT
TP	TOTAL PRESSURE
TT	TEMPERATURE TRANSMITTER
TYP	TYPICAL
UC	UNDERCUT
UH	UNIT HEATER
UNOCC	UNOCCUPIED
UNON	UNLESS OTHERWISE NOTED
V	VOLTS
VA	VALVE
VAV	VARIABLE AIR VOLUME UNIT
VB	VACUUM BREAKER
VD	VOLUME DAMPER
VEL	VELOCITY
VI	VIBRATION ISOLATOR
VOLT	VOLTAGE
VTR	VENT THRU ROOF
W	WIDTH
W/	WITH
W/O	WITHOUT
WB	WET BULB
WB	WET BULB
WC	WATER COLUMN
WG	WATER GAUGE
WMS	WIRE MESH SCREEN


LINE DESIGNATION SYMBOLS

CS	CONDENSER WATER SUPPLY
CR	CONDENSER WATER RETURN
RL	REFRIGERANT LIQUID
RS	REFRIGERANT SUCTION
RD	REFRIGERANT DISCHARGE
GS	GLYCOL SUPPLY
GR	GLYCOL RETURN
HWS	HOT WATER SUPPLY
HWR	HOT WATER RETURN
HPS	HEAT PUMP SUPPLY
HPR	HEAT PUMP RETURN
PC	PUMPED CONDENSATE
CF	CHEMICAL FEED
V	VENT PIPING
R	RELIEF PIPING
MU	MAKE-UP WATER
OF	OVERFLOW
D	DRAIN
FL	FILL LINE
G	NATURAL GAS
GV	GAS VENT
SW	SOFT WATER
SMS	SNOWMELT SUPPLY
SMR	SNOWMELT RETURN
CHWS	CHILLED WATER SUPPLY
CHWR	CHILLED WATER RETURN

PIPING ELEMENTS / VALVING

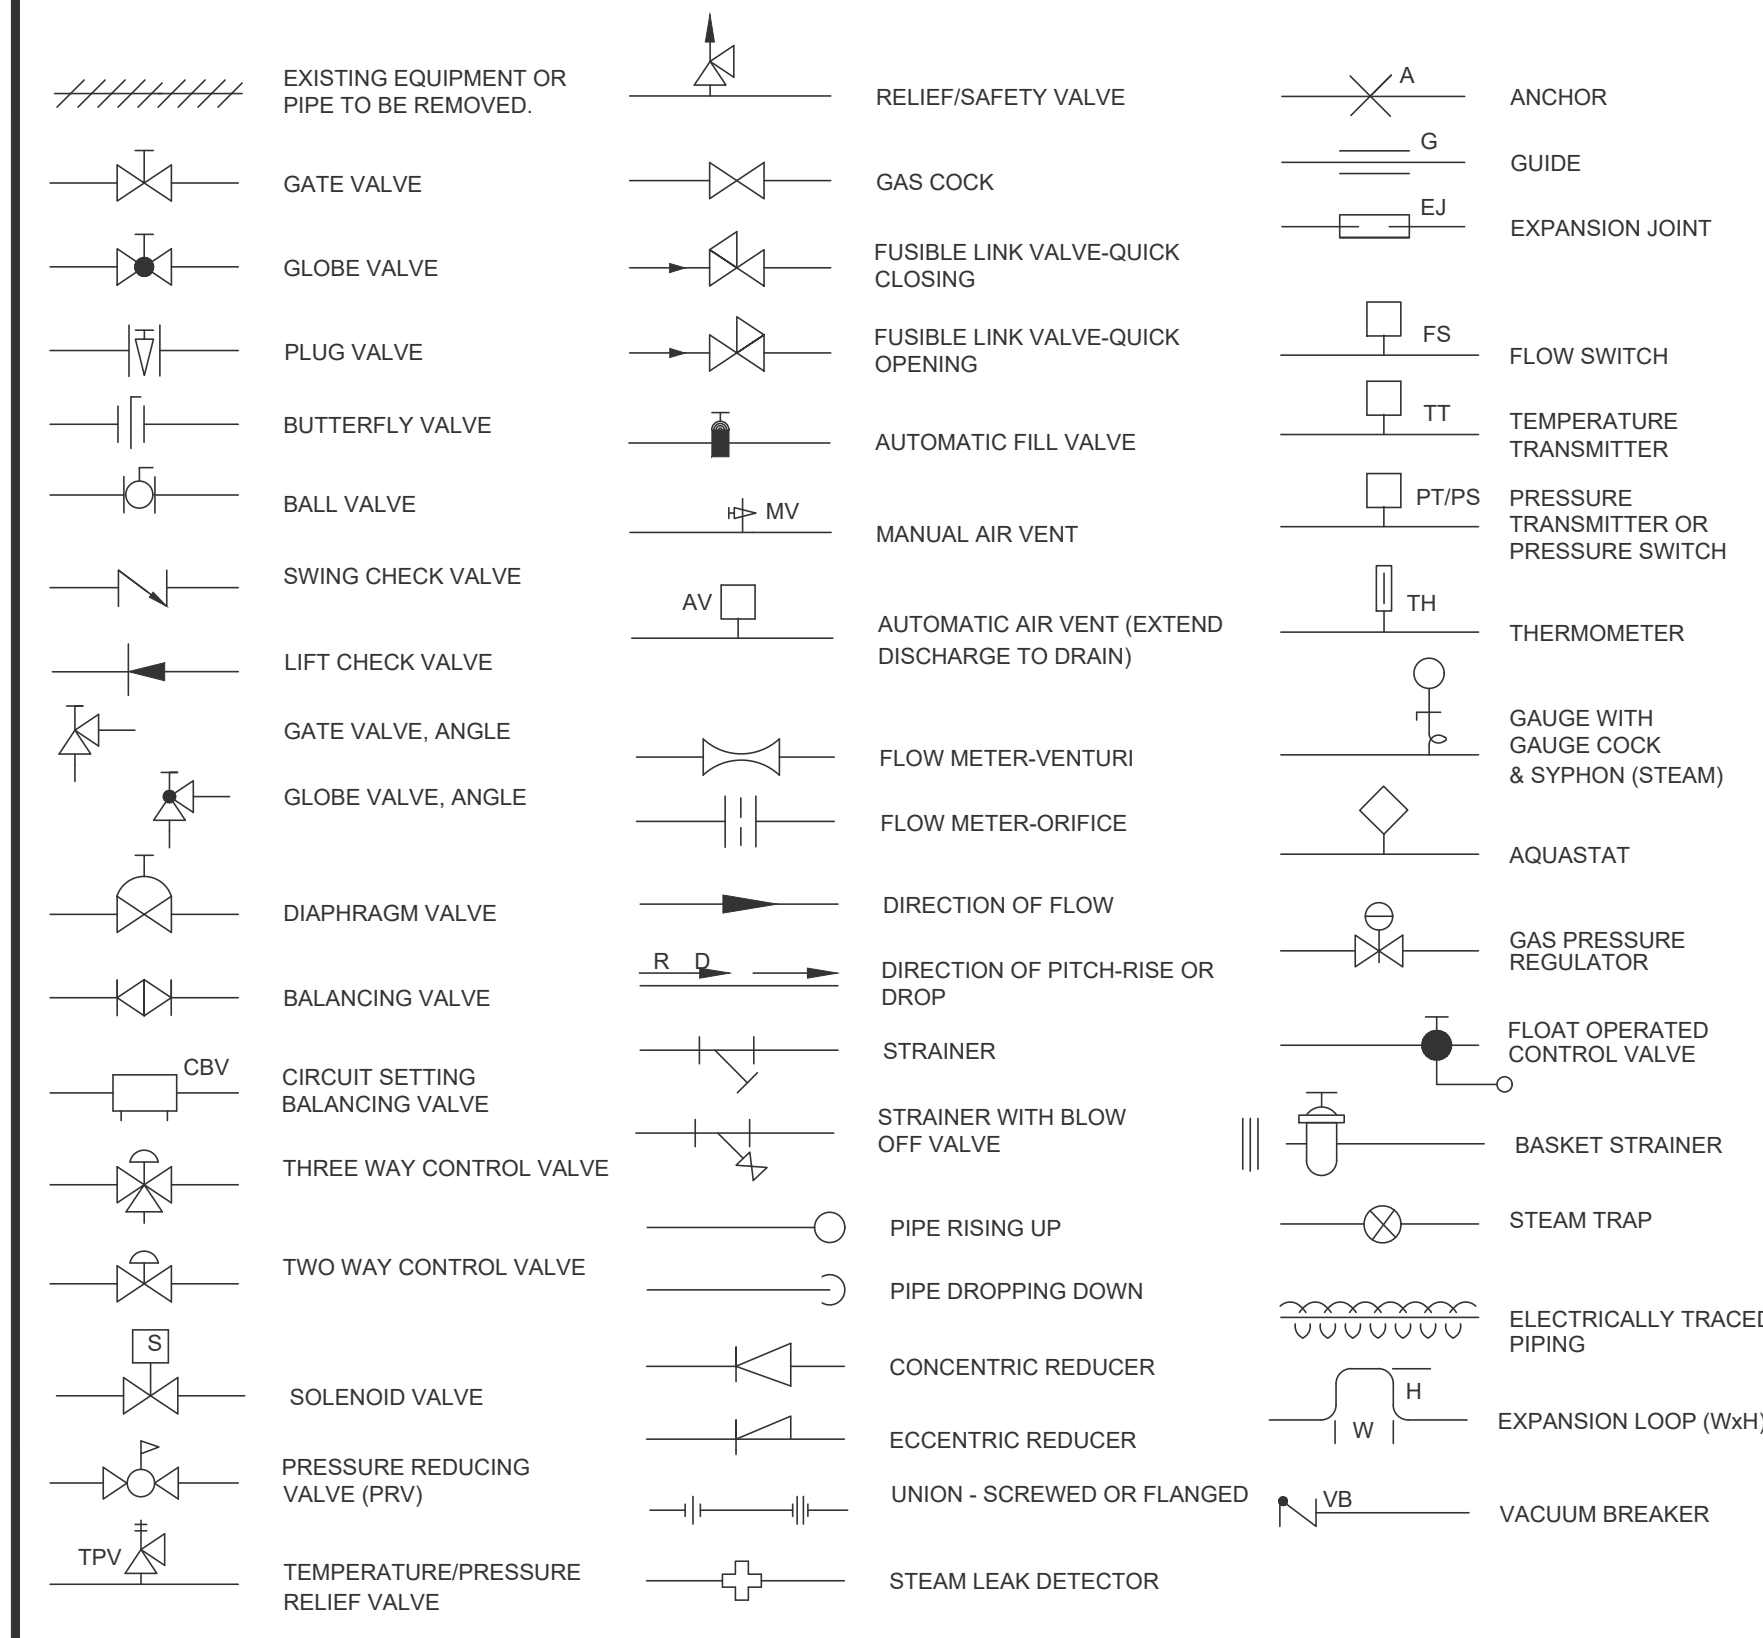

HVAC & DUCTWORK SYMBOLS

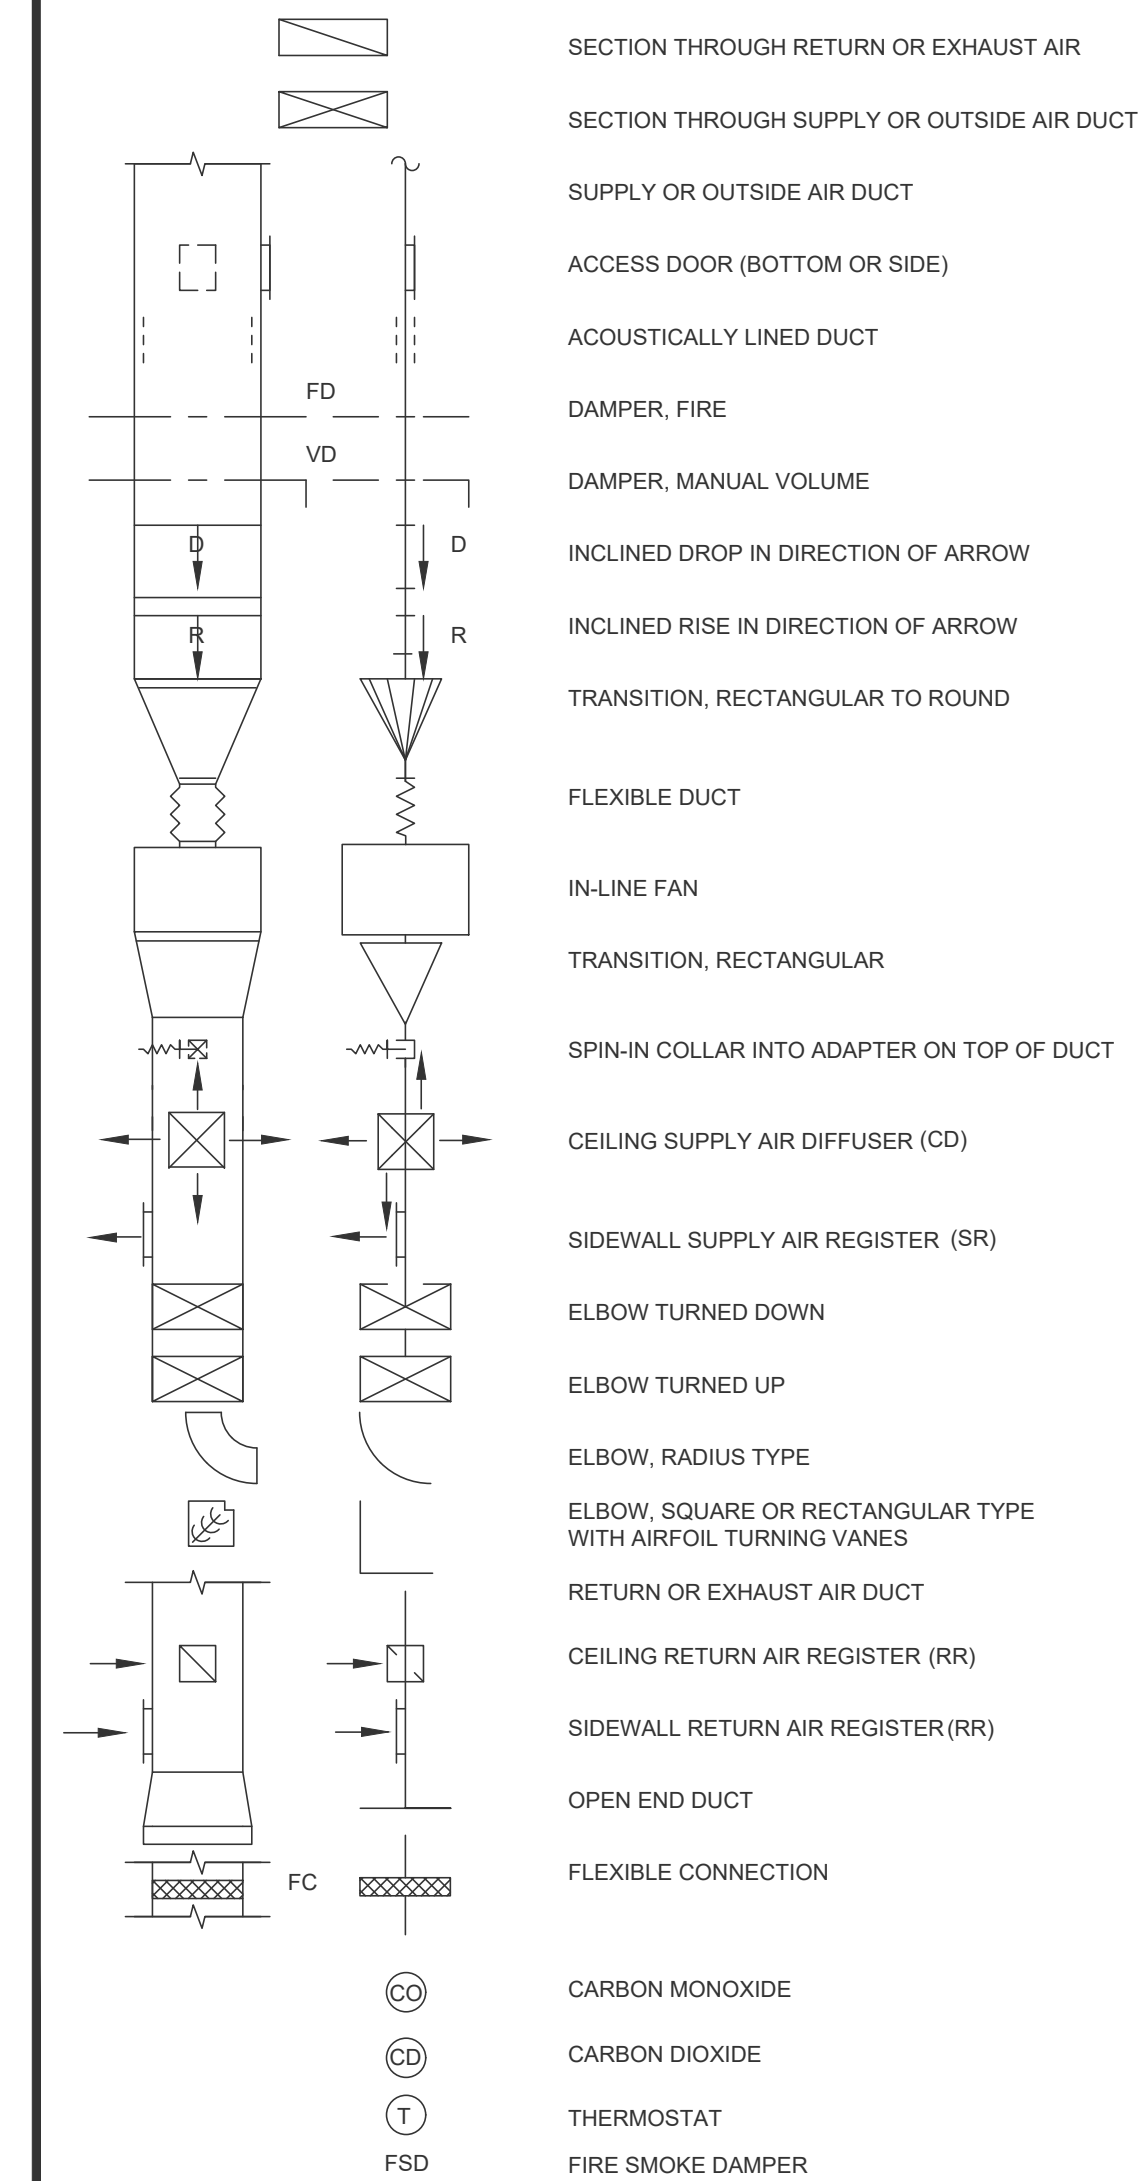

RESPONSIBLE DIVISION


UNLESS OTHERWISE INDICATED ALL HEATING, VENTILATING, AIR CONDITIONING, PLUMBING, AND OTHER MECHANICAL EQUIPMENT, MOTORS, AND CONTROLS SHALL BE FURNISHED, SET IN PLACE AND WIRED AS FOLLOWS:

ITEM	FURNISHED	SET	POWER WIRED	CONTROL WIRED
EQUIPMENT COMBINATION MAGNETIC MOTOR STARTERS, MAGNETIC MOTOR STARTERS AND CONTACTORS	23	23	26	--
FUSED AND UNFUSED DISCONNECT SWITCHES, THERMAL OVERLOAD SWITCHES AND HEATERS, MANUAL MOTOR STARTERS	26(1)	26(1)	26	--
MANUAL-OPERATING AND MULTI-SPEED SWITCHES	23	26	26	26
CONTROLS, RELAYS, TRANSFORMERS	23	23	26	23
THERMOSTATS (LOW VOLTAGE) AND TIME SWITCHES	23	23	26	23
THERMOSTATS(LINE VOLTAGE)	23	23	26	26
TEMPERATURE CONTROL PANELS	23	23	26	23
MOTOR AND SOLENOID VALVES, DAMPER MOTORS, PE & EP SWITCHES	23	23(2)	--	23(2)
PUSH-BUTTON STATIONS AND PILOT LIGHTS	23	23(2)	--	23(2)
HEATING, COOLING, VENTILATION AND AIR CONDITIONING CONTROLS	23	23	26	23
EXHAUST FAN SWITCHES	23	26	26	23(2)

- SUBSCRIPT FOOTNOTES:
 1) UNDER DIVISION 23 IF FURNISHED FACTORY-WIRED AS PART OF EQUIPMENT OR IF FURNISHED WITH COMBINATION STARTERS.
 2) IF ITEM IS FOR LINE VOLTAGE, SET IN PLACE AND CONNECT UNDER DIVISION 26. WHERE FACTORY MOUNTED ON EQUIPMENT OR ATTACHED TO PIPING OR DUCTS AND USING LINE VOLTAGE FURNISH AND SET UNDER DIVISION 23. CONNECT UNDER DIVISION 26.

DO NOT REPRODUCE THESE DRAWINGS AND SPECIFICATIONS WITHOUT THE EXPRESSED WRITTEN PERMISSION OF THE DESIGNER. THE DRAWINGS AND SPECIFICATIONS ARE INSTRUMENTS OF THE SERVICE AND SHALL REMAIN THE PROPERTY OF THE DESIGNER. WHETHER THE PROJECT FOR WHICH THEY ARE MADE IS EXECUTED OR NOT. THESE DRAWINGS AND SPECIFICATIONS SHALL NOT BE USED BY ANYONE ON ANY OTHER PROJECTS FOR ADDITIONS TO THIS PROJECT BY OTHERS EXCEPT BY THE EXPRESSED WRITTEN PERMISSION OF THE DESIGNER.

101 W 11th Street #109-C
Durango, CO 81301
Phone: (970) 422-7676

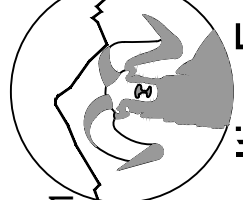

Bighorn Consulting Engineers, Inc.
Mechanical & Electrical Engineers


386 Indian Road
Grand Junction, CO 81501
Phone: (970) 241-8709

THE AVALON
LOBBY AND STAGE UPGRADES
645 MAIN STREET
GRAND JUNCTION, COLORADO


DATE: 04/16/2020
ISSUED FOR: FOR CONSTRUCTION

DATE: 4-16-2020
JOB NO: 20-039
DRAWN BY: BCE
CHECKED BY: BCE
SCALE: AS SHOWN

SHEET NUMBER: MO-1

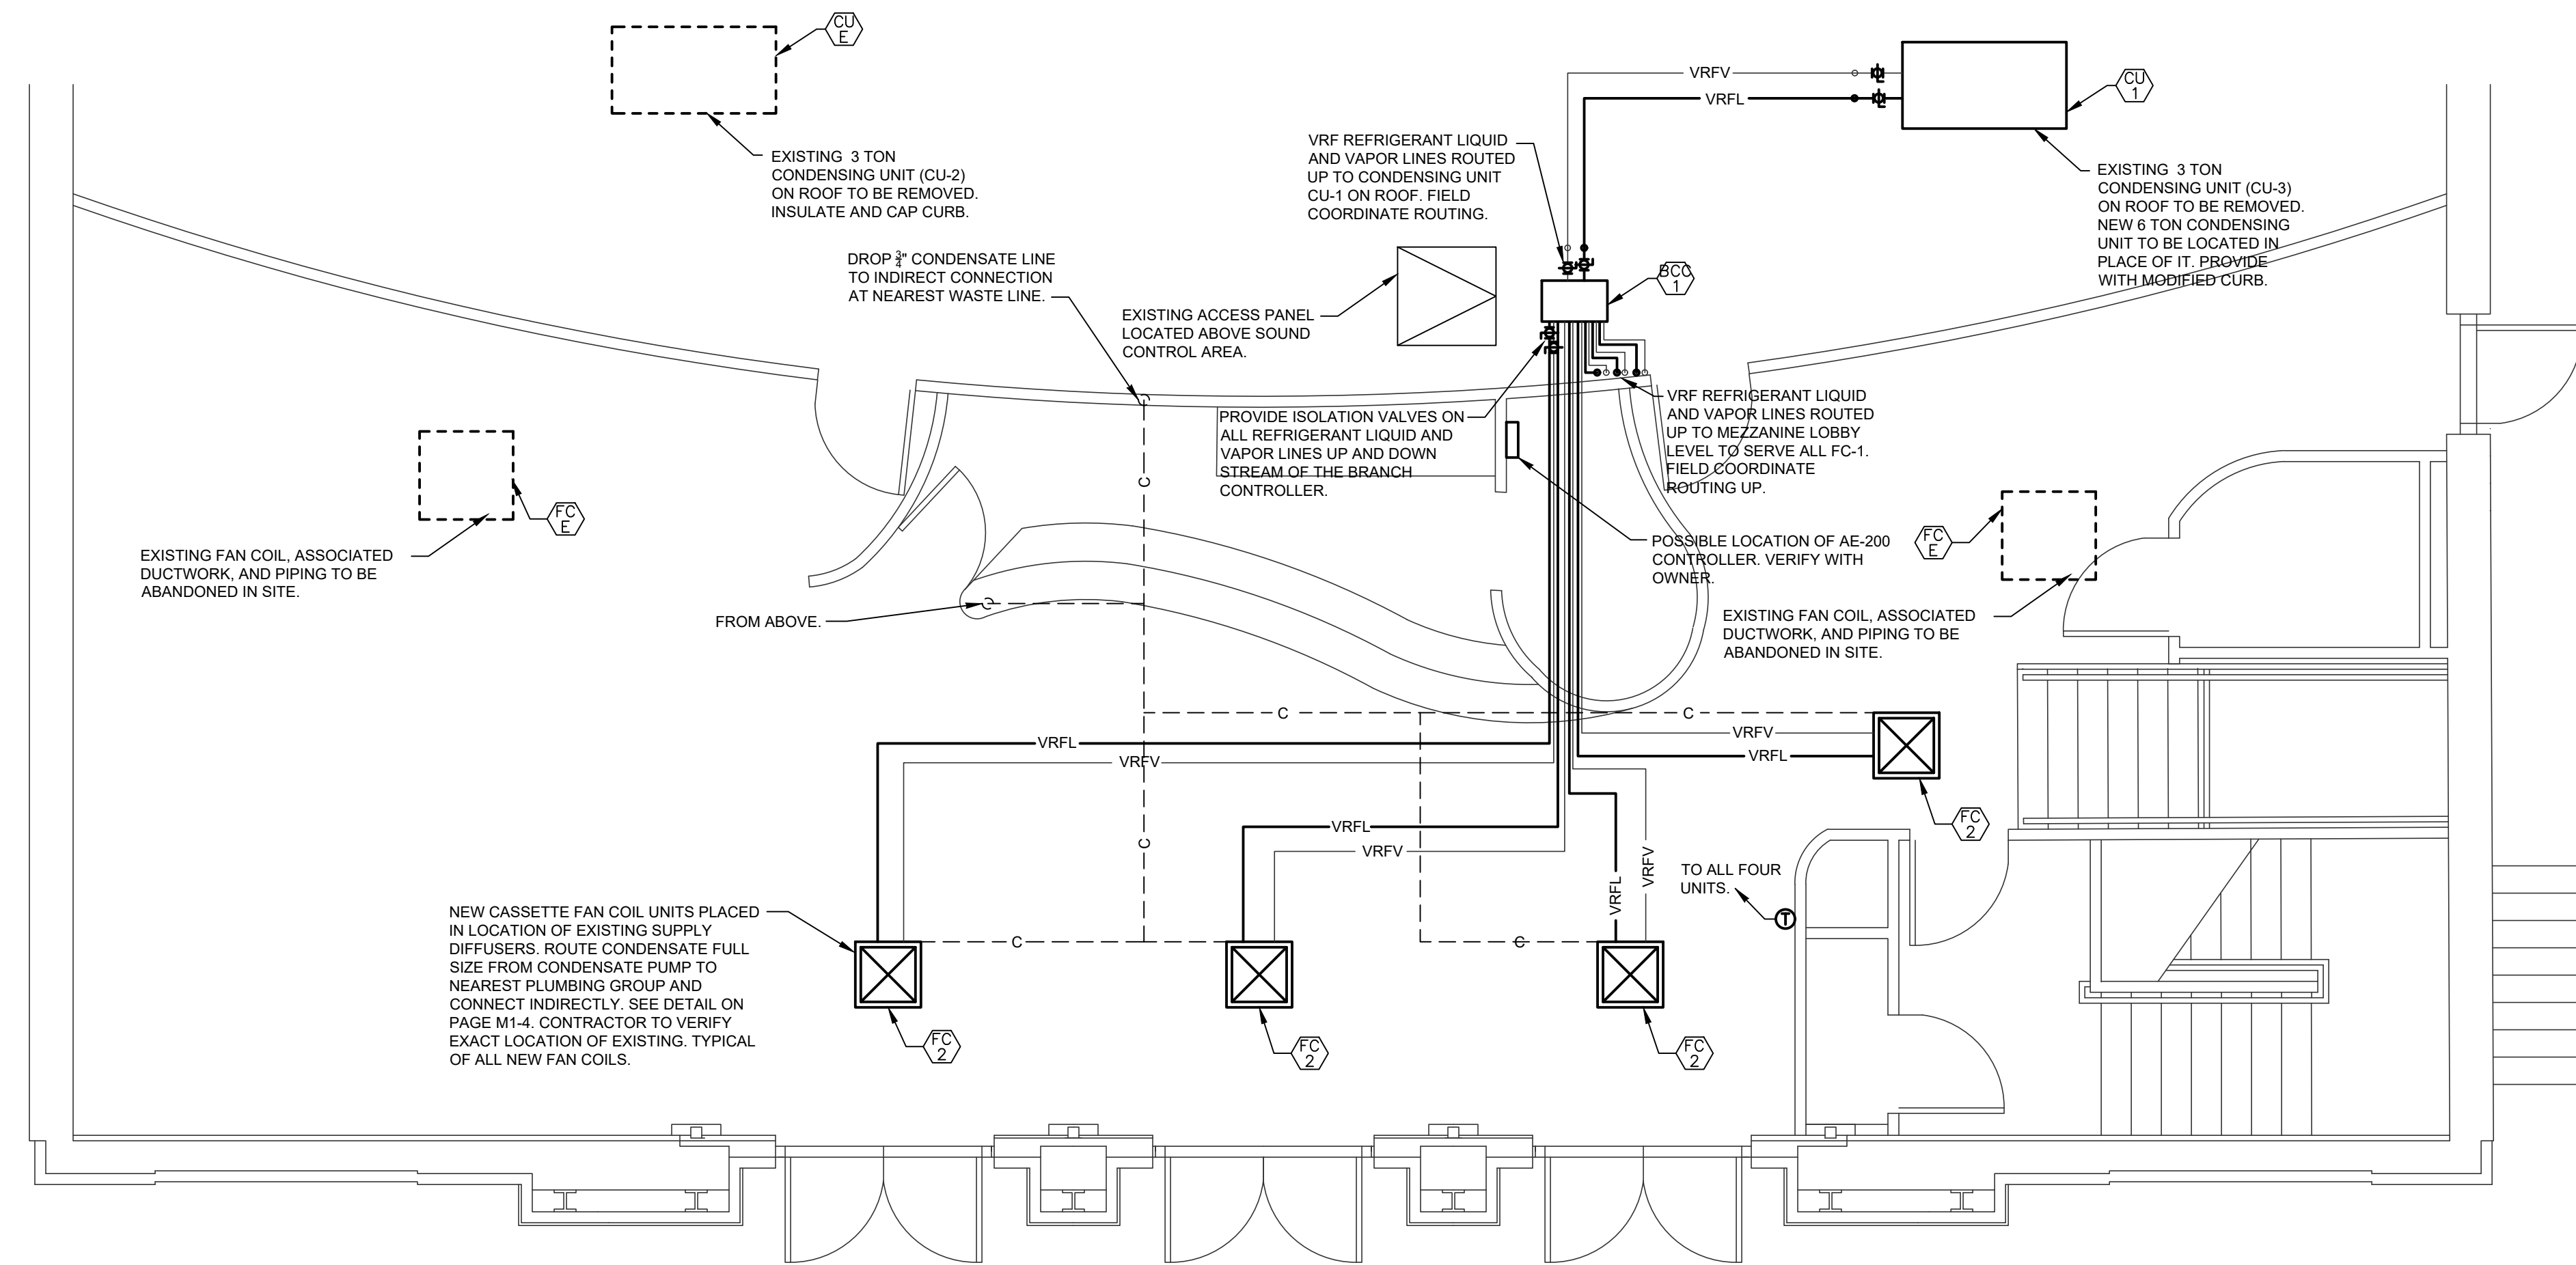

MECHANICAL - MAIN LOBBY FLOOR PLAN
 SCALE: 1/4"=1'-0"
 NORTH

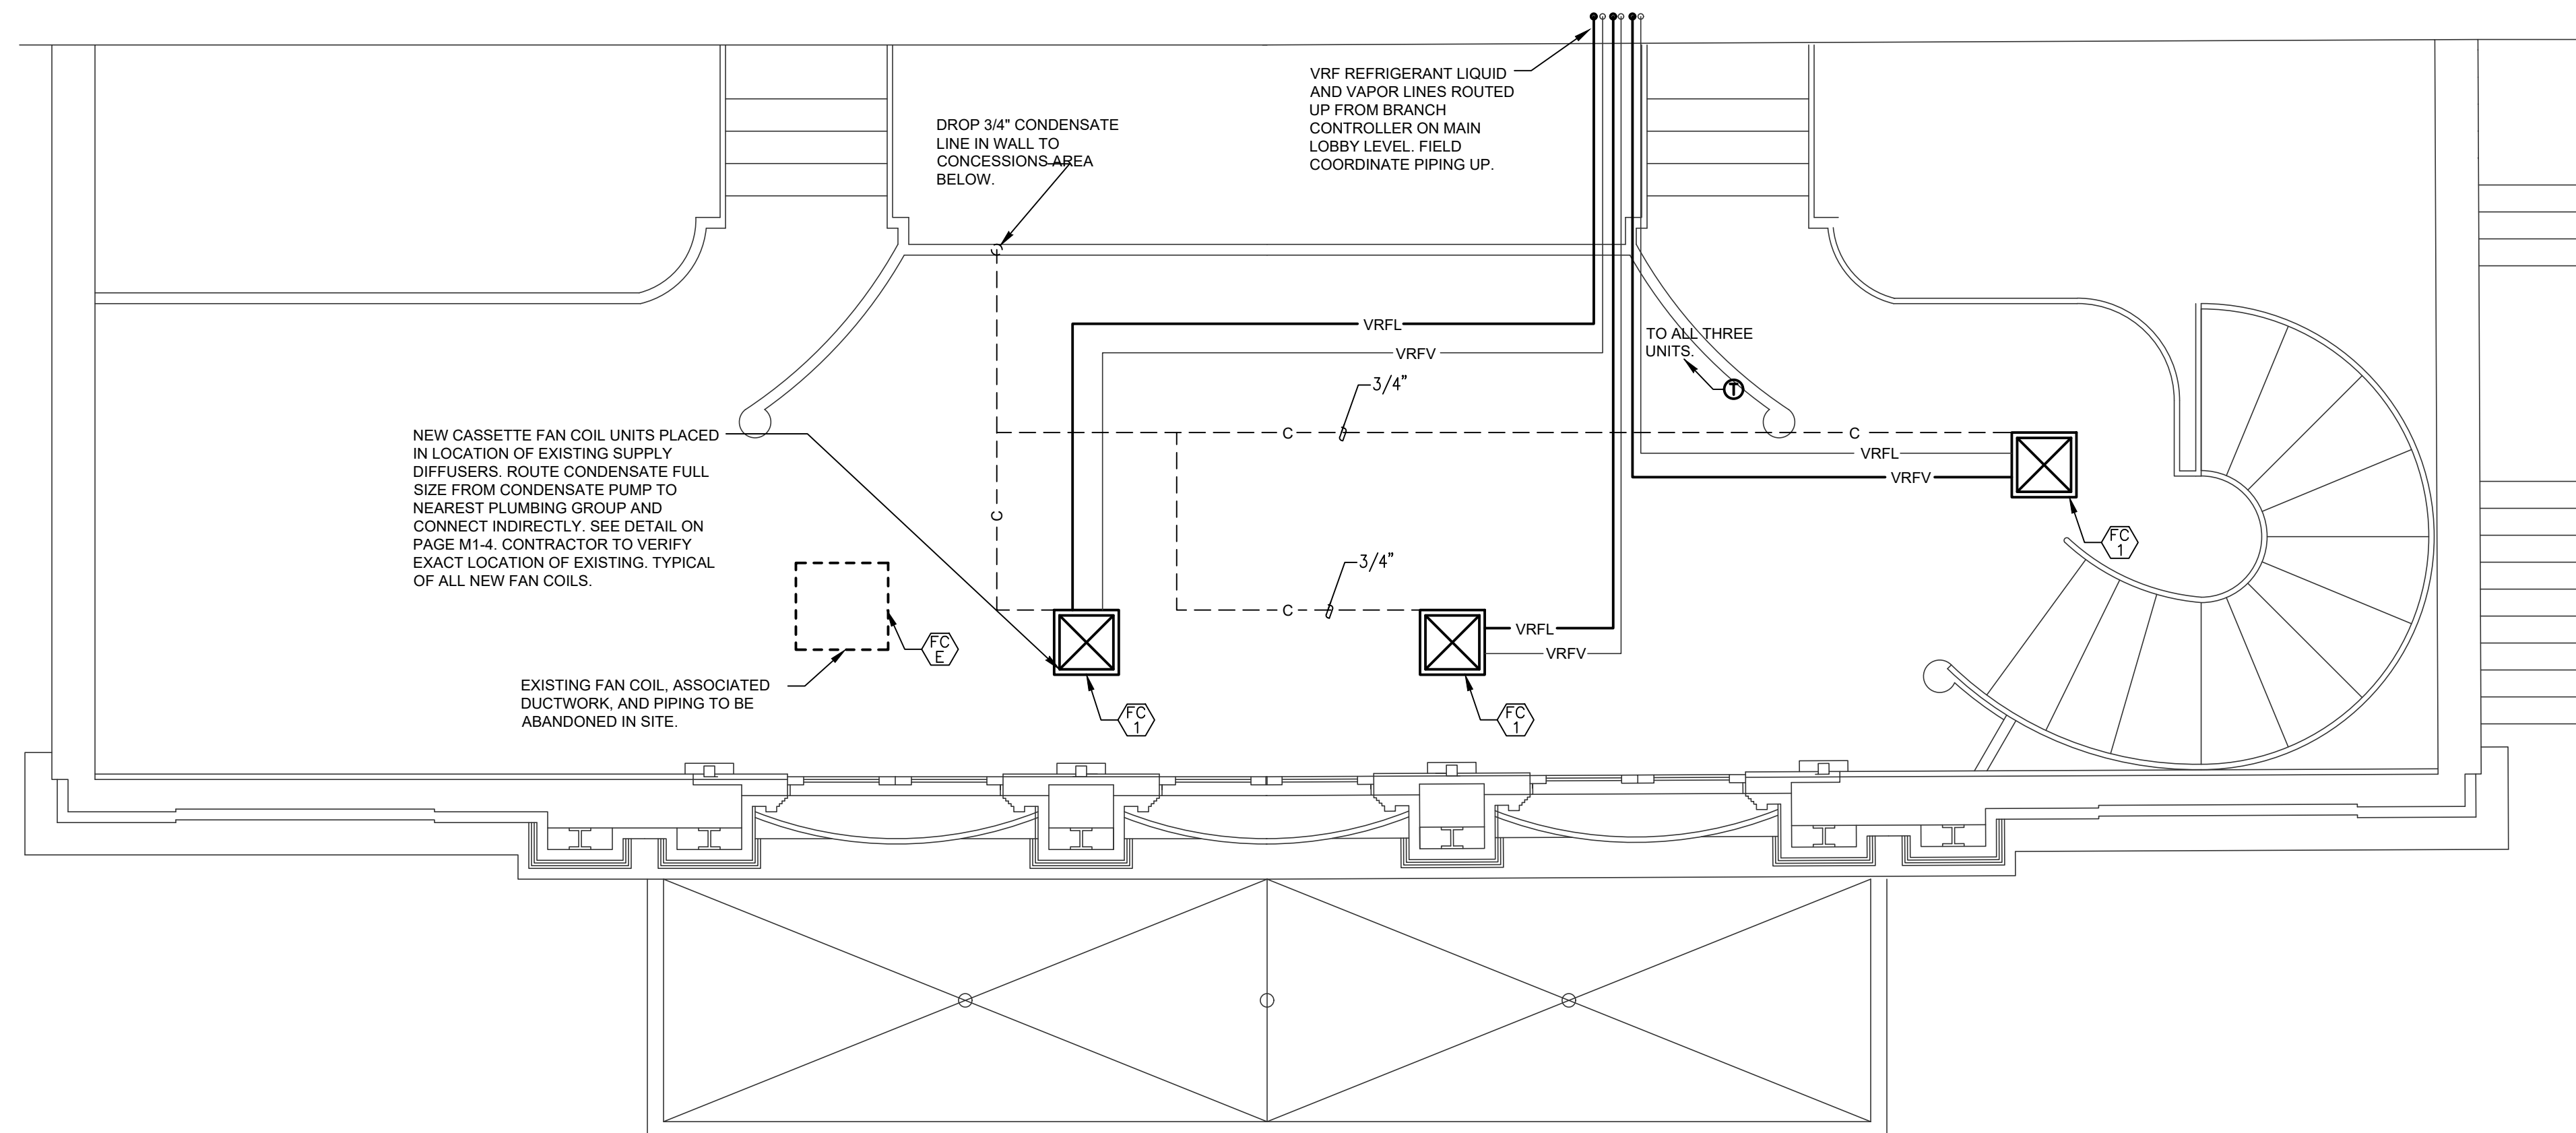


MECHANICAL - MEZZANINE LOBBY FLOOR PLAN
 SCALE: 1/4"=1'-0"
 NORTH

MECHANICAL GENERAL NOTES:

- DRAWING IS DIAGRAMMATIC IN NATURE. LOCATIONS AND SIZES MAY VARY DURING FIELD COORDINATION & INSTALLATION OF MECHANICAL, PLUMBING, & ELECTRICAL. DRAWINGS DO NOT NECESSARILY INDICATE EVERY REQUIRED OFFSET, FITTING, ETC. DRAWINGS ARE NOT TO BE SCALED FOR DIMENSIONS. TAKE ALL DIMENSIONS FROM ARCHITECTURAL DRAWINGS, CERTIFIED EQUIPMENT DRAWINGS AND FROM THE STRUCTURE ITSELF BEFORE FABRICATING ANY WORK. VERIFY ALL SPACE REQUIREMENTS COORDINATING WITH OTHER TRADES, AND INSTALL THE SYSTEMS IN THE SPACE PROVIDED WITHOUT EXTRA CHARGES TO THE OWNER.
- CONTRACTOR TO FIELD VERIFY LOCATIONS OF ALL EXISTING MECHANICAL EQUIPMENT AND DUCTWORK.
- EXISTING FAN COILS, ASSOCIATED DUCTWORK, AND PIPING TO BE ABANDONED IN SITE. EXISTING CONDENSING UNITS ON ROOF TO BE REMOVED.
- MAIN LOBBY AND MEZZANINE LOBBY TO BE NATURALLY VENTILATED PER 2018 I.M.C SECTION 402.2.
- IN LOCATIONS WHERE ROOF TOP EQUIPMENT IS TO BE REMOVED, INSULATE AND CAP CURB UNLESS OTHERWISE STATED.
- NEW RTU-S AND VRF AE-200 TO BE CONNECTED TO THE EXISTING TRANE TRACER SD SYSTEM AND COM TRUNK IN THE BUILDING. PROVIDE ALL COMMUNICATIONS INTERFACE NECESSARY AND PROVIDE PROGRAMMING AS NEEDED FOR INTERFACE.

DO NOT REPRODUCE THESE DRAWINGS AND SPECIFICATIONS WITHOUT THE EXPRESSED WRITTEN PERMISSION OF THE DESIGNER. THE DRAWINGS AND SPECIFICATIONS ARE INSTRUMENTS OF THE SERVICE AND SHALL REMAIN THE PROPERTY OF THE DESIGNER. WHETHER THE PROJECT FOR WHICH THEY ARE MADE IS EXECUTED OR NOT. THESE DRAWINGS AND SPECIFICATIONS SHALL NOT BE USED BY ANYONE ON ANY OTHER PROJECTS FOR ADDITIONS TO THIS PROJECT BY OTHERS EXCEPT BY THE EXPRESSED WRITTEN PERMISSION OF THE DESIGNER.

101 W 11th Street #109-C
 Durango, CO 81301
 Phone: (970) 422-7676

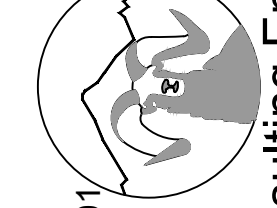

386 Indian Road
 Grand Junction, CO 81501
 Phone: (970) 241-8709

Bighorn Consulting Engineers, Inc.
 Mechanical & Electrical Engineers

THE AVALON
LOBBY AND STAGE UPGRADES
 645 MAIN STREET
 GRAND JUNCTION, COLORADO

DATE: 04/16/2020
 ISSUED FOR: FOR CONSTRUCTION

DATE: 4-16-2020
 JOB NO: 20-039
 DRAWN BY: BCE
 CHECKED BY: BCE
 SCALE: AS SHOWN

SHEET NUMBER:
M1-1

DO NOT REPRODUCE THESE DRAWINGS AND SPECIFICATIONS WITHOUT THE EXPRESSED WRITTEN PERMISSION OF THE DESIGNER. THE DRAWINGS AND SPECIFICATIONS ARE INSTRUMENTS OF THE SERVICE AND SHALL REMAIN THE PROPERTY OF THE DESIGNER. WHETHER THE PROJECT FOR WHICH THEY ARE MADE IS EXECUTED OR NOT. THESE DRAWINGS AND SPECIFICATIONS SHALL NOT BE USED BY ANYONE ON ANY OTHER PROJECTS FOR ADDITIONS TO THIS PROJECT BY OTHERS EXCEPT BY THE EXPRESSED WRITTEN PERMISSION OF THE DESIGNER.

101 W 11th Street #109-C
Durango, CO 81301
Phone: (970) 422-7676


386 Indian Road
Grand Junction, CO 81501
Phone: (970) 241-8709

Bighorn Consulting Engineers, Inc.
Mechanical & Electrical Engineers

THE AVALON
LOBBY AND STAGE UPGRADES
645 MAIN STREET
GRAND JUNCTION, COLORADO

DATE:	ISSUED FOR:
04/16/2020	FOR CONSTRUCTION

DATE:	4-16-2020
JOB NO:	20-039
DRAWN BY:	BCE
CHECKED BY:	BCE
SCALE:	AS SHOWN
SHEET NUMBER:	M1-2

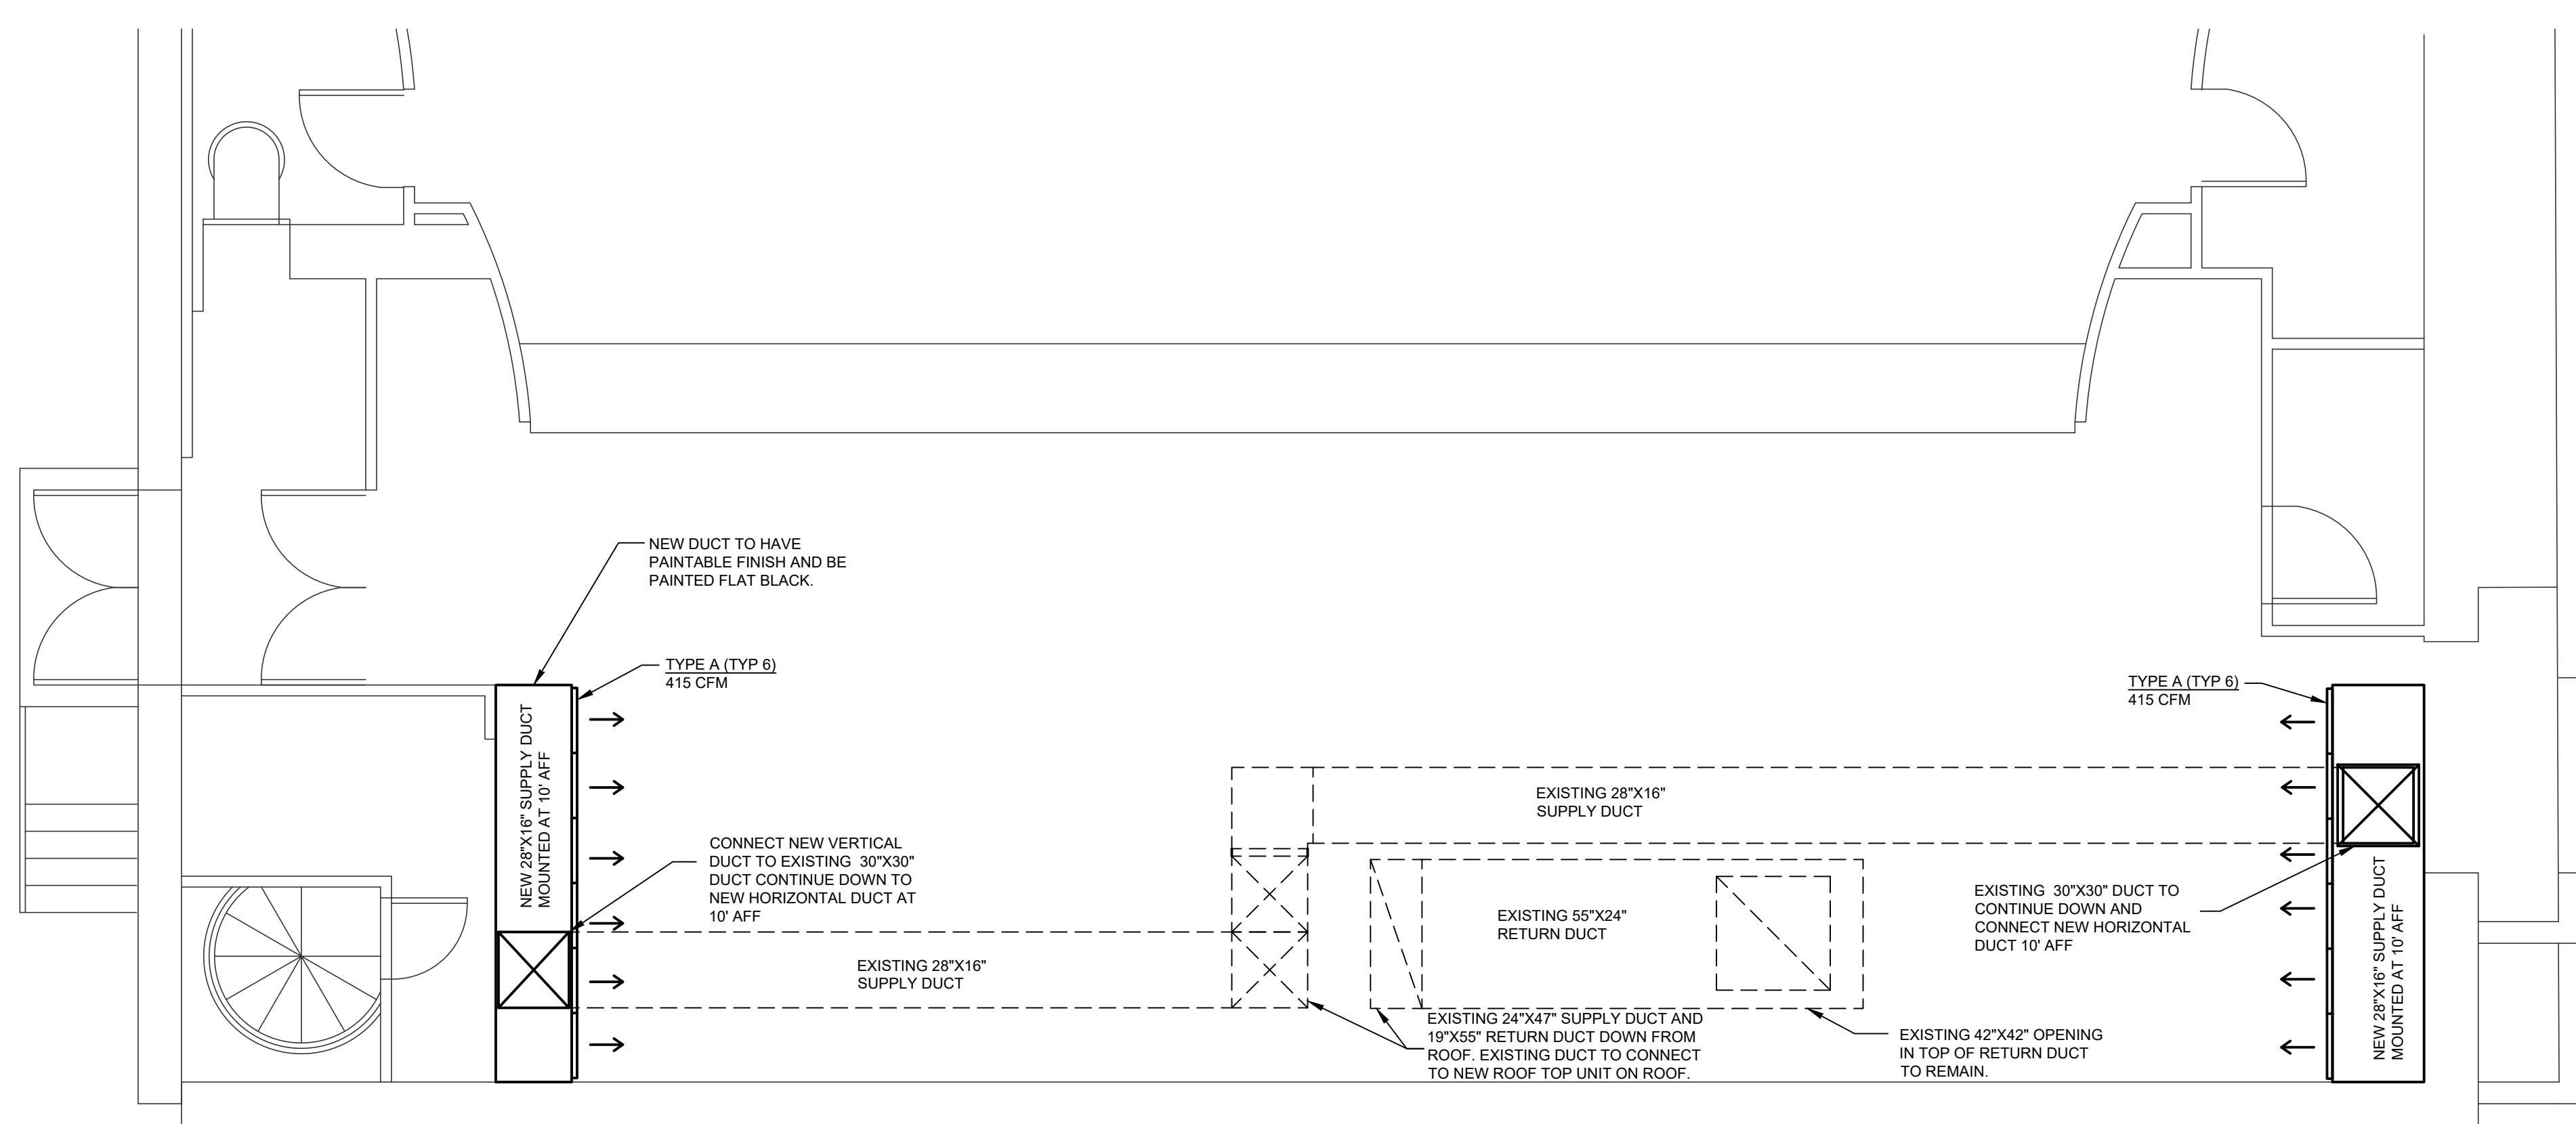


MECHANICAL - STAGE FLOOR PLAN
SCALE: 1/4"=1'-0"

- MECHANICAL GENERAL NOTES:**
- DRAWING IS DIAGRAMMATIC IN NATURE. LOCATIONS AND SIZES MAY VARY DURING FIELD COORDINATION & INSTALLATION OF MECHANICAL, PLUMBING, & ELECTRICAL. DRAWINGS DO NOT NECESSARILY INDICATE EVERY REQUIRED OFFSET, FITTING, ETC. DRAWINGS ARE NOT TO BE SCALED FOR DIMENSIONS. TAKE ALL DIMENSIONS FROM ARCHITECTURAL DRAWINGS, CERTIFIED EQUIPMENT DRAWINGS AND FROM THE STRUCTURE ITSELF BEFORE FABRICATING ANY WORK. VERIFY ALL SPACE REQUIREMENTS COORDINATING WITH OTHER TRADES, AND INSTALL THE SYSTEMS IN THE SPACE PROVIDED WITHOUT EXTRA CHARGES TO THE OWNER.
 - CONTRACTOR TO FIELD VERIFY LOCATIONS OF ALL EXISTING MECHANICAL EQUIPMENT AND DUCTWORK.
 - EXISTING FAN COILS, ASSOCIATED DUCTWORK, AND PIPING TO BE ABANDONED IN SITE. EXISTING CONDENSING UNITS ON ROOF TO BE REMOVED.
 - MAIN LOBBY AND MEZZANINE LOBBY TO BE NATURALLY VENTILATED PER 2018 I.M.C SECTION 402.2.
 - IN LOCATIONS WHERE ROOF TOP EQUIPMENT IS TO BE REMOVED, INSULATE AND CAP CURB UNLESS OTHERWISE STATED.
 - THE NEW CONTROLS FROM MANUFACTURER TO EXISTING CITY TRANE TRACER SC SYSTEM.

DO NOT REPRODUCE THESE DRAWINGS AND SPECIFICATIONS WITHOUT THE EXPRESSED WRITTEN PERMISSION OF THE DESIGNER. THE DRAWINGS AND SPECIFICATIONS ARE INSTRUMENTS OF THE SERVICE AND SHALL REMAIN THE PROPERTY OF THE DESIGNER. WHETHER THE PROJECT FOR WHICH THEY ARE MADE IS EXECUTED OR NOT, THESE DRAWINGS AND SPECIFICATIONS SHALL NOT BE USED BY ANYONE ON ANY OTHER PROJECTS FOR ADDITIONS TO THIS PROJECT BY OTHERS EXCEPT BY THE EXPRESSED WRITTEN PERMISSION OF THE DESIGNER.

101 W 11th Street #109-C
Durango, CO 81301
Phone: (970) 422-7676

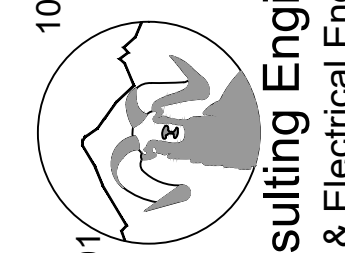

Bighorn Consulting Engineers, Inc.
Mechanical & Electrical Engineers


THE AVALON
LOBBY AND STAGE UPGRADES
645 MAIN STREET
GRAND JUNCTION, COLORADO

DATE:	ISSUED FOR:
04/16/2020	FOR CONSTRUCTION

DATE:	4-16-2020
JOB NO:	20-039
DRAWN BY:	BCE
CHECKED BY:	BCE
SCALE:	AS SHOWN
SHEET NUMBER:	M1-3

MECHANICAL GENERAL NOTES:

- DRAWING IS DIAGRAMMATIC IN NATURE. LOCATIONS AND SIZES MAY VARY DURING FIELD COORDINATION & INSTALLATION OF MECHANICAL, PLUMBING, & ELECTRICAL. DRAWINGS DO NOT NECESSARILY INDICATE EVERY REQUIRED OFFSET, FITTING, ETC. DRAWINGS ARE NOT TO BE SCALED FOR DIMENSIONS. TAKE ALL DIMENSIONS FROM ARCHITECTURAL DRAWINGS, CERTIFIED EQUIPMENT DRAWINGS AND FROM THE STRUCTURE ITSELF BEFORE FABRICATING ANY WORK. VERIFY ALL SPACE REQUIREMENTS COORDINATING WITH OTHER TRADES, AND INSTALL THE SYSTEMS IN THE SPACE PROVIDED WITHOUT EXTRA CHARGES TO THE OWNER.
- CONTRACTOR TO FIELD VERIFY LOCATIONS OF ALL EXISTING MECHANICAL EQUIPMENT AND DUCTWORK.
- EXISTING FAN COILS, ASSOCIATED DUCTWORK, AND PIPING TO BE ABANDONED IN SITE. EXISTING CONDENSING UNITS ON ROOF TO BE REMOVED.
- MAIN LOBBY AND MEZZANINE LOBBY TO BE NATURALLY VENTILATED PER 2018 I.M.C SECTION 402.2.
- IN LOCATIONS WHERE ROOF TOP EQUIPMENT IS TO BE REMOVED, INSULATE AND CAP CURB UNLESS OTHERWISE STATED.
- TIE NEW CONTROLS FROM MANUFACTURER TO EXISTING CITY TRANE TRACER SC SYSTEM.

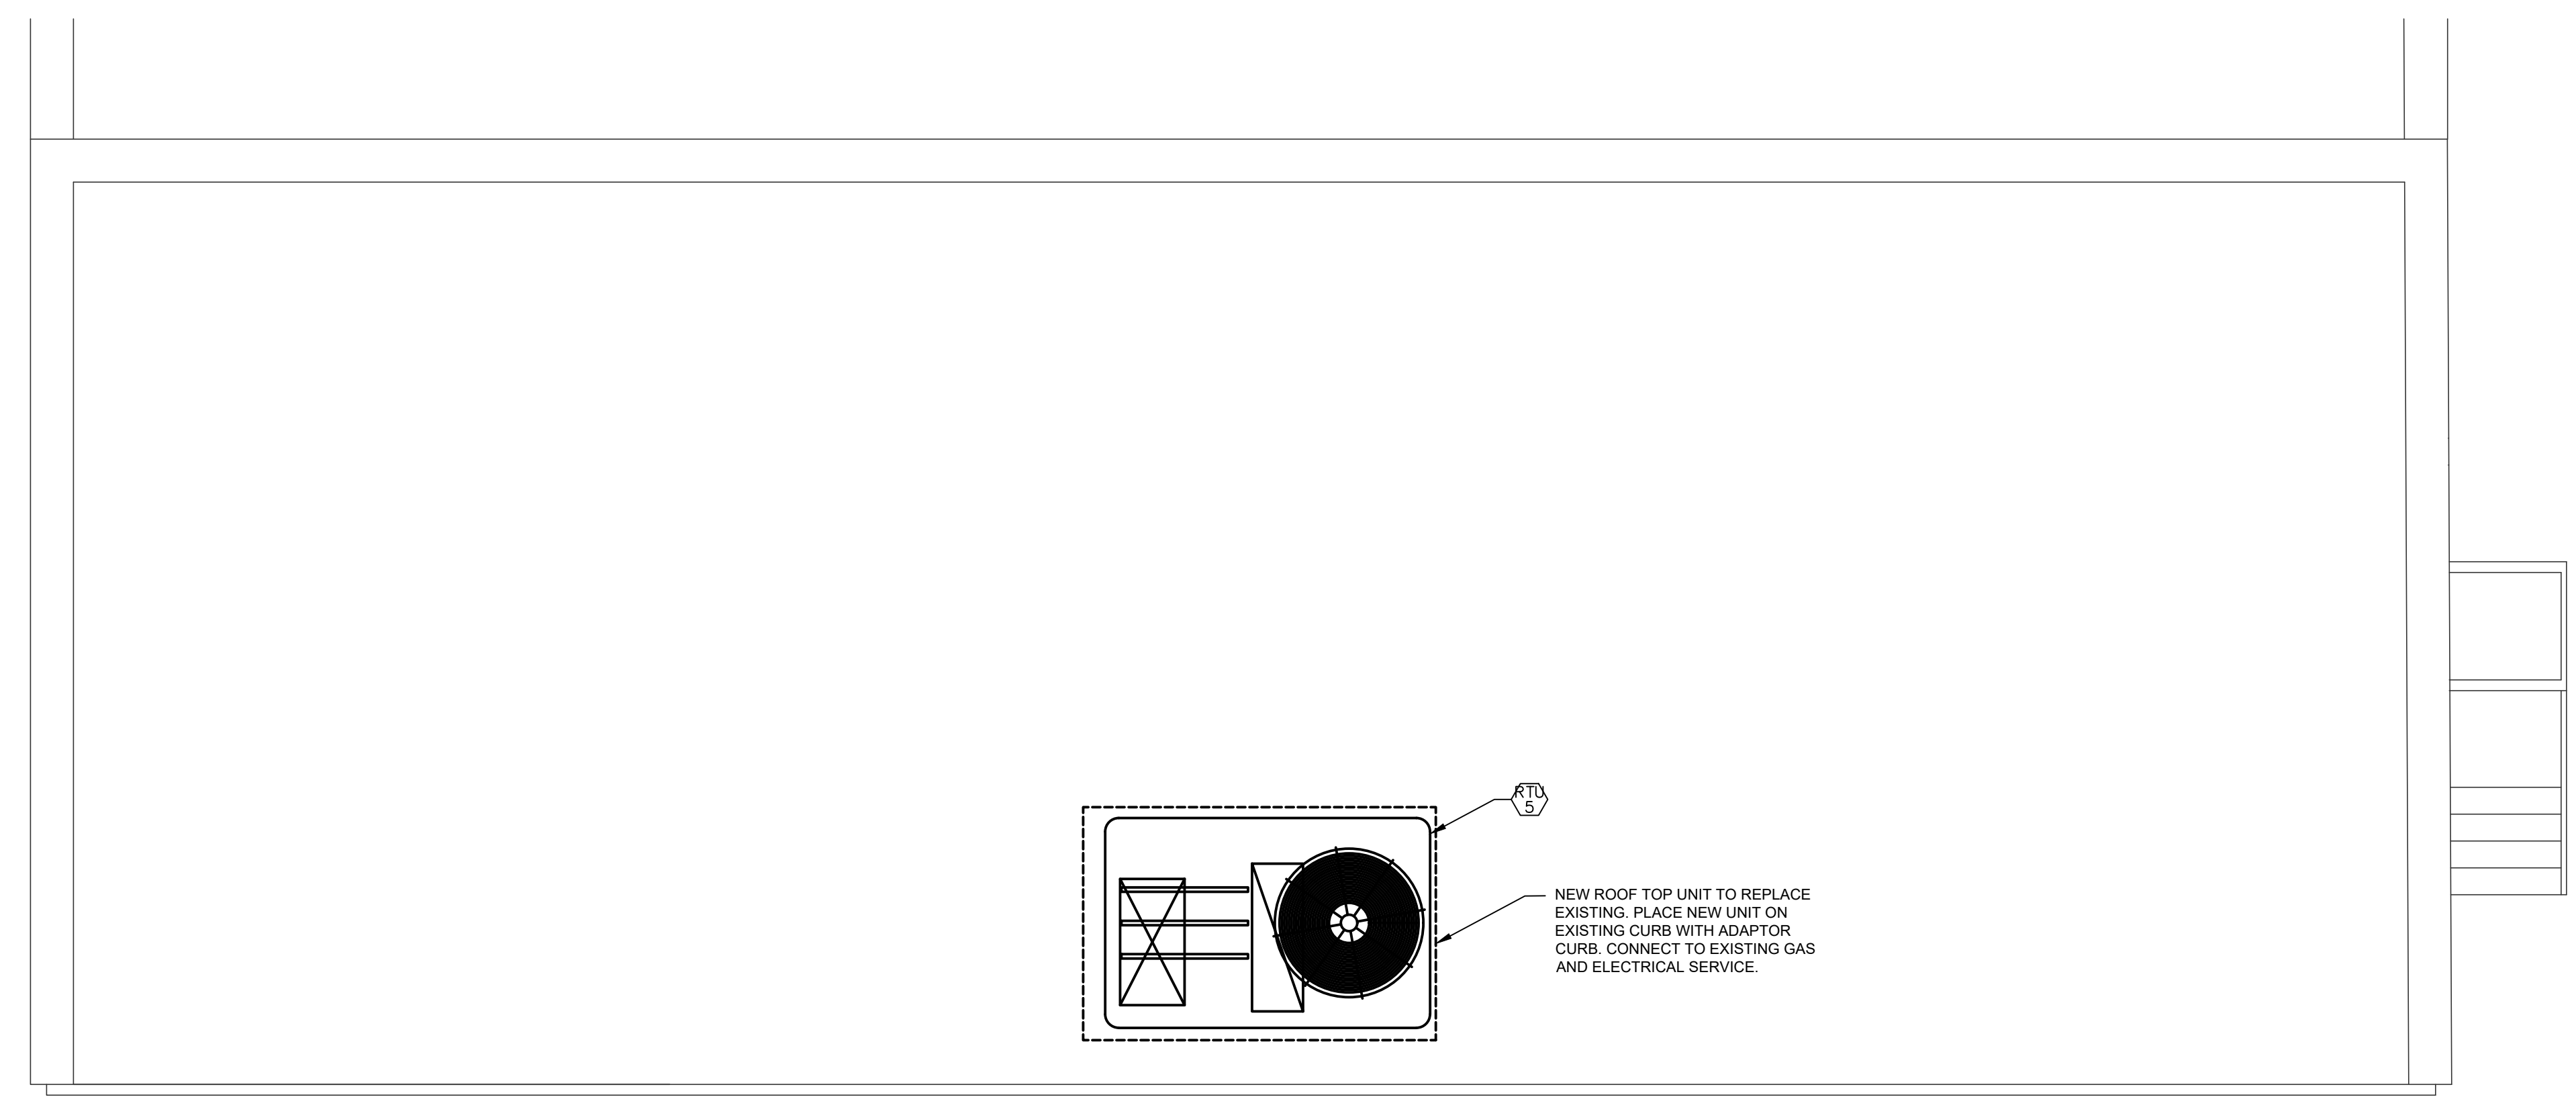


MECHANICAL - ROOF PLAN
SCALE: 1/4"=1'-0"



ROOFTOP AIR HANDLING UNIT SCHEDULE															
EQUIPMENT NO.	SERVICE	SUPPLY AIR (CFM)	OUTSIDE AIR (CFM)	E.S.P. (IN. W.G.)	HEATING			FILTERS	EVAP FAN (HP)	ELECTRICAL			UNIT WEIGHT (LBS.)	MANUFACTURER & MODEL	OPTIONS /ACCESSORIES
					NOM. (TONS)	GAS (CFH)	INPUT (MBH)			OUTPUT (MBH)	V./PH./HZ.	MCA (A)			
RTU-5	STAGE	5,000	1,500	1.0	12.5	283	250	200	2" MERV 8	5	208/3/60	61	80	YHD150	NOTE-1

NOTE:
1. PROVIDE WITH ADAPTER CURB, COIL GUARDS, TCI MODULE, 100% MODULATING ECONOMIZER, POWERED EXHAUST FAN, FACTORY UNITARY CONTROLS, FUSED DISCONNECT SWITCH, HIGH ALTITUDE KIT, POWERED CONVENIENCE OUTLET AND CO2 DEMAND CONTROLLED VENTILATION SENSOR AND SEQUENCE. PROVIDE RETURN DUCT SMOKE DETECTOR WITH AUDIBLE AND VISUAL ALARMS CONNECTED TO THE FIRE ALARM CONTROL PANEL.

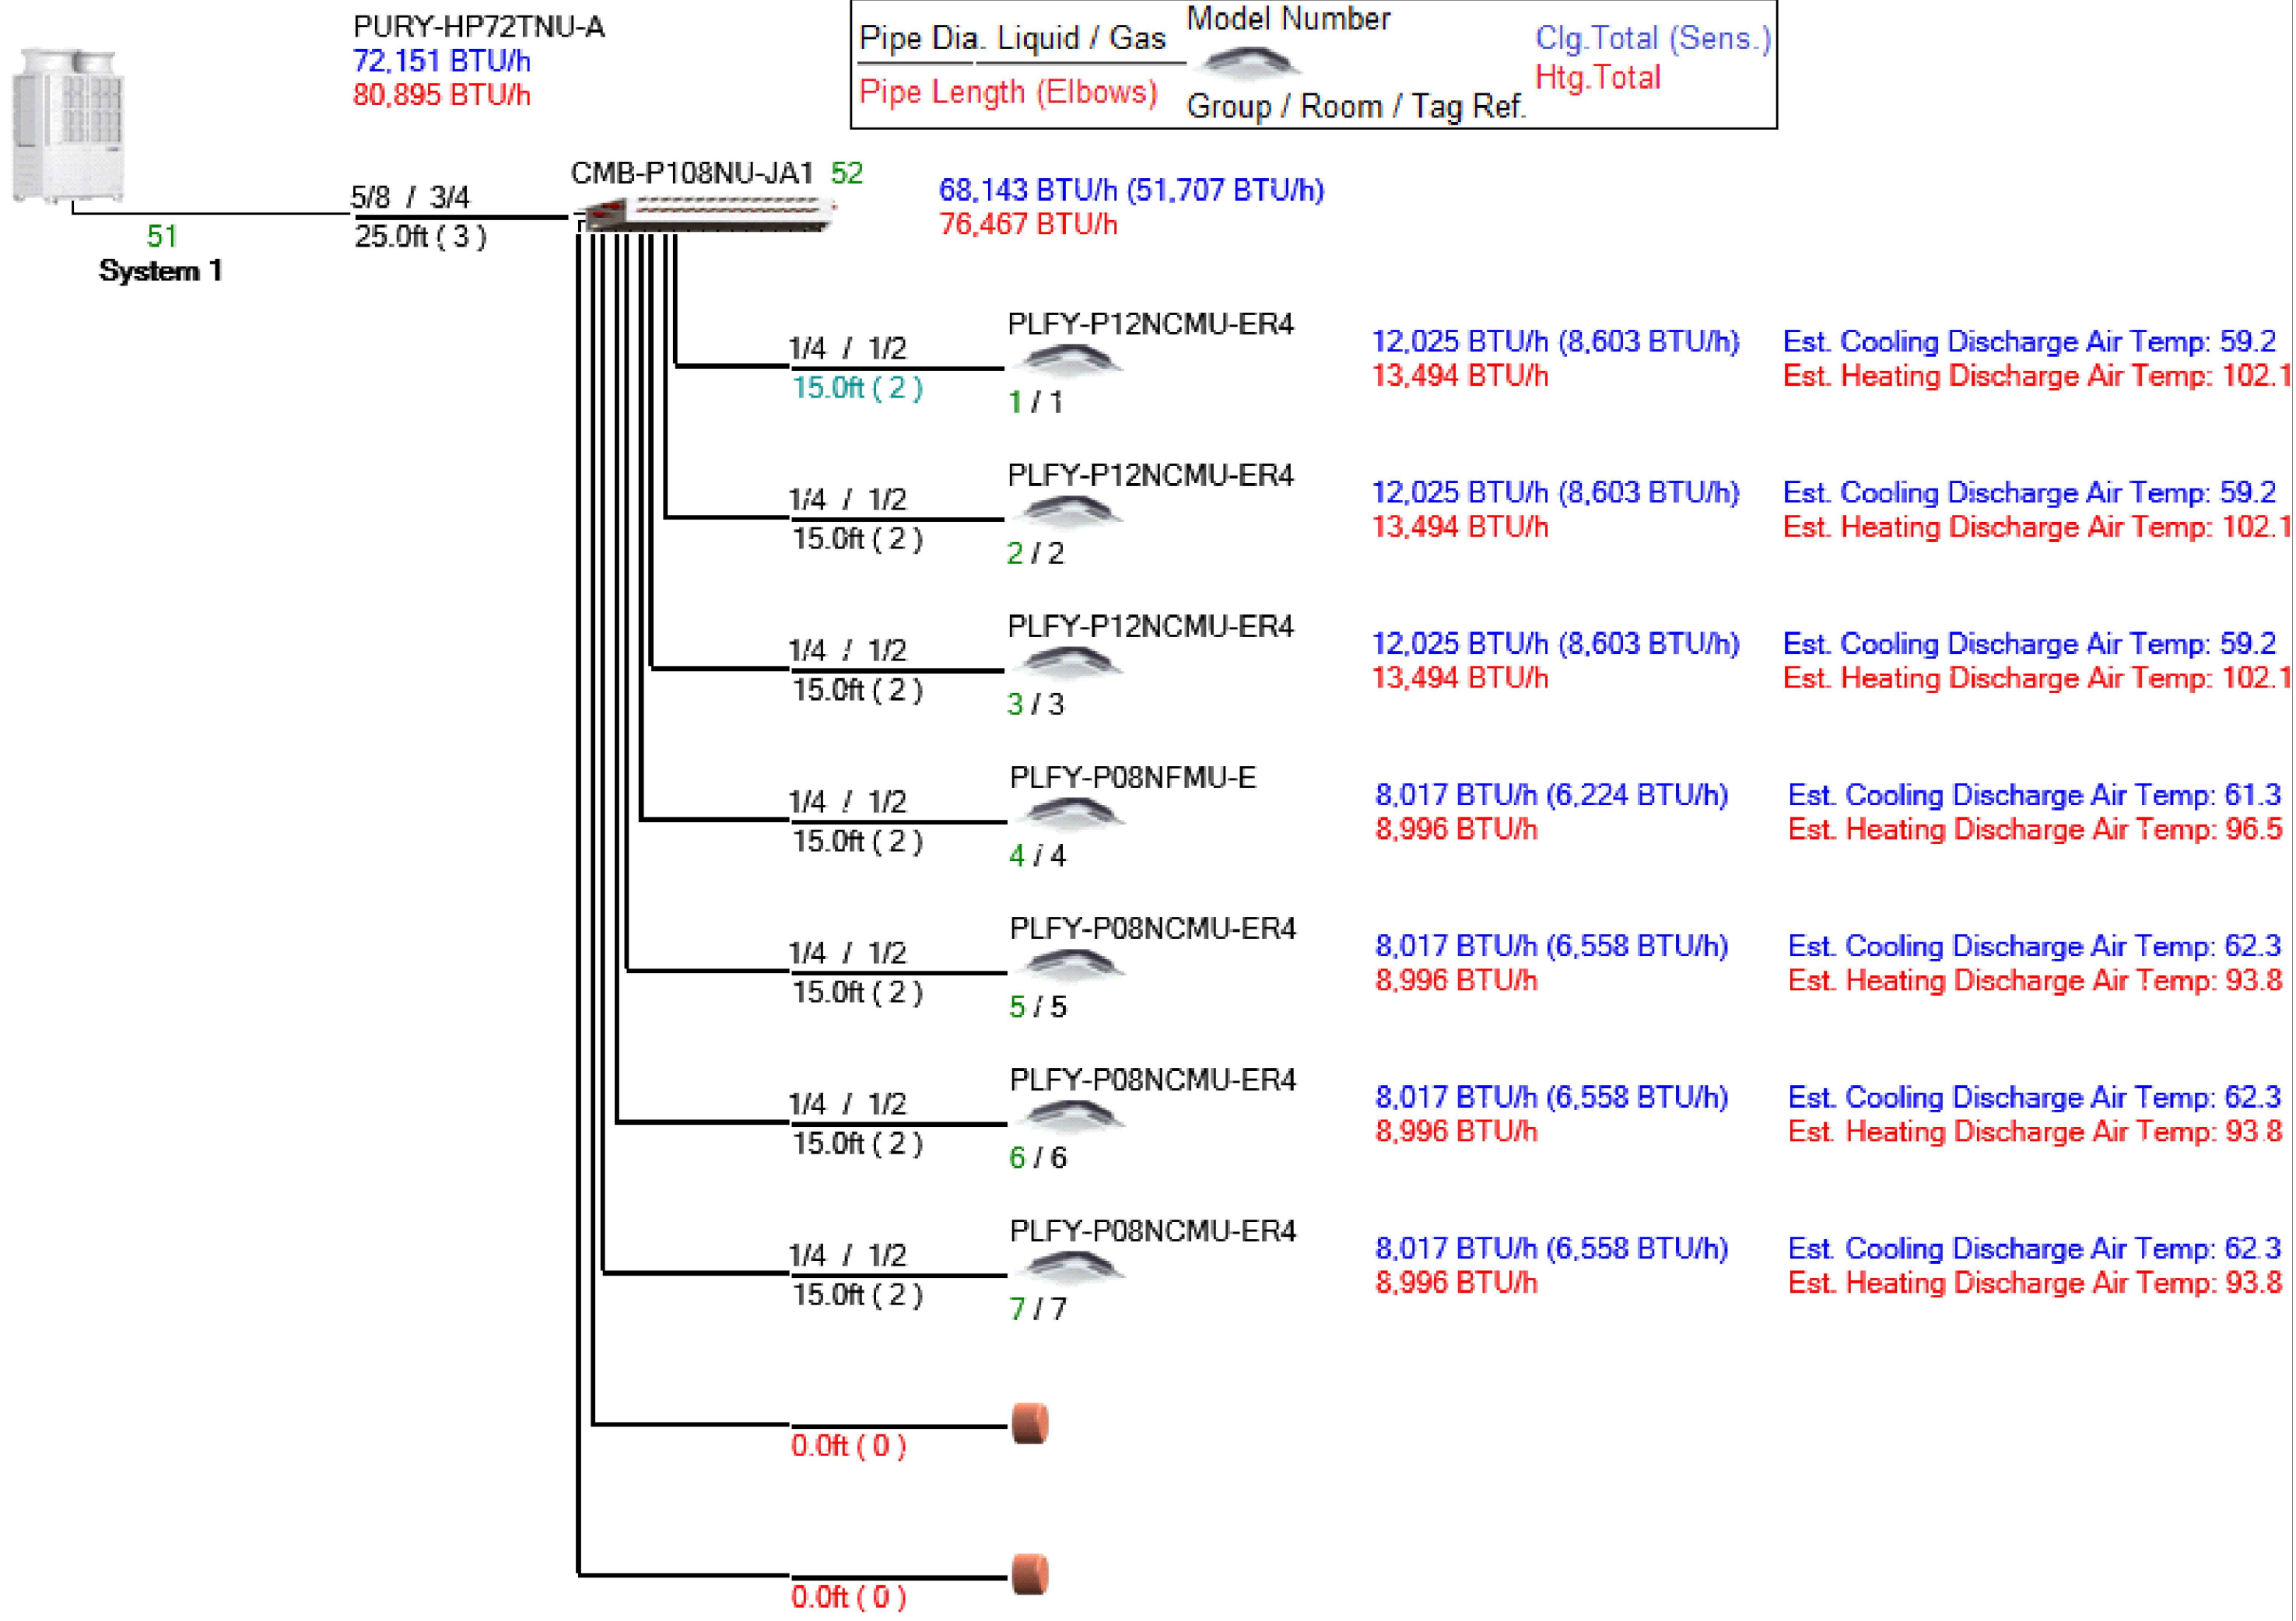

VRF AIR COOLED CONDENSING UNIT SCHEDULE										
EQUIPMENT NO.	SERVICE	NOMINAL COOLING CAPACITY (MBH)	NOMINAL HEATING CAPACITY (MBH)	REFRIG. PIPING		ELECTRIC		MANUFACTURER & MODEL	OPTIONS/ACCESSORIES	
				LIQUID	VAPOR	V./PH./HZ.	MOP (A)			MCA (A)
CU-1	VRF SYSTEM	72	80	5/8	3/4	208/3/60	60	38	MITSUBISHI PURY-HP72TNU-A	NOTE 1

NOTES:
1. PROVIDE LINE SET AS RECOMMENDED BY MANUFACTURER, POWER DISCONNECT, AE-200 CONTROLLER WITH BACNET, POWERED CONVENIENCE OUTLET.

VRF BRANCH CIRCUIT CONTROLLER SCHEDULE									
EQUIPMENT NO.	SYSTEM NO.	# BRANCH CIRCUITS PER UNIT	LOCATION	ELECTRICAL			DIMENSIONS LxWxH INCHES	MANUFACTURE & MODEL	OPTIONS/ACCESSORIES
				MCA	MOC	V./PH./HZ.			
BC-1	1	7	MEZZANINE	0.4	1	208/1/60	25"X15.7"X10"	MITSUBISHI CMB-P108NU-JA1	NOTE-1





NOTES:
1. PROVIDE WITH POWER DISCONNECT, CONDENSATE CATCH PAN AND CONDENSATE PUMP, ISOLATION VALVES UPSTREAM AND DOWNSTREAM OF BRANCH CONTROLLER BOX.

INDOOR VRF UNIT EQUIPMENT SCHEDULE										
EQUIPMENT NO.	SERVICE	NOMINAL COOLING CAPACITY (BTU/HR.)	NOMINAL HEATING CAPACITY (BTU/HR.)	CFM	REFRIGERANT PIPING DIAMETER		ELECTRICAL		MANUFACTURER & MODEL	OPTIONS/ACCESSORIES
					LIQUID	SUCTION	MCA (AMPS)	V./PH./HZ.		
FC-1	MAIN LOBBY	12000	13500	390	1/4	1/2	0.35	208/1/60	PLFY-P12NCMU-ER4	NOTE-1
FC-2	MEZZANINE LOBBY	8000	9000	350	1/4	1/2	0.29	208/1/60	PLFY-P08NCMU-ER4	NOTE-1

NOTES:
1. PROVIDE WITH POWER DISCONNECT, SIMPLE MA CONTROLLER, CONDENSATE PAN AND PUMP, ISOLATION VALVES ON CONNECTIONS TO UNIT. LINESET RECOMMENDED BY MANUFACTURER.

GRILLE-REGISTER-DIFFUSER SCHEDULE					
EQUIPMENT NO.	SIZE	MODEL	MANUFACTURER	FINISH	OPTIONS/ACCESSORIES
A	8"X24"	520	PRICE	FLAT BLACK	NOTE-1


NOTES:
1. SUPPLY GRILLE MOUNTED ON DUCT. PROVIDE WITH OBD AND MANUAL ADJUSTMENT. DIFFUSER TO BE SET AT 22.5 DEGREE DEFLECTION.

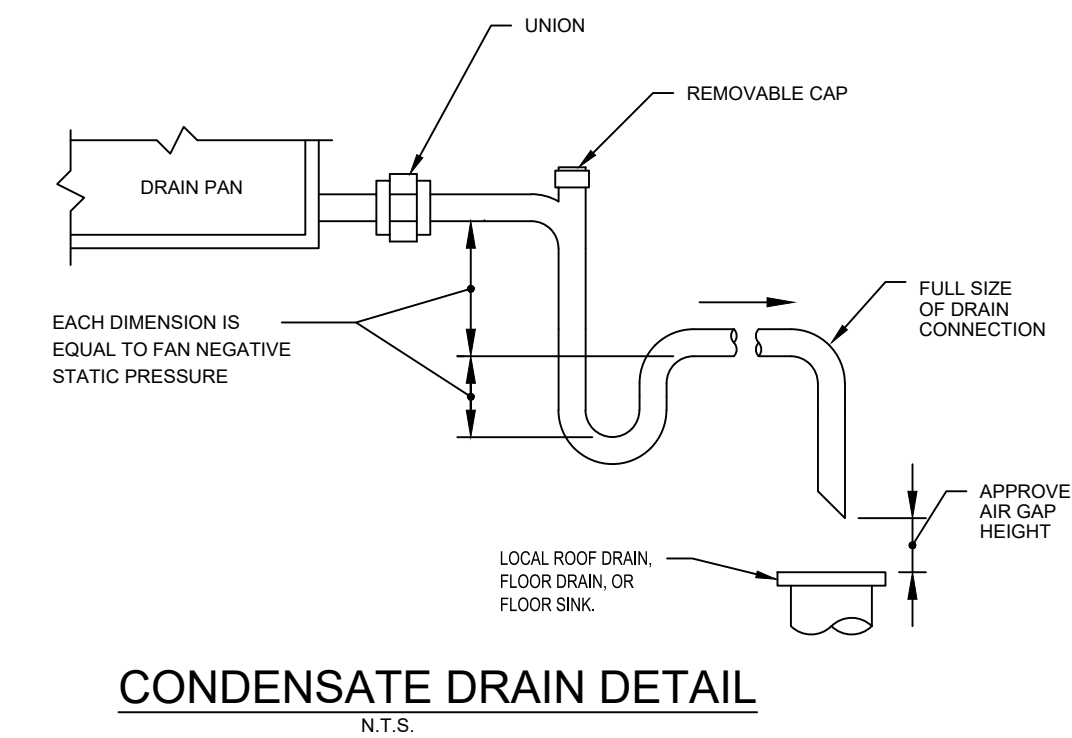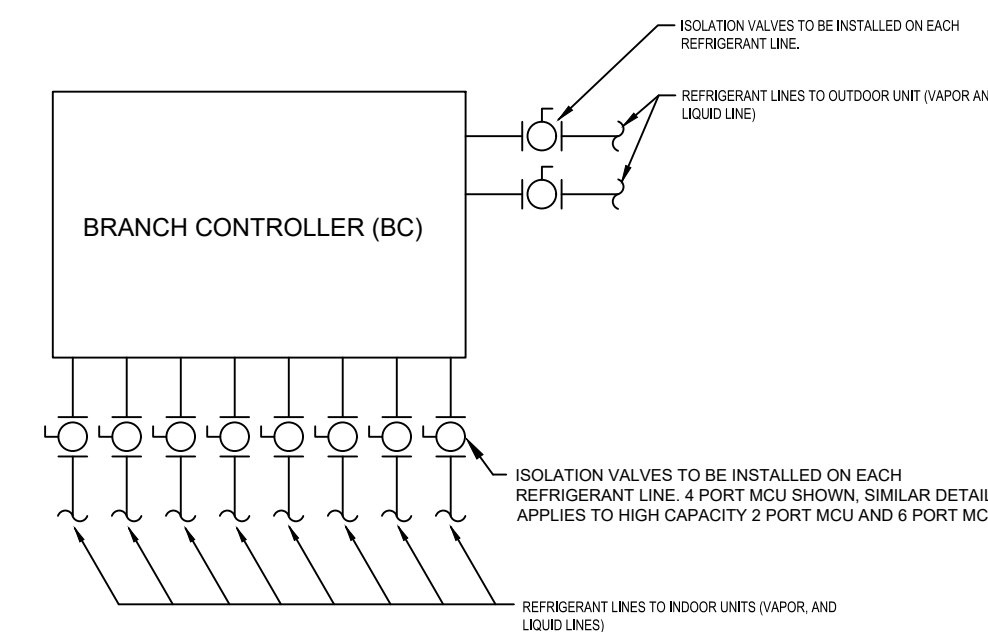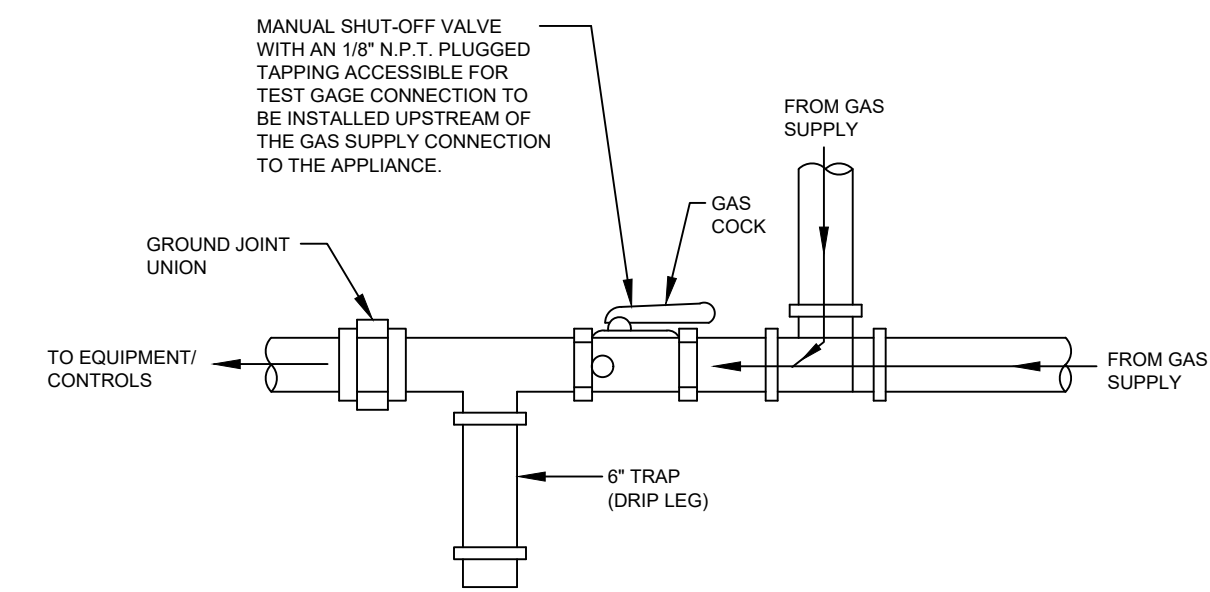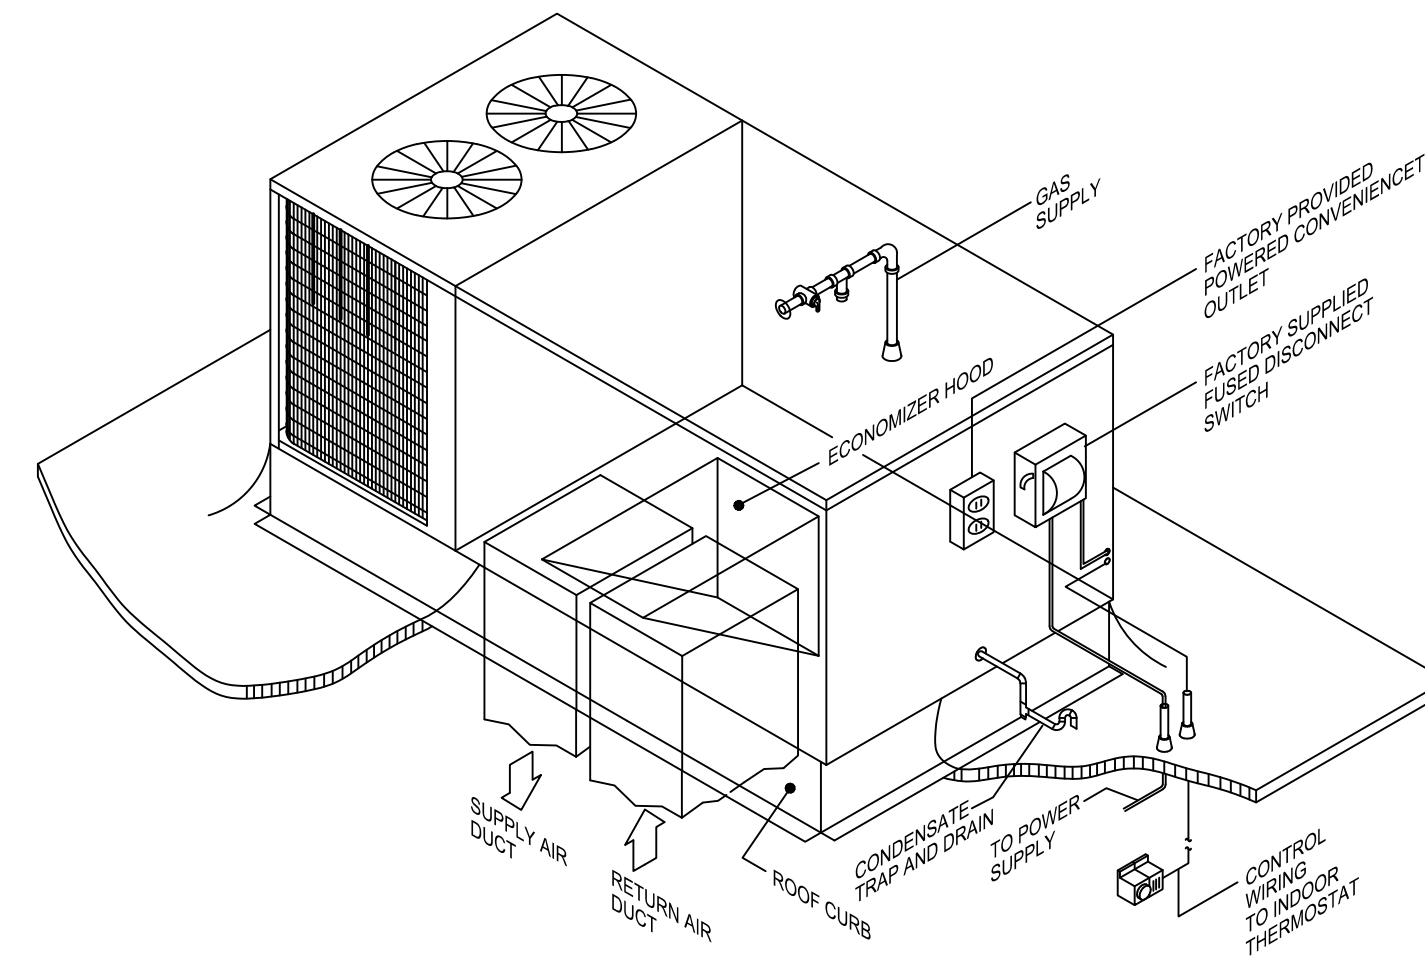

DO NOT REPRODUCE THESE DRAWINGS AND SPECIFICATIONS WITHOUT THE EXPRESSED WRITTEN PERMISSION OF THE DESIGNER. THE DRAWINGS AND SPECIFICATIONS ARE INSTRUMENTS OF THE SERVICE AND SHALL REMAIN THE PROPERTY OF THE DESIGNER. WHETHER THE PROJECT FOR WHICH THEY ARE MADE IS EXECUTED OR NOT. THESE DRAWINGS AND SPECIFICATIONS SHALL NOT BE USED BY ANYONE ON ANY OTHER PROJECTS FOR ADDITIONS TO THIS PROJECT BY OTHERS EXCEPT BY THE EXPRESSED WRITTEN PERMISSION OF THE DESIGNER.

101 W 11th Street #109-C
Durango, CO 81301
Phone: (970) 422-7676

386 Indian Road
Grand Junction, CO 81501
Phone: (970) 241-8709

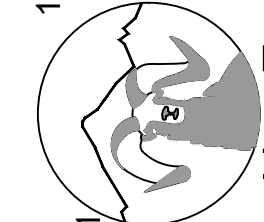

Bighorn Consulting Engineers, Inc.
Mechanical & Electrical Engineers

THE AVALON
LOBBY AND STAGE UPGRADES
645 MAIN STREET
GRAND JUNCTION, COLORADO

DATE: 04/16/2020
ISSUED FOR: FOR CONSTRUCTION

DATE: 4-16-2020
JOB NO: 20-039
DRAWN BY: BCE
CHECKED BY: BCE
SCALE: AS SHOWN
SHEET NUMBER:

DRAWING ABBREVIATIONS

Table listing drawing abbreviations such as AA, AB, AC, AD, etc., and their corresponding descriptions like AUTOMATIC AIR VENT, ACCESS DOOR, AIR CONDITIONING UNIT, etc.

COND CONDENSATE

Table listing condensation and expansion abbreviations such as CONN CONNECTION, CONTR CONTRACTOR, CP CONDENSATE PUMP, etc.

EXPAN EXPANSION

Table listing expansion abbreviations such as EXT EXTERNAL, F DEGREES FAHRENHEIT, F/D WITH FIRE/SMOKE DAMPER ACCESS DOOR, etc.

HT HEIGHT

Table listing height and heating abbreviations such as HTR HEATER, HV HEATING AND VENTILATING UNIT, HWC HOT WATER CONVERTER, etc.

OAT OUTSIDE AIR TEMPERATURE

Table listing outside air and other abbreviations such as OB OFF BOTTOM, OBD OPPOSED BLADE DAMPER, OC ON CENTER, etc.

SA SUPPLY AIR

Table listing supply air and other abbreviations such as SAD SUPPLY AIR DIFFUSER, SAR SUPPLY AIR REGISTER, SCG SMOKE CONTROL GRILLE, etc.

RESPONSIBLE DIVISION

UNLESS OTHERWISE INDICATED ALL HEATING, VENTILATING, AIR CONDITIONING, PLUMBING, AND OTHER MECHANICAL EQUIPMENT, MOTORS, AND CONTROLS SHALL BE FURNISHED, SET IN PLACE AND WIRED AS FOLLOWS:

Table with columns: ITEM, FURNISHED, SET, POWER WIRED, CONTROL WIRED. Lists items like EQUIPMENT COMBINATION, FUSED AND UNFUSED DISCONNECT SWITCHES, MANUAL-OPERATING AND MULTI-SPEED SWITCHES, etc.

- SUBSCRIPT FOOTNOTES: 1) UNDER DIVISION 23 FURNISHED FACTORY-WIRED AS PART OF EQUIPMENT OR IF FURNISHED WITH COMBINATION STARTERS. 2) IF ITEM IS FOR LINE VOLTAGE, SET IN PLACE AND CONNECT UNDER DIVISION 26...

DO NOT REPRODUCE THESE DRAWINGS AND SPECIFICATIONS WITHOUT THE EXPRESSED WRITTEN PERMISSION OF THE DESIGNER...

101 W 11th Street #109-C Durango, CO 81301 Phone: (970) 422-7676 Bighorn Consulting Engineers, Inc. Mechanical & Electrical Engineers

THE AVALON LOBBY AND STAGE UPGRADES 645 MAIN STREET GRAND JUNCTION, COLORADO

LIGHTING LEGEND NOTES: SYMBOLS SHOWN ARE STANDARD. VARIATION AND/OR COMBINATIONS MAY BE USED ON THE PLANS...

SWITCHES § SINGLE POLE SWITCH §2 TWO POLE SWITCH §3 THREE-WAY SWITCH §4 FOUR-WAY SWITCH §5 DIMMER SWITCH §3D 3 WAY DIMMER SWITCH - (4D INDICATES A 4WAY DIMMER) §DR DOOR ACTIVATED SWITCH §NA WALL MOUNTED DUAL TECHNOLOGY MANUAL ON / AUTO OFF VACUITY SENSOR SWITCH §LV LOW VOLTAGE LIGHT SWITCH §TO MANUAL MOTOR STARTER §P PILOT LIGHT SWITCH §OS MANUAL ON / AUTO OFF LIGHT SWITCH §MAD MANUAL ON / AUTO OFF DIMMING LIGHT SWITCH §K KEY OPERATED LIGHT SWITCH §T TIMER SWITCH §OS §S CEILING MOUNTED DUAL TECHNOLOGY OCCUPANCY SENSOR SWITCH §SC SCENE CONTROL STATION §MS UNIT LIGHTING MANAGEMENT CONTROL STATION.

LIGHT FIXTURES ALL FIXTURES: THE UPPER CASE LETTER INDICATES FIXTURE TYPE RE: THE LUMINAIRE SCHEDULE FOR SPECIFICATIONS, THE LOWER CASE LETTER INDICATES WHICH SWITCH CONTROLS THE LIGHT. ACTUAL FIXTURE ON PLANS MAY VARY FROM THE SYMBOL SHOWN HERE

ELECTRICAL EQUIPMENT LEGEND BRANCH CIRCUIT PANELBOARD TELEPHONE TERMINAL BOARD ELECTRIC MOTOR FUSED SAFETY SWITCH / DISCONNECT COMBINATION MOTOR STARTER CONTACTOR CIRCUITRY HOMERUN: PANEL LA - CIR #7 CONDUIT OR WIRE CONCEALED IN WALL/CLG CONDUIT OR WIRE UNDERFLOOR/UNDERGND.

MAIN DISTRIBUTION GEAR CIRCUIT BREAKER IN A PANEL BOARD PAD MOUNTED UTILITY TRANSFORMER FUSED DISCONNECT 100A = AMP RATING 2P = NUMBER OF POLES ELECTRICAL METER SHOWN IN PLAN VIEW ELECTRICAL POWER PANEL WITH MAIN LUG OR MAIN BREAKER

ELECTRICAL DEVICE LEGEND CEILING JUNCTION BOX - SURFACE/FLUSH WALL JUNCTION BOX - SURFACE/FLUSH DUPLEX RECEPTACLE FLOOR MOUNTED RECEPTACLE SPLIT WIRED DUPLEX RECEPTACLE CEILING MOUNTED DUPLEX RECEPTACLE FOURPLEX RECEPTACLE FLOOR MOUNTED FOURPLEX RECEPTACLE APPLIANCE RECEPTACLE - 3 WIRE GFCI GROUND FAULT CIRCUIT INTERRUPTER RECEPTACLE WITH USB CHARGING CAPABILITIES RECEPTACLE MOUNTED ABOVE COUNTER RECEPTACLE MOUNTED IN CASEWORK ELECTRIC HAND DRYER THERMOSTAT OPEN/CLOSE/STOP PUSH BUTTON

FIRE ALARM EQUIPMENT LEGEND F FIRE ALARM PULL STATION FIRE ALARM HORN FIRE ALARM STROBE FIRE ALARM HORN/STROBE CEILING MOUNTED SPEAKER DUCT DETECTOR REMOTE LAMP SMOKE DETECTOR - STANDARD 135° STANDARD HEAT DETECTOR PIR DETECTOR FLOW SWITCH TAMPER SWITCH

COMMUNICATION LEGEND CLOCK ONLY CLOCK / PA SPEAKER WALL MOUNTED ROUND CEILING MOUNTED SPEAKER SQUARE SPEAKER INTERCOM PUSH TO CALL SWITCH WIRELESS ACCESS POINT ABOVE THE CEILING ABOVE THE CEILING PROJECTOR CONNECTION WALL MOUNTED HDMI PLAIN DATA OUTLET PLAIN DATA OUTLET WITH MOUNTING HEIGHT

SECURITY SYSTEM LEGEND SECURITY CAMERA ADA DOOR OPERATOR PUSH BUTTON


GENERAL NOTES: SYMBOLS SHOWN ARE STANDARD. VARIATION AND/OR COMBINATION MAY BE USED ON THE PLANS. THIS LIST SHOWS STANDARD SYMBOLS AND ALL MAY NOT APPEAR ON THE PROJECT DRAWINGS; HOWEVER, WHEREVER THE SYMBOL ON THE PROJECT DRAWINGS OCCUR, THE ITEM SHALL BE PROVIDED AND INSTALLED. VARIATION AND/OR COMBINATION MAY BE USED ON THE PLANS SUCH AS A LOWER CASE LETTER NEXT TO A SWITCH INDICATES THE SWITCH DESIGNATION. A NUMBER NEXT TO A DEVICE INDICATES A CIRCUIT NUMBER.

ABBREVIATIONS LEGEND DRAWING KEYED NOTES ROOM ROOM DESIGNATION NL NIGHT/SECURITY LIGHT - DO NOT SWITCH WP WEATHERPROOF A.F.F. ABOVE FINISHED FLOOR AC. ABOVE COUNTER GFCI GROUND FAULT CIRCUIT INTERRUPTER CW COORDINATE MOUNTING HEIGHT W/ CASEWORK EM EMERGENCY FUNCTION 44" MOUNTING HEIGHT - A.F.F. OR A.F.G. TO C.L. HIGH GFCI GROUND FAULT CIRCUIT INTERRUPTER RECEPTACLE WITH A WEATHER PROOF COVER WP GFCI GROUND FAULT CIRCUIT INTERRUPTER RECEPTACLE MOUNTED AT 44" ABOVE FINISHED FLOOR


Table with columns: DATE, ISSUED FOR. Row 1: 04/16/2020 FOR CONSTRUCTION

Table with columns: DATE, JOB NO., DRAWN BY, CHECKED BY, SCALE, SHEET NUMBER. Row 1: 4-16-2020, 20-039, BCE, BCE, AS SHOWN

E0-1

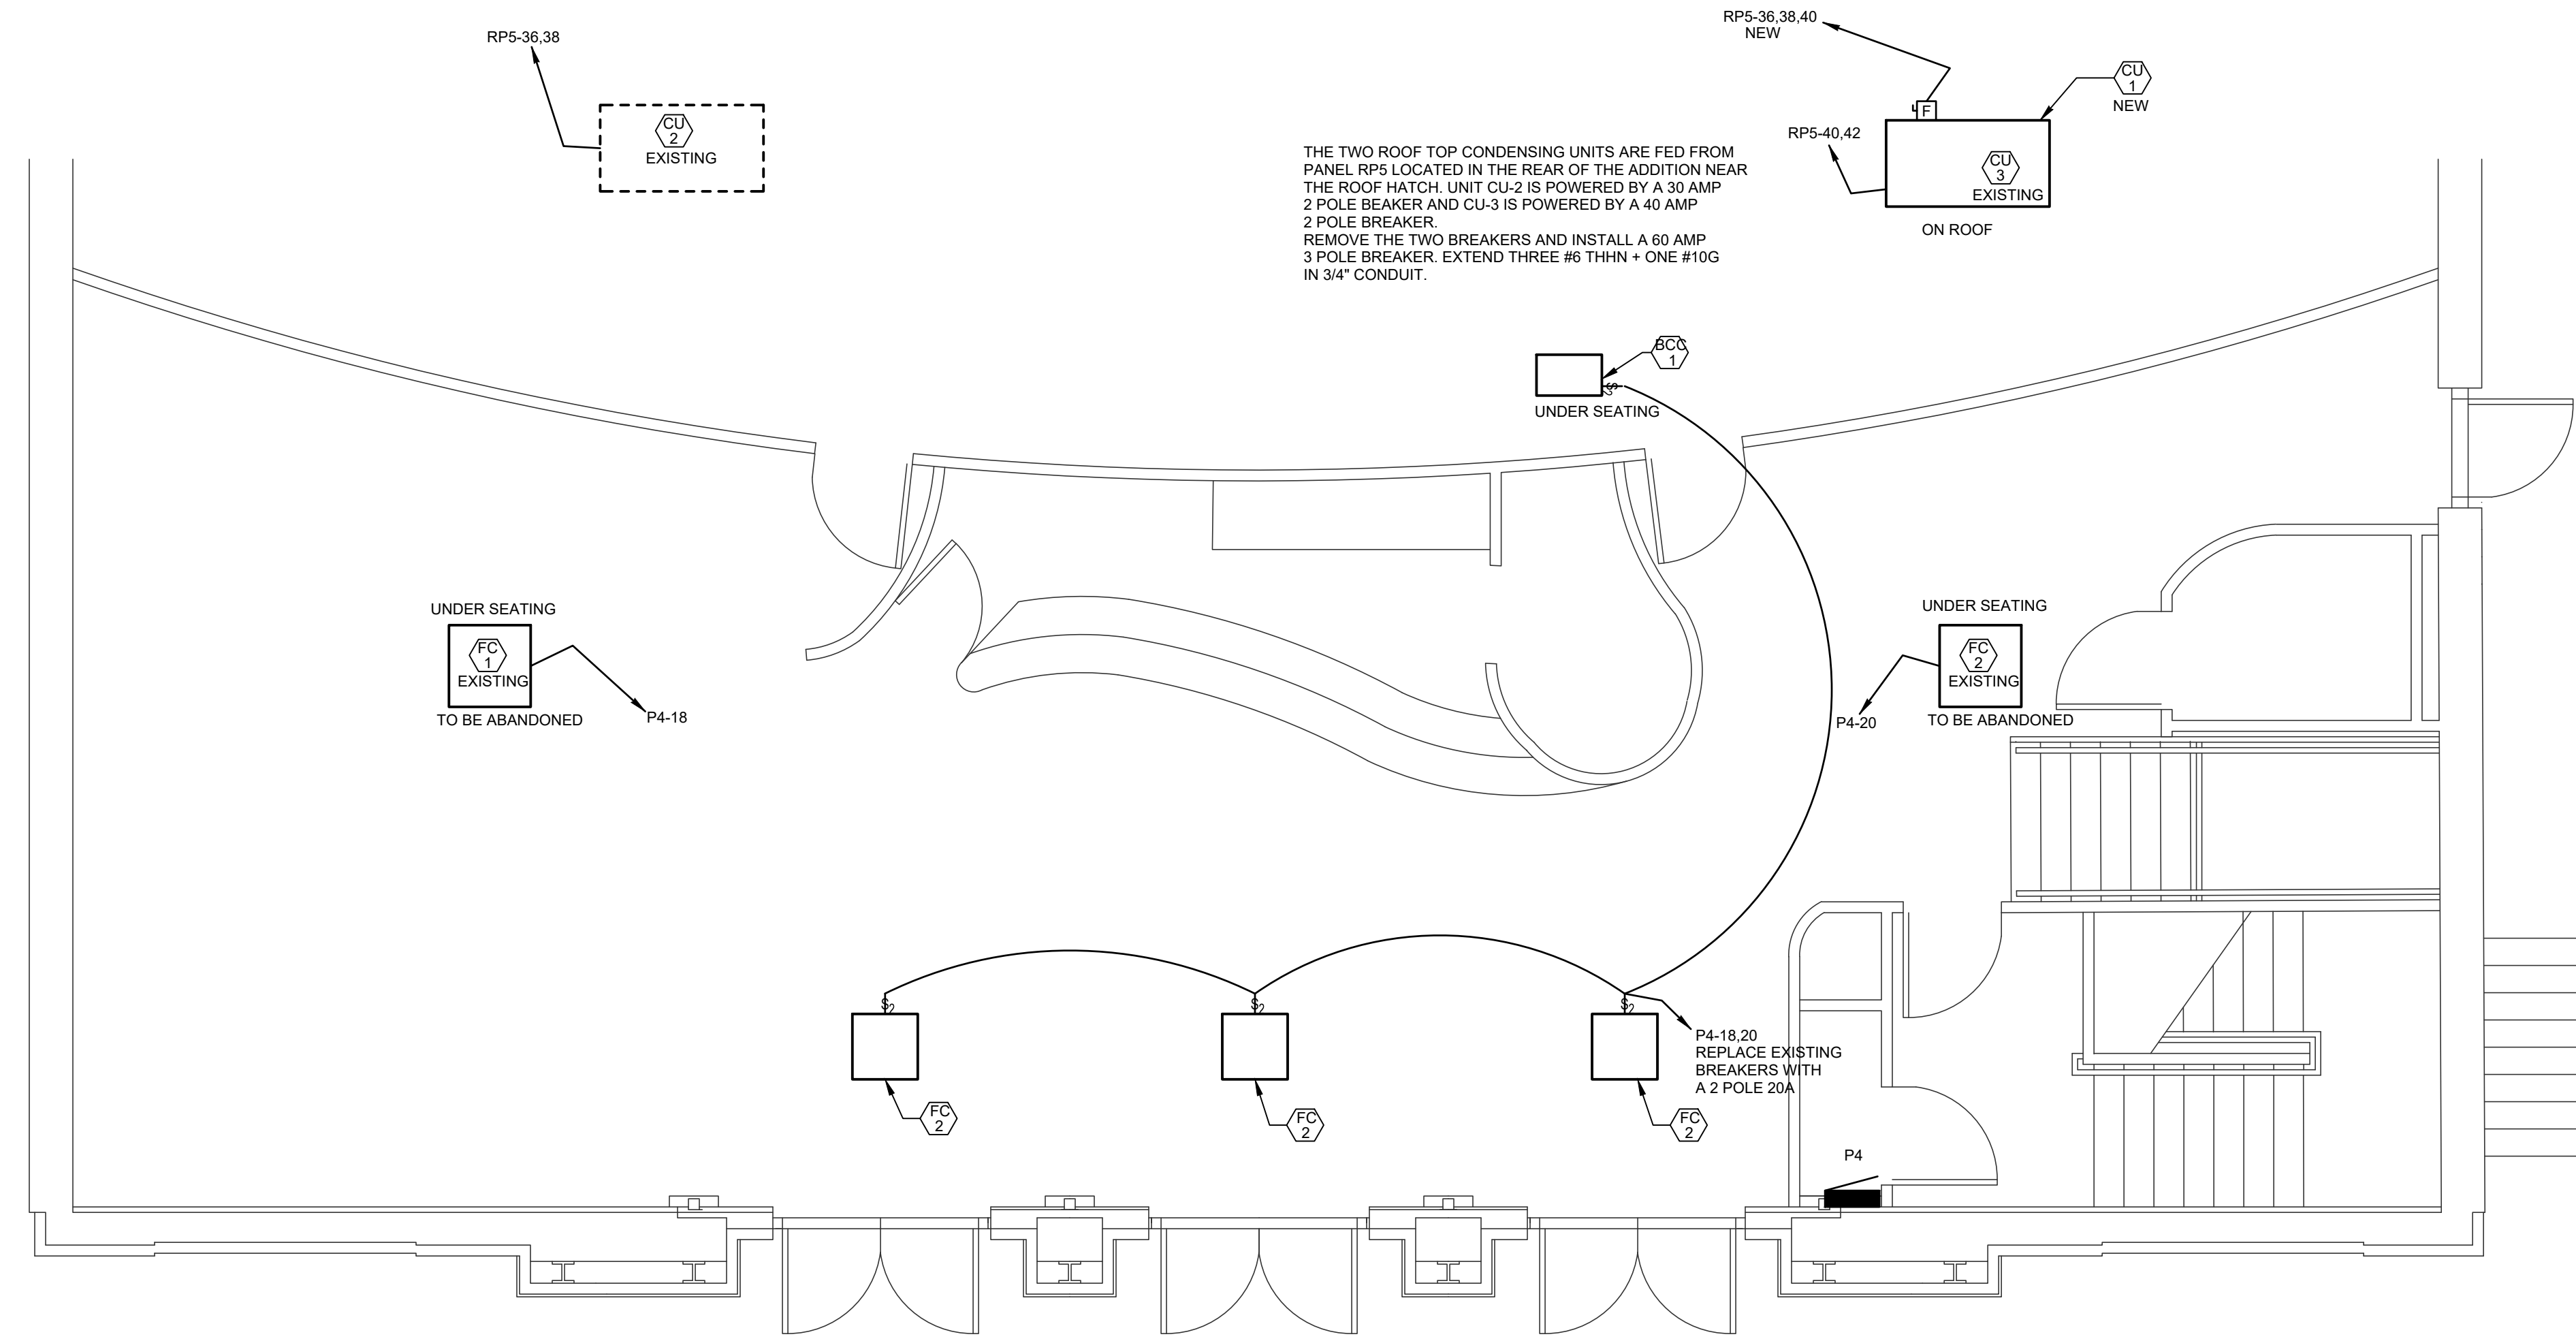

ELECTRICAL - MAIN LOBBY FLOOR PLAN
 SCALE: 1/4"=1'-0"
 NORTH

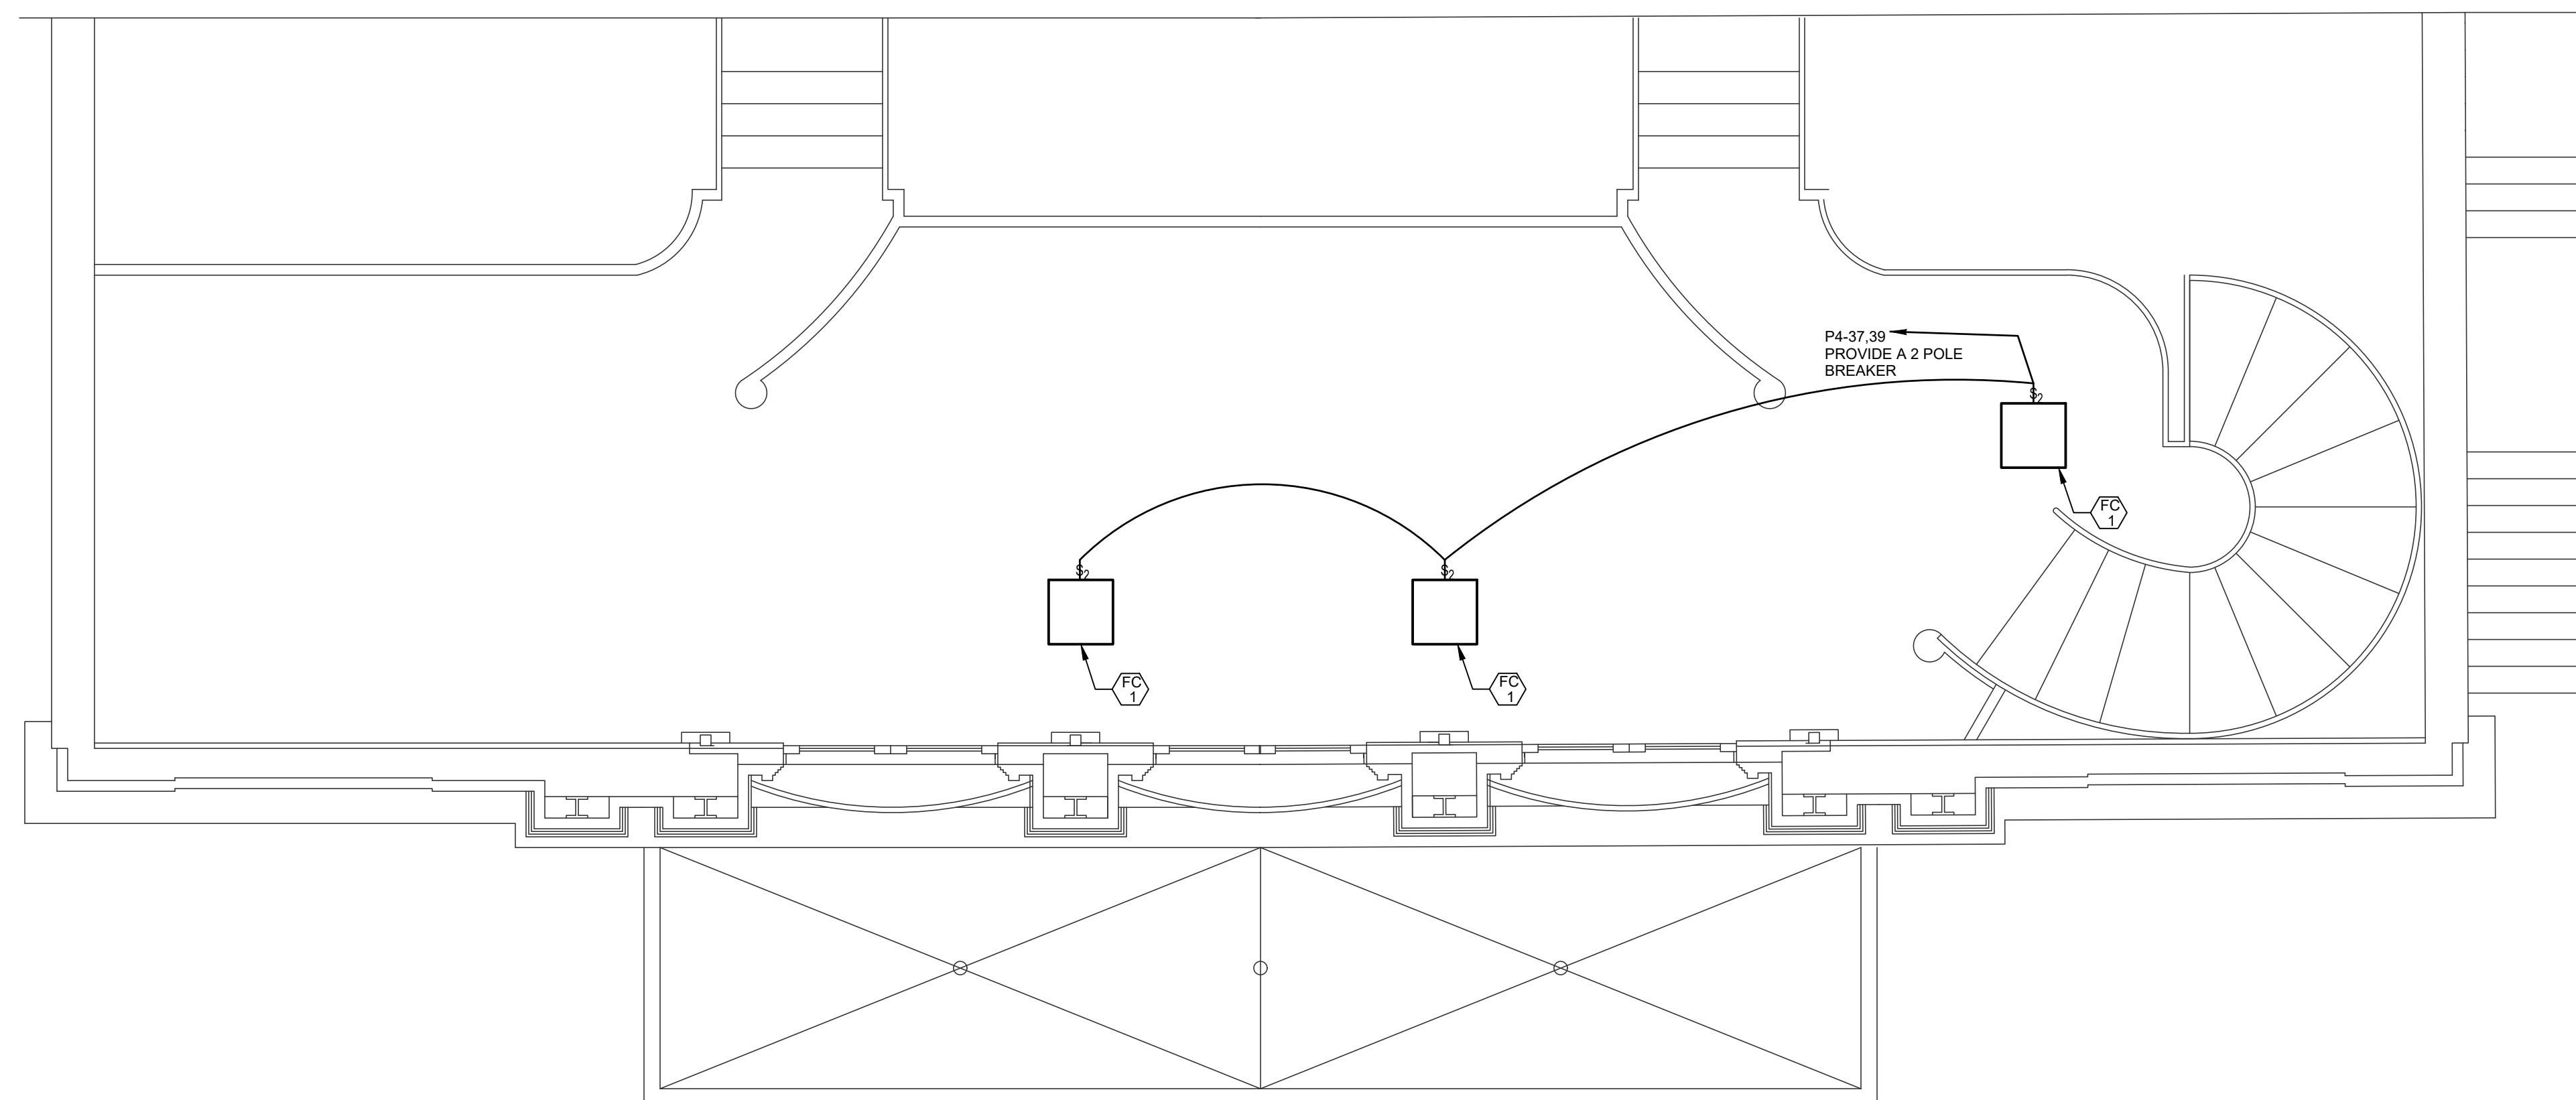

ELECTRICAL - MEZZANINE LOBBY FLOOR PLAN
 SCALE: 1/4"=1'-0"
 NORTH

DO NOT REPRODUCE THESE DRAWINGS AND SPECIFICATIONS WITHOUT THE EXPRESSED WRITTEN PERMISSION OF THE DESIGNER. THE DRAWINGS AND SPECIFICATIONS ARE INSTRUMENTS OF THE SERVICE AND SHALL REMAIN THE PROPERTY OF THE DESIGNER. WHETHER THE PROJECT FOR WHICH THEY ARE MADE IS EXECUTED OR NOT. THESE DRAWINGS AND SPECIFICATIONS SHALL NOT BE USED BY ANYONE ON ANY OTHER PROJECTS FOR ADDITIONS TO THIS PROJECT BY OTHERS EXCEPT BY THE EXPRESSED WRITTEN PERMISSION OF THE DESIGNER.

101 W 11th Street #109-C
 Durango, CO 81301
 Phone: (970) 422-7676

386 Indian Road
 Grand Junction, CO 81501
 Phone: (970) 241-8709

Bighorn Consulting Engineers, Inc.
 Mechanical & Electrical Engineers


THE AVALON
LOBBY AND STAGE UPGRADES
 645 MAIN STREET
 GRAND JUNCTION, COLORADO

DATE:	ISSUED FOR:
04/16/2020	FOR CONSTRUCTION

DATE:	4-16-2020
JOB NO:	20-039
DRAWN BY:	BCE
CHECKED BY:	BCE
SCALE:	AS SHOWN
SHEET NUMBER:	E2-1

DO NOT REPRODUCE THESE DRAWINGS AND SPECIFICATIONS WITHOUT THE EXPRESSED WRITTEN PERMISSION OF THE DESIGNER. THE DRAWINGS AND SPECIFICATIONS ARE INSTRUMENTS OF THE SERVICE AND SHALL REMAIN THE PROPERTY OF THE DESIGNER. WHETHER THE PROJECT FOR WHICH THEY ARE MADE IS EXECUTED OR NOT, THESE DRAWINGS AND SPECIFICATIONS SHALL NOT BE USED BY ANYONE ON ANY OTHER PROJECTS FOR ADDITIONS TO THIS PROJECT BY OTHERS EXCEPT BY THE EXPRESSED WRITTEN PERMISSION OF THE DESIGNER.

101 W 11th Street #109-C
Durango, CO 81301
Phone: (970) 422-7676

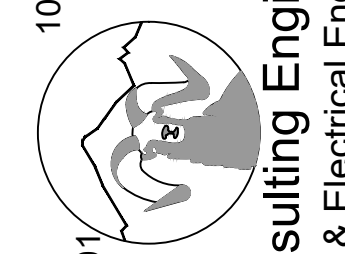


Bighorn Consulting Engineers, Inc.
Mechanical & Electrical Engineers

THE AVALON
LOBBY AND STAGE UPGRADES
645 MAIN STREET
GRAND JUNCTION, COLORADO

DATE: 04/16/2020
ISSUED FOR: FOR CONSTRUCTION

DATE: 4-16-2020
JOB NO: 20-039
DRAWN BY: BCE
CHECKED BY: BCE
SCALE: AS SHOWN
SHEET NUMBER:
E2-3

MECHANICAL EQUIPMENT SCHEDULE												
COMB: COMBINATION MOTOR STARTER		NR: NONE REQUIRED			CONT: CONTRACTOR							
MAG: MAGNETIC MOTOR STARTER		PI: PLUG-IN UNIT			MAN: MANUAL MOTOR STARTER							
					W/U: SUPPLIED WITH UNIT:							
UNIT NO	FUNCTION (NOTES)	LOAD	VOLTS	Ø	FULL LOAD AMPS	BRANCH CIRCUIT CONDUIT SIZE	NO. WIRES	WIRE SIZE	GRND WIRE SIZE	BRKR SIZE	START	DISC FUSE
BC	BRANCH SELECTOR		208	1	0.4A	1/2"	2	12	12	20A	NR	1/2
CU	CONDENSING UNIT		208	3	38A	1"	3	6	10	60A	NR	60
FC	FAN COIL UNIT		208	1	0.35A	1/2"	2	12	12	20A	NR	1/2
FC	FAN COIL UNIT		208	1	0.29A	1/2"	2	12	12	20A	NR	1/2
RTU	ROOF TOP UNIT		208	3	61.0A	1.25"	3	4	6	80A	NR	100
												80

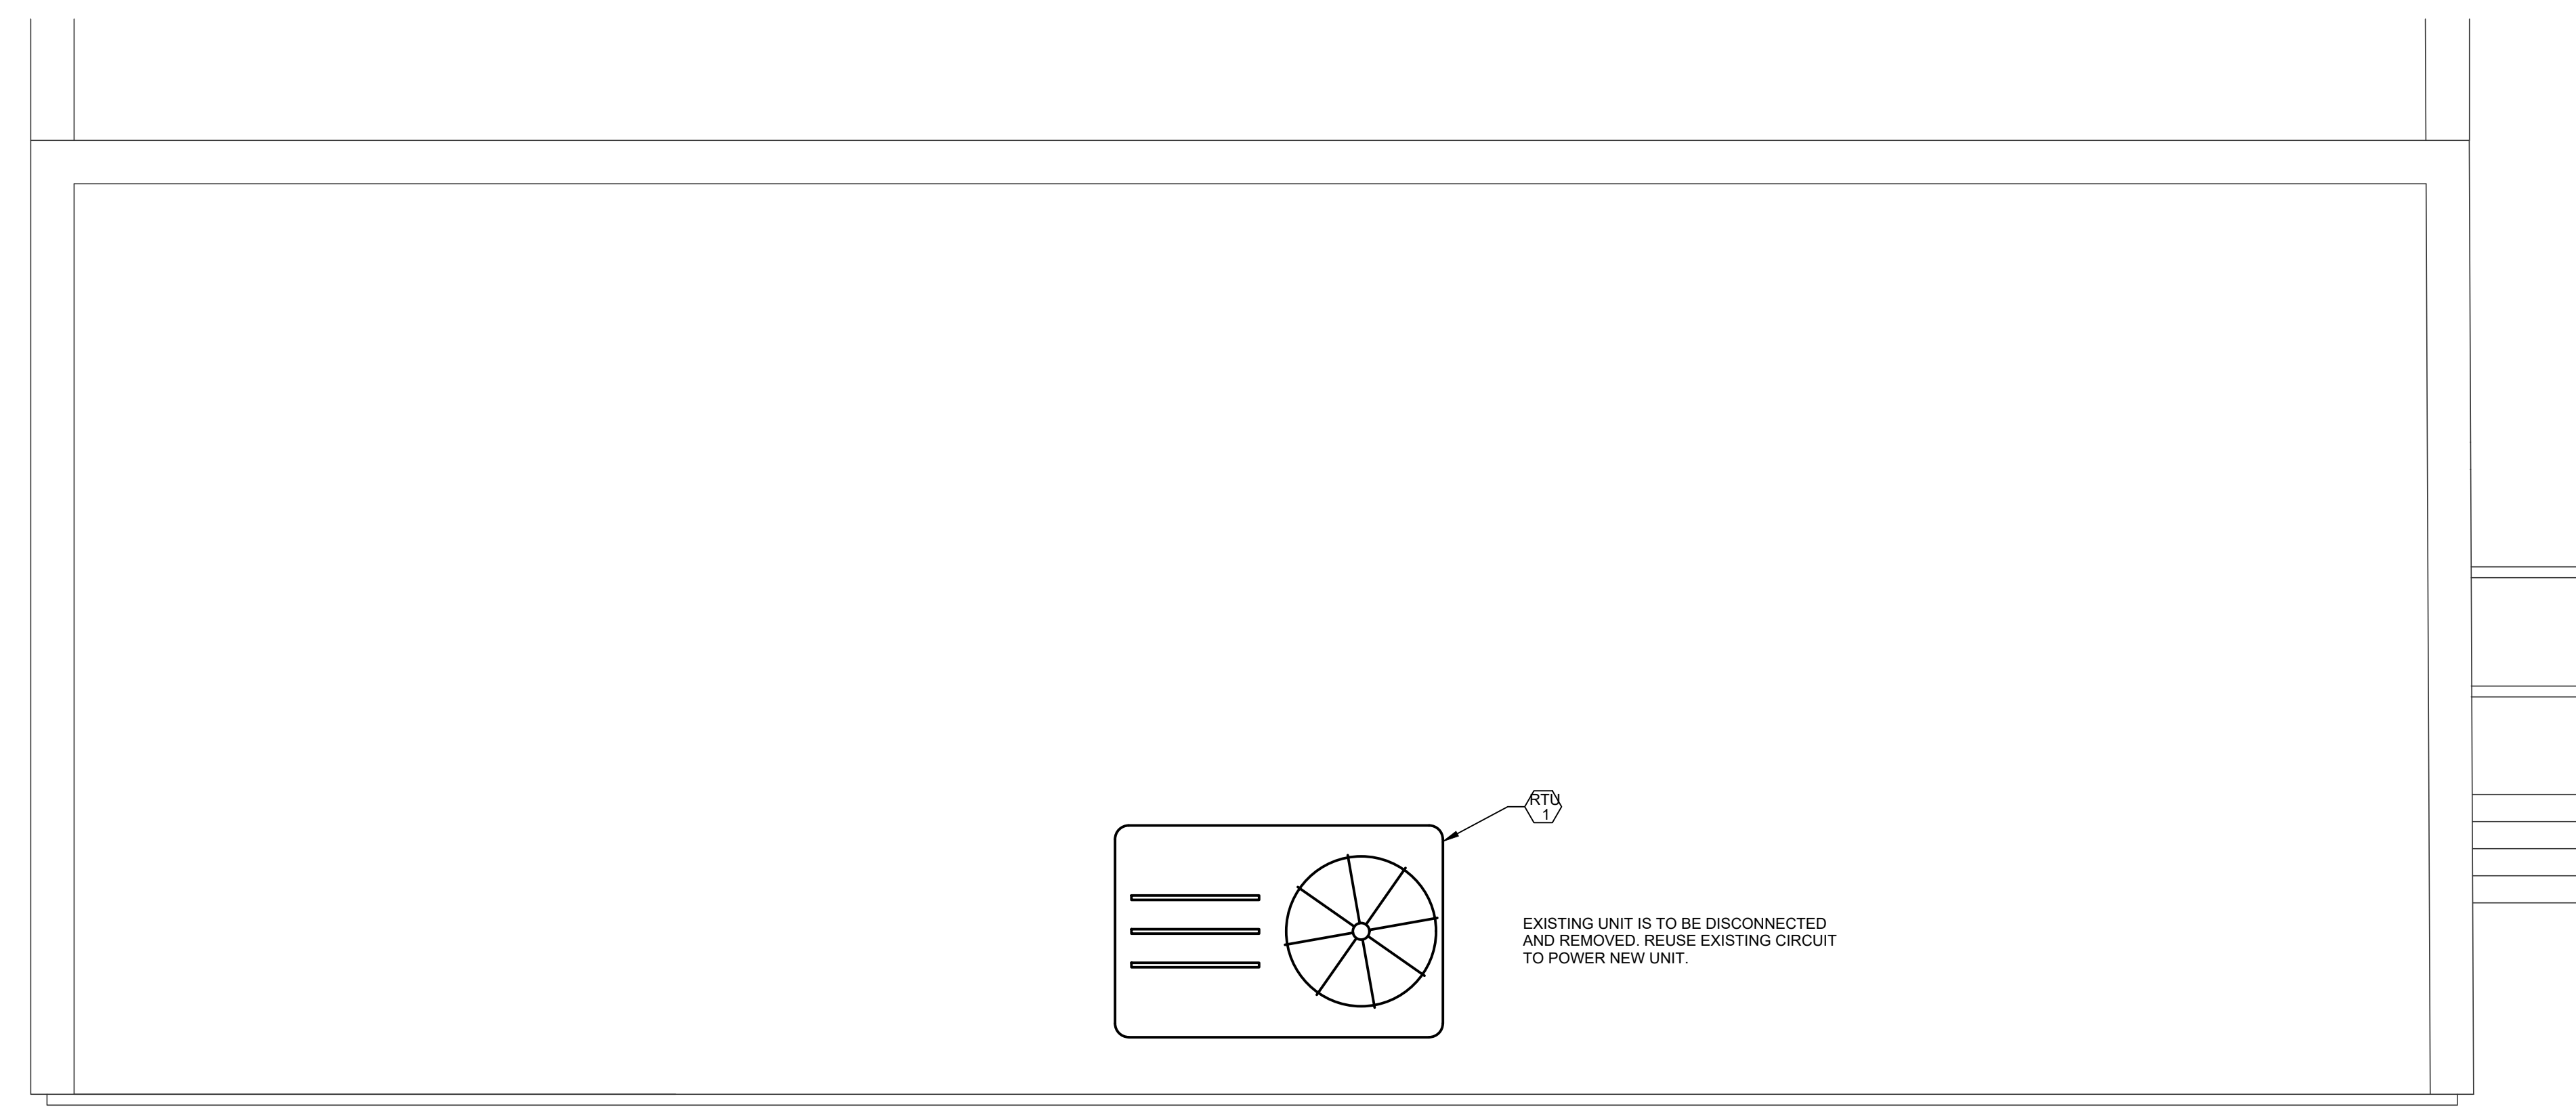

ELECTRICAL - ROOF PLAN
SCALE: 1/4"=1'-0"
NORTH