


LIGHTING FIXTURE SCHEDULE					
TYPE	MANUFACTURER CATALOG NO.	MANUFACTURER CATALOG NO.	VOLTAGE MOUNTING # OF LAMPS	BALLAST LAMP TYPE LAMP CAT. #	DESCRIPTION
A	METALUX 2G440A125LES	LITHONIA 2GT440A12.125ES	120 RECESSED T-BAR 4	UNIVERSAL SLH FLUORESCENT F40SP35RSWM	24"X48"X4" STATIC WHITE ENAMEL STEEL TROFFER WITH .125" ACRYLIC PRISMATIC LENS IN FLUSH STEEL DOOR
X	HALO SURE-LITES PCX-5000-G	LITHONIA MSW1GEL	120 SURFACE WALL 2+2	NONE REQUIRED INCANDESCENT WITH UNIT	11" SQ X 2" DEEP SINGLE STENCIL FACE BATTERY PACK EXIT LIGHT - OFF WHITE NORYL HOUSING AND STENCIL

PANEL SCHEDULE: LP1A						
VOLTAGE: 120/208 PHASE: 3 WIRES: 4 MOUNTING: SURFACE						
MAIN BREAKER: 70 AMP MAIN LUGS: BUS: 125 AMP						
CONNECTED LOAD: 7,520VA @A: 2,540VA @B: 2,580VA @C: 2,400VA DEMAND LOAD: 6,320VA						
DESCRIPTION	A	P	C	P	C	A
	M	P	N	H	K	M
	S	S	O	A	T	S
GAME ROOM LIGHTING	20	1	1	A	2	1
GAME ROOM RADIANT HEAT	20	1	3	B	4	1
GAME ROOM EVAPORATIVE COOLER	20	1	5	C	6	1
SPACE	20	1	7	A	8	1
SPACE	20	1	9	B	10	1
SPACE	20	1	11	C	12	1

PANEL SCHEDULE: LP1 (EXISTING)						
VOLTAGE: 120/208 PHASE: 3 WIRES: 4 MOUNTING: SURFACE						
MAIN BREAKER: MAIN LUGS: 225 AMP BUS: 225 AMP						
CONNECTED LOAD: 63,540 @A: 18,520 @B: 22,550 @C: 22,470 DEMAND LOAD:						
DESCRIPTION	A	P	C	P	C	A
	M	P	N	H	K	M
	S	S	O	A	T	S
LIGHTS/MULTI-PURPOSE	15	1	1	A	2	1
LIGHTS/MULTI-PURPOSE	15	1	3	B	4	2
LIGHTS/LOUNGE	20	1	5	C	6	1
LIGHTS/LOUNGE	20	1	7	A	8	1
LIGHTS/KITCHEN & WOMEN	20	1	9	B	10	1
LIGHTS/MECH. & MEETING	20	1	11	C	12	1
LIGHTS/HALL, MEN & OFFICE	20	1	13	A	14	1
LIGHTS/EXTERIOR	20	1	15	B	16	1
LIGHTS/EXTERIOR	20	1	17	C	18	1
LIGHTS/EXTERIOR	20	1	19	A	20	1
RECEPT'S/KITCHEN	20	1	21	B	22	1
RECEPT'S/KITCHEN	20	1	23	C	24	1
RECEPT'S/KITCHEN	20	1	25	A	26	1
DISPOSAL & HOOD	15	1	27	B	28	1
SPARE	20	1	29	C	30	1
				31	A	32
AC1				30	3	33
					35	C
					37	A
AC3				30	3	39
					41	C

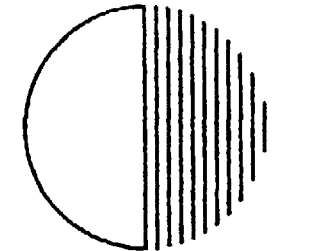


DILLON-HUNT P.C.
ARCHITECTURE AND FACILITY MANAGEMENT

804 GRAND AVENUE
GRAND JUNCTION, CO. 81501
(303) 245-7383
(303) 245-7437 (FAX)

PROJECT PHASE
 APPROVED BY:

PROJECT NO: 9106
DATE ISSUED: 02-13-92
DRAWN BY: WKG
SCALE: 1/8"=1'-0"
SHEET SIZE: 36x24


OLDER AMERICIAN CNTR.
GAME ROOM ADDITION
550 OURAY AVENUE

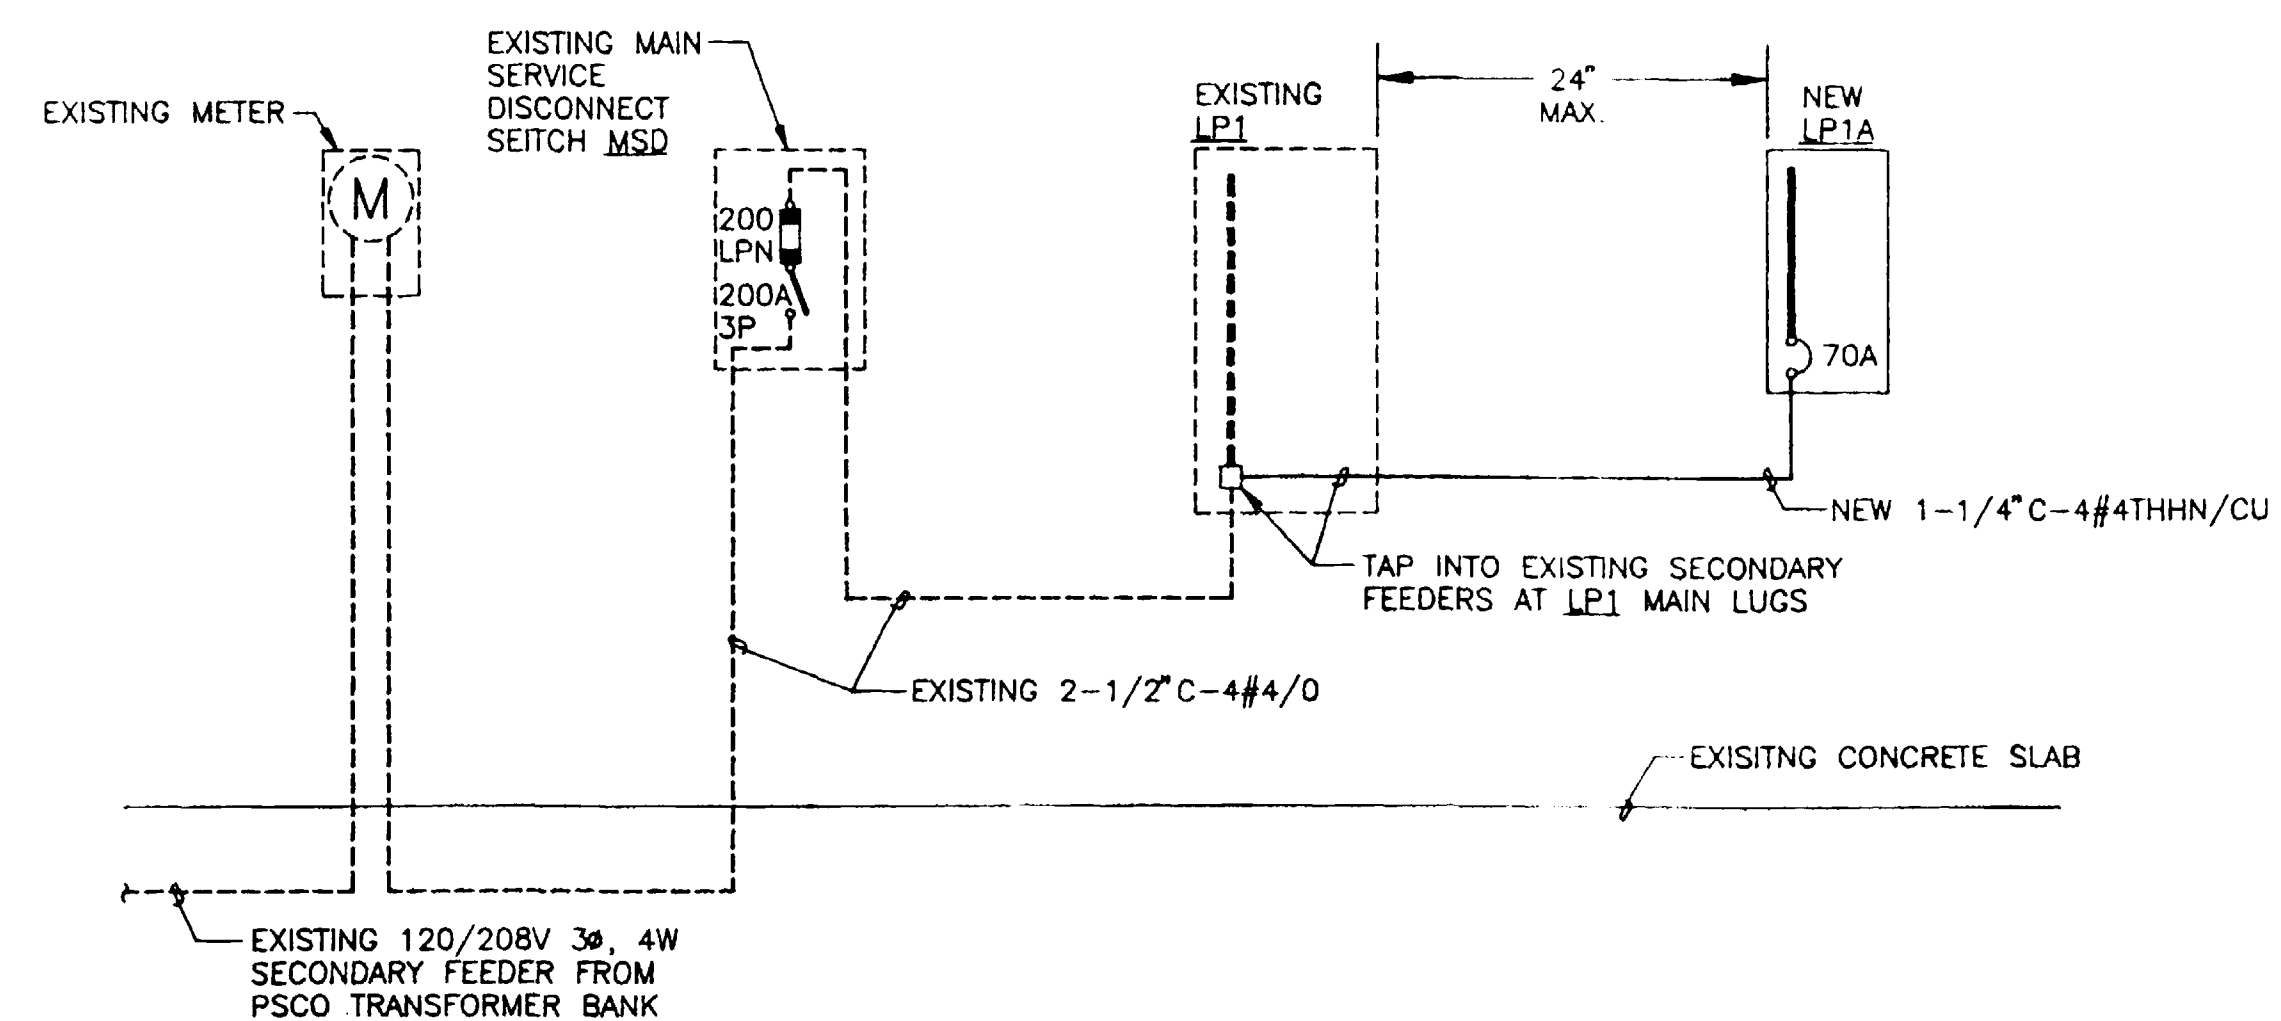

POWER DISTRIBUTION ONE-LINE DIAGRAM

NOT DRAWN TO SCALE

SHEET NO.
E2
OF 2

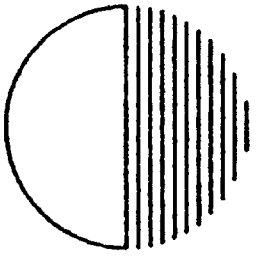

DILLON-HUNT P.C.

ARCHITECTURE AND FACILITY MANAGEMENT

804 GRAND AVENUE
GRAND JUNCTION,
CO. 81501
(303) 245-7383
(303) 245-7437 (FAX)

PROJECT PHASE
APPROVED BY:

PROJECT NO. 9106
DATE ISSUED: 02-06-92
TIME ISSUED: 13:08
DRAWN BY: WKG
SCALE: AS NOTED
SHEET SIZE: 36x24

OLDER AMERICAN CENTER
GAME ROOM ADDITION
550 OURAY AVENUE



SHEET NO.

E1

OF 2

FLAG NOTES:



- 1 FURNISH AND INSTALL BODINE B50 EMERGENCY BATTERY BALLAST.
- 2 INSTALL 150 WATT RECESSED OPEN DOWNLIGHT CAN REMOVED FROM EXISTING WEST WINDOW SOFFIT.
- 3 INSTALL TELEPHONE OUTLET WALL BOX WITH 3/4" CONDUIT EXTENDING UP INSIDE WALL TO ABOVE CEILING. HOMERUN 4PR. #22AWG TELEPHONE CABLE, ABOVE CEILING, FROM OUTLET TO TSN1 LOCATION.
- 4 INSTALL CABLE TELEVISION OUTLET WALL BOX WITH 3/4" CONDUIT EXTENDING UP INSIDE WALL TO ABOVE CEILING. HOMERUN 75 OHM COXIAL CABLE, ABOVE CEILING TO TERMINAL CONNECTOR.
- 5 FURNISH AND INSTALL 120V, 750W, 24"X48" ELECTRICAL HEAT RADIANT GRID CEILING PANEL WITH SILK SCREENED DESIGN MATCHING ACOUSTICAL CEILING TILE FISSURING. UNIT SHALL BE AZTEC INTERNATIONAL CATALOG NUMBER ATH-86-4.
- 6 FURNISH AND INSTALL 120V, 16A HEATING THERMOSTAT WITH POSITIVE OFF SUB-BASE. UNIT SHALL BE HONEYWELL CATALOG NUMBER T6051A1016/Q651C1007 OR EQUIVALENT. SURFACE MOUNT UNIT AT 48" A.F.F. USING WIREMOLD NUMBER 2347 NONMETALLIC DEVICE BOX AND 800B&C RACEWAY EXISTING WALL TO CONDUIT CONNECTOR ABOVE CEILING.
- 7 TWO SPEED EVAPORATIVE COOLER SWITCH FURNISHED BY MECHANICAL CONTRACTOR. PROVIDE WIREMOLD NUMBER 2348 SURFACE NONMETALLIC DEVICE BOX AT 48" A.F.F. WITH 800B&C RACEWAY EXTENDING UP WALL TO CONDUIT CONNECTION ABOVE CEILING. INSTALL AND CONNECT EVAPORATIVE COOLER CONTROL SWITCH.
- 8 SURFACE RACEWAY SHALL BE WIREMOLD NUMBER 800B&C. DUPLEX RECEPTACLES SHALL BE AS SPECIFIED MOUNTED, HORIZONTALLY IN NONMETALLIC WIREMOLD NUMBER 2347 DEVICE BOX.

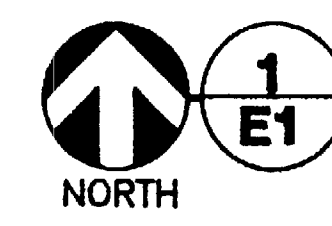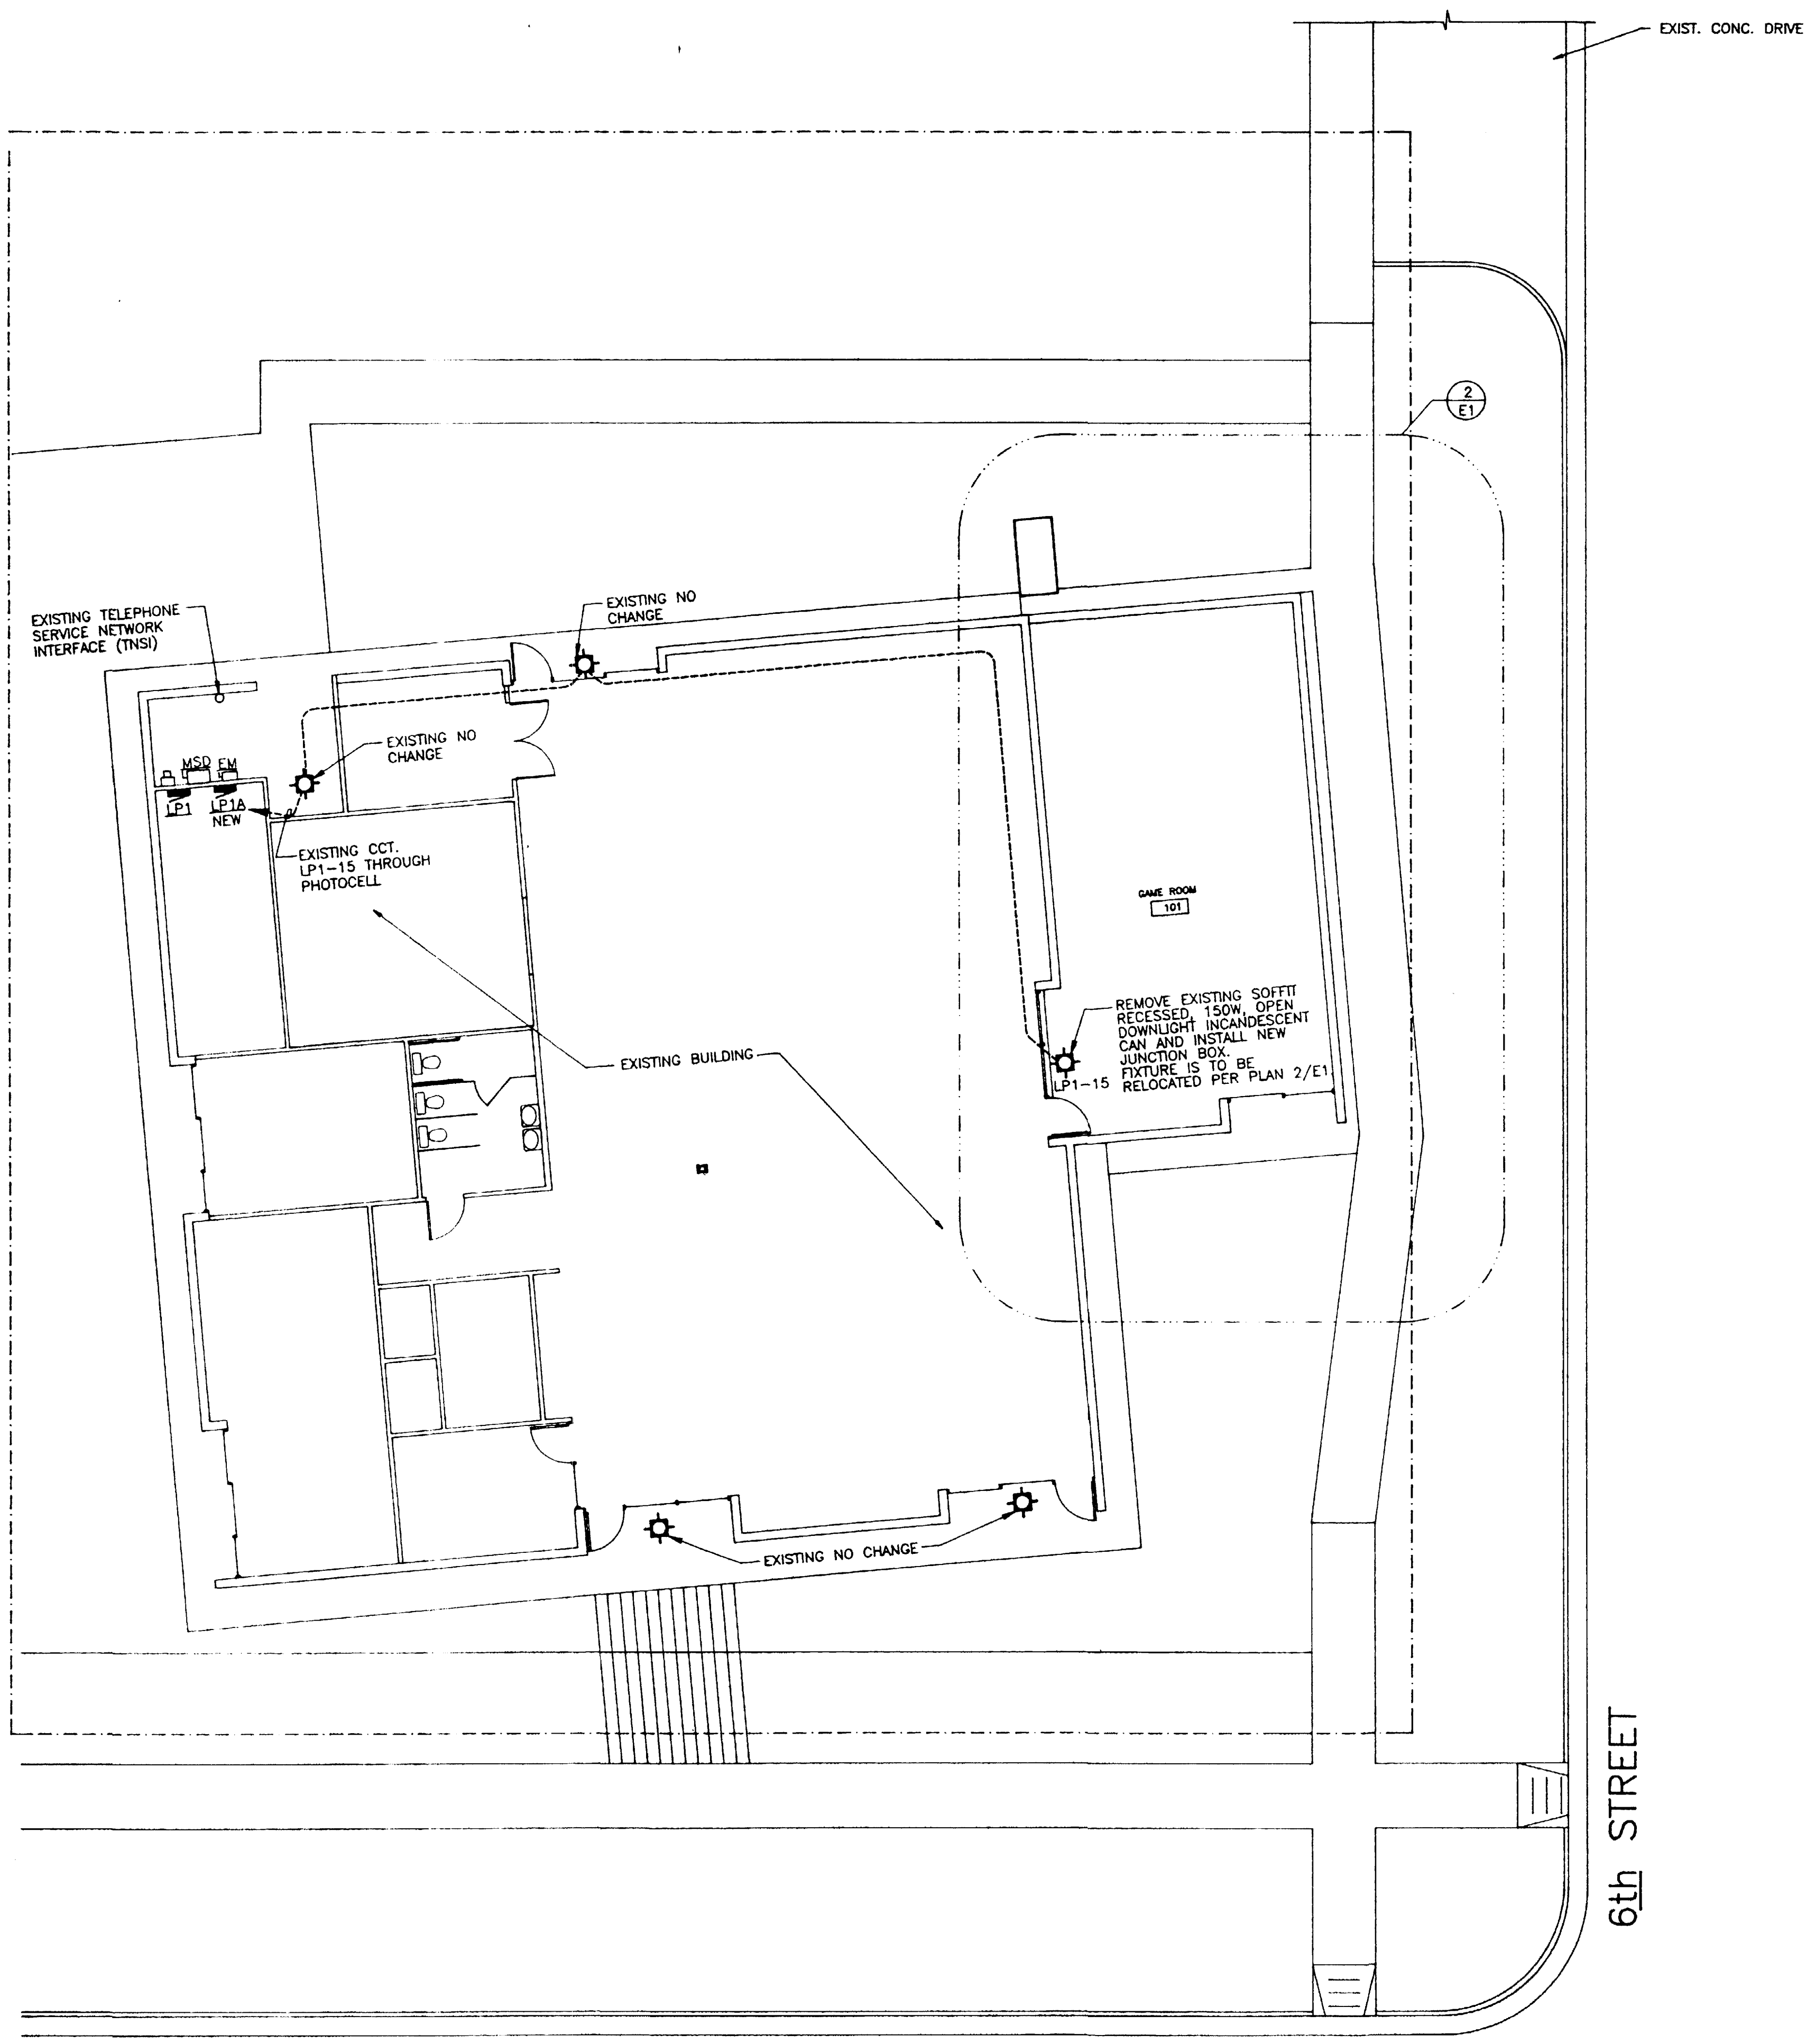

1 ELECTRICAL FLOOR PLAN
1/8"=1'-0"

OURAY AVENUE

6th STREET

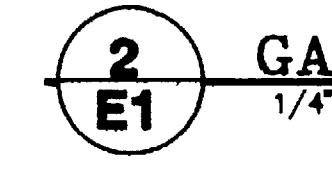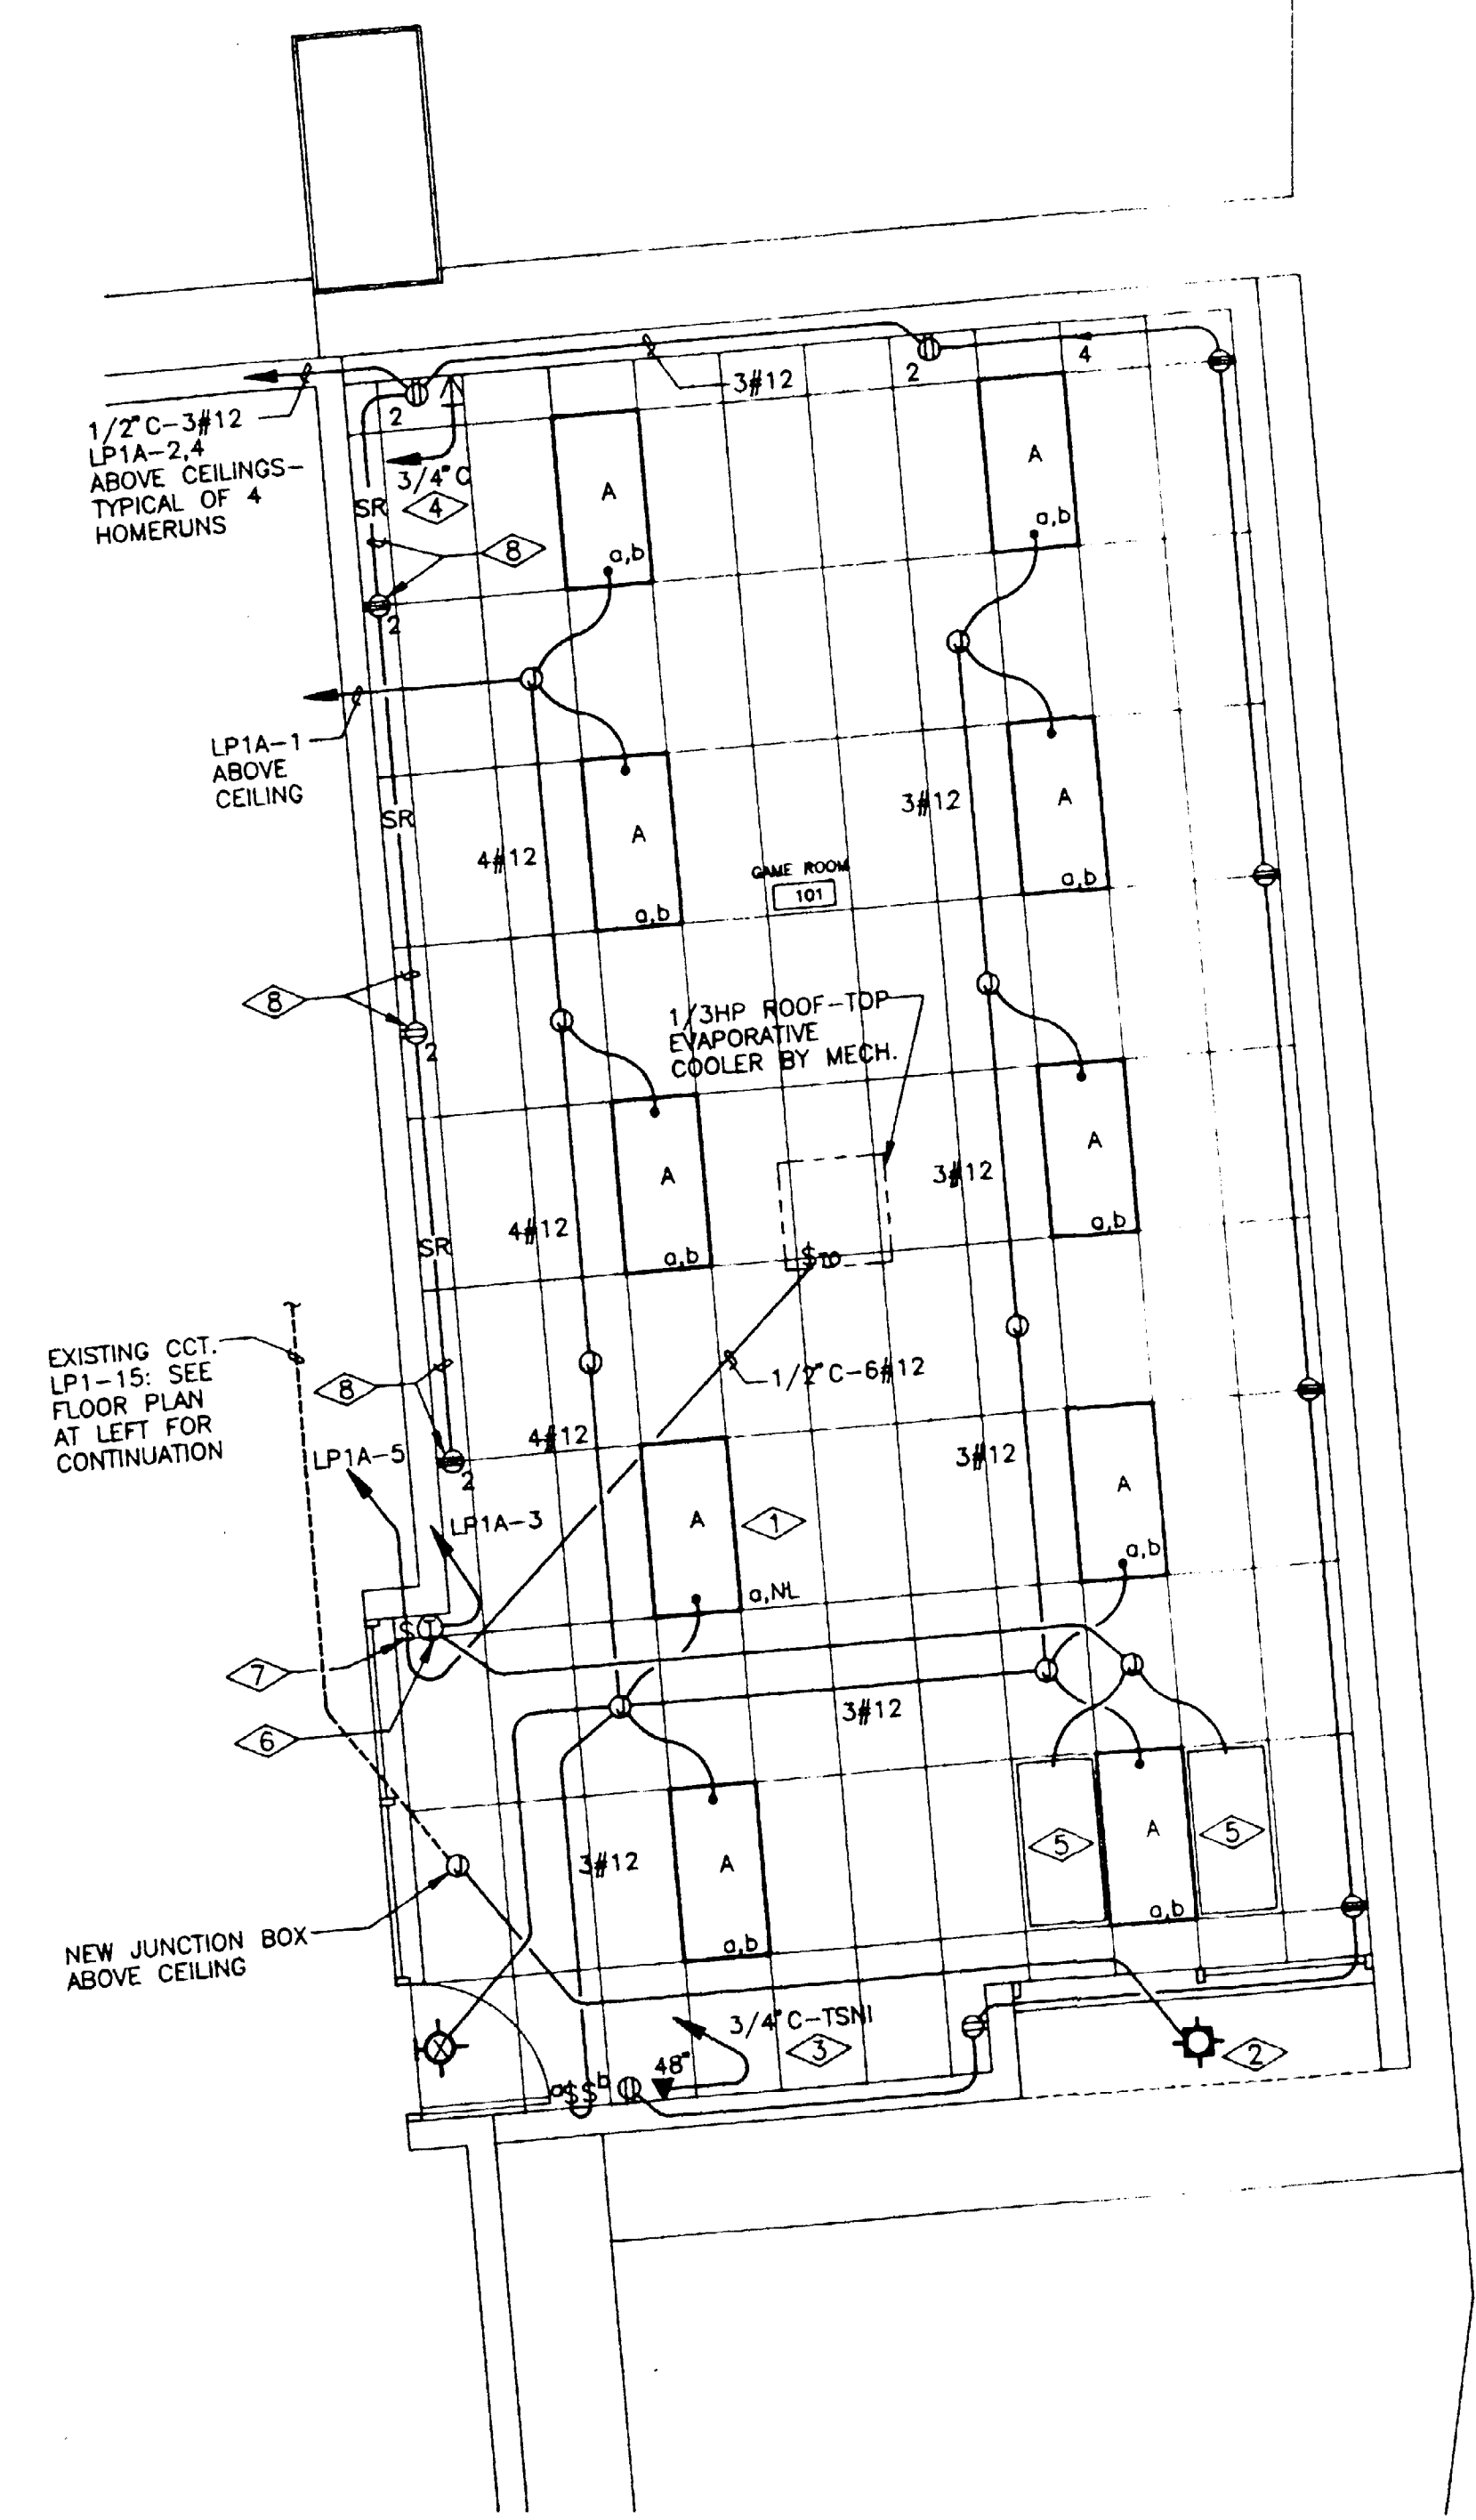

2 GAME ROOM ELECTRICAL PLAN
1/4"=1'-0"

02/13/92 11:32