




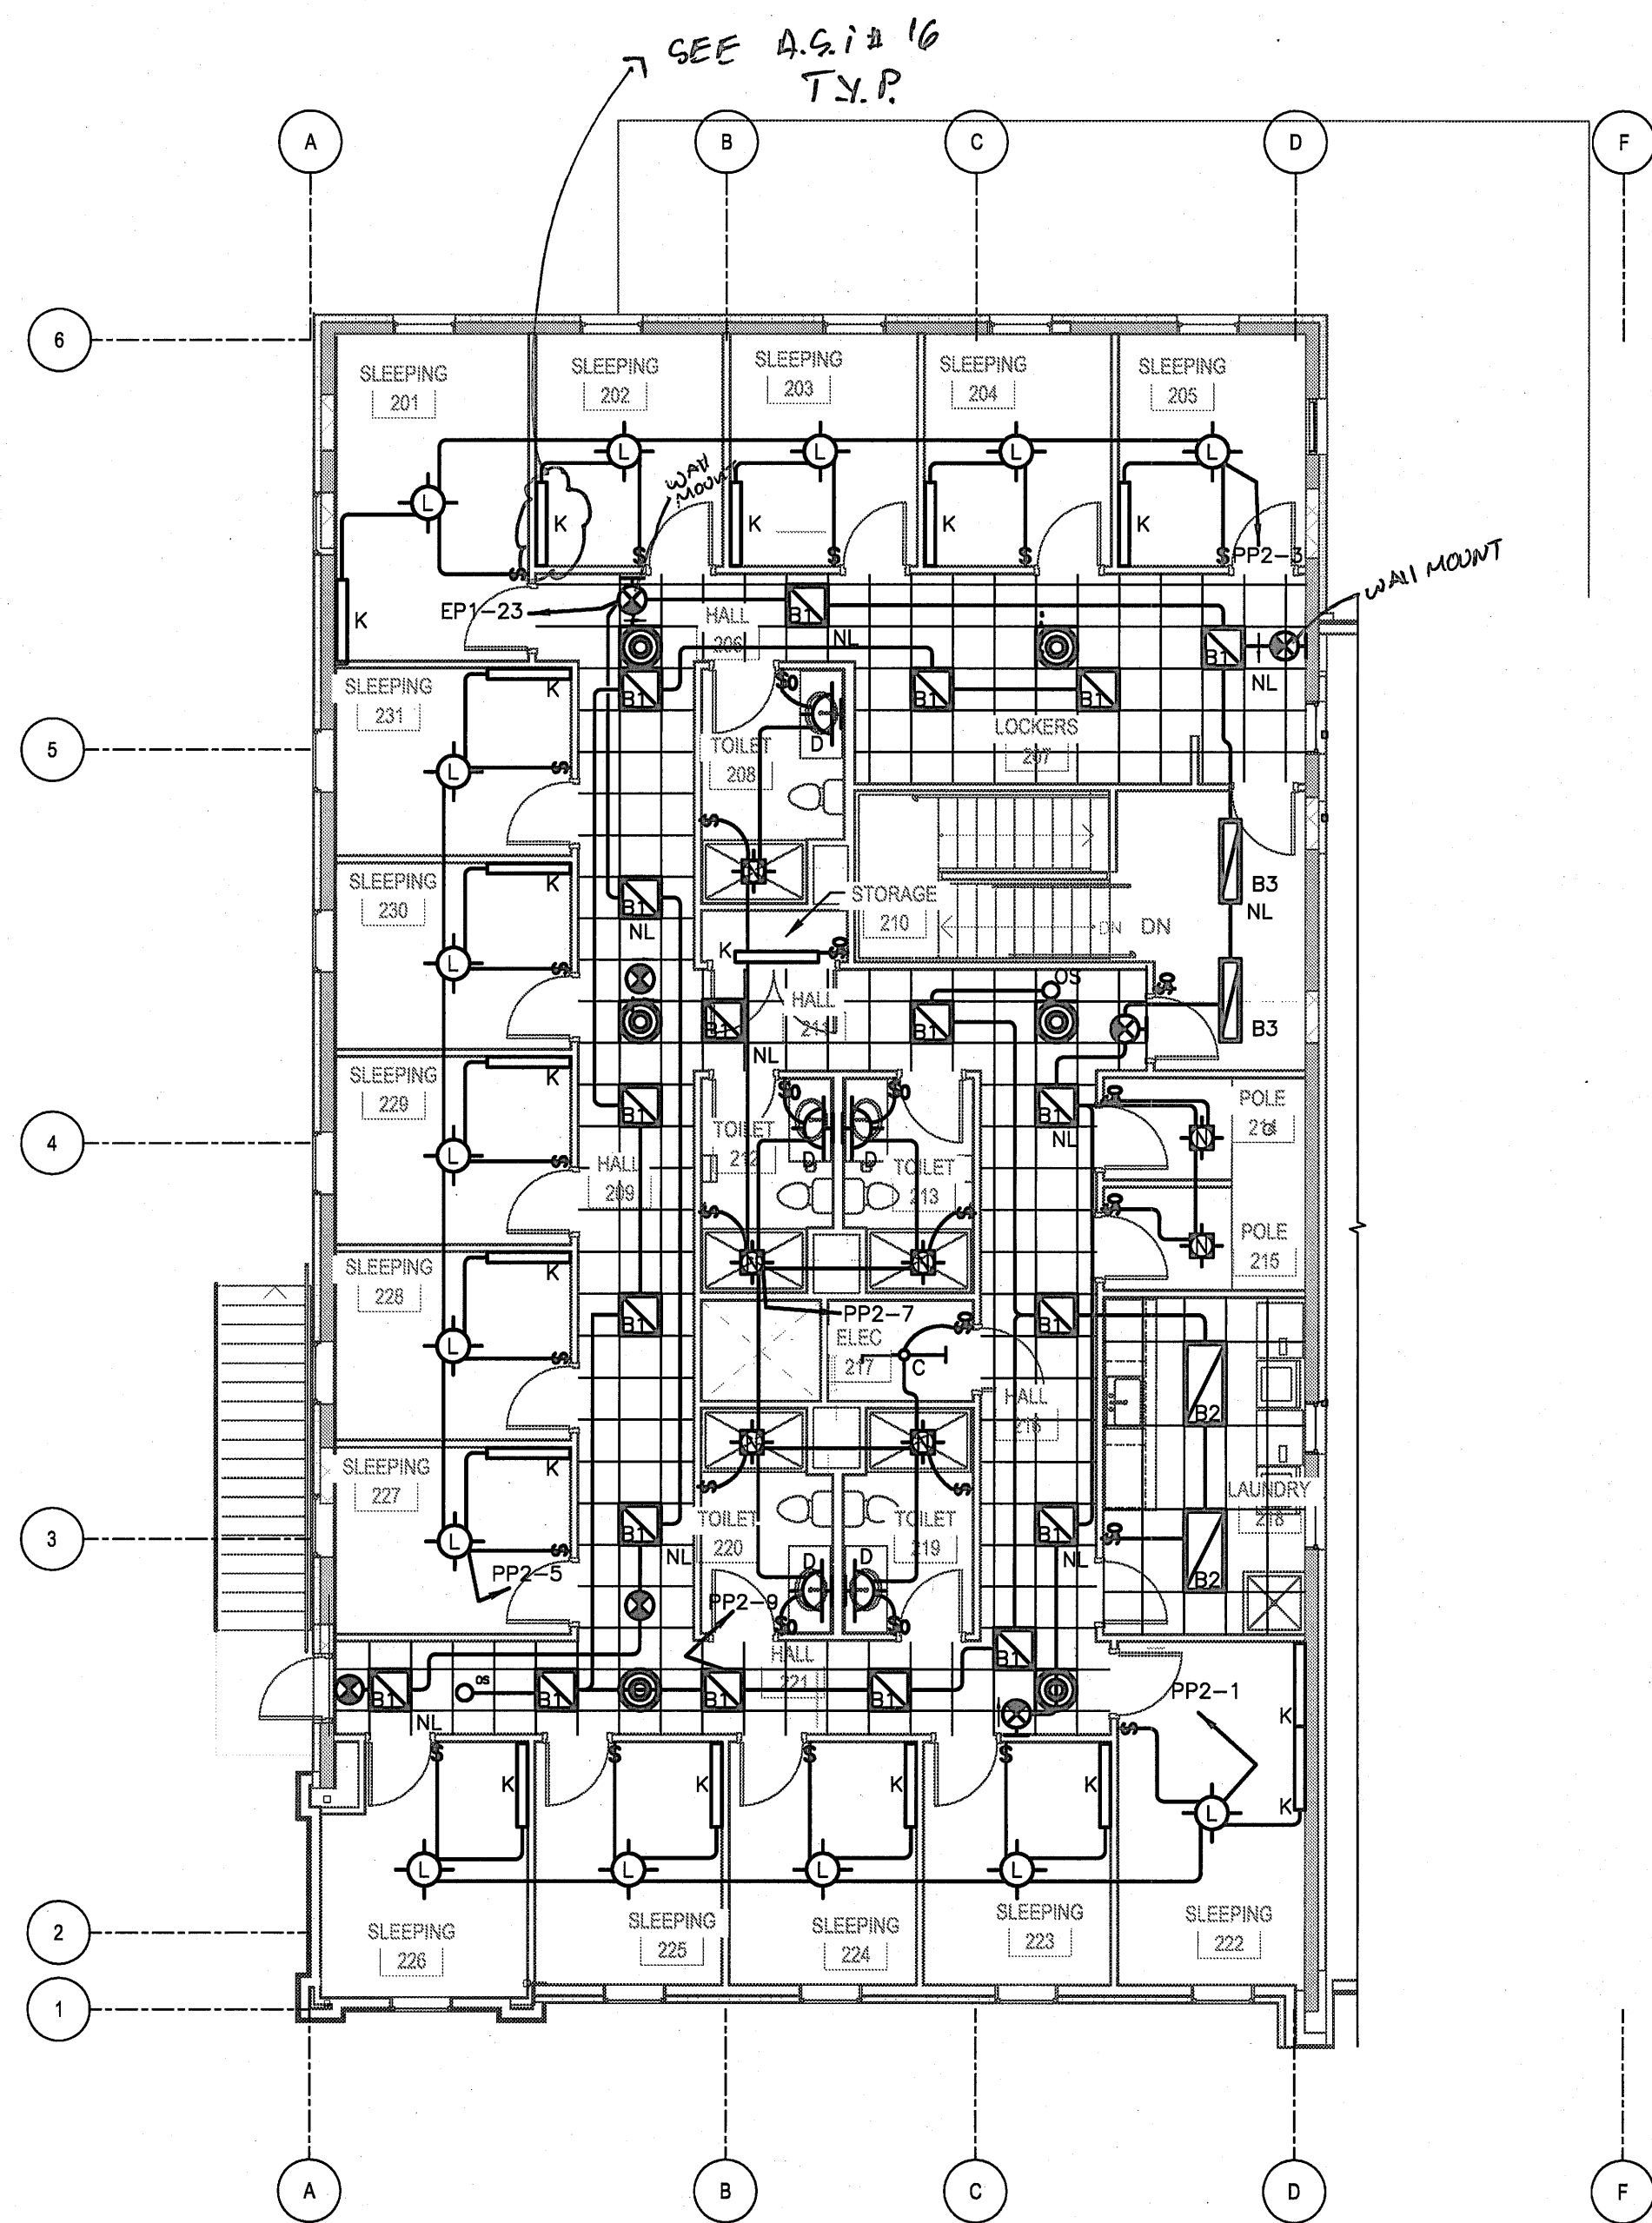

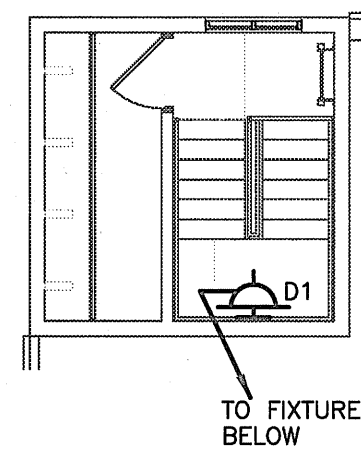


LIGHTING - UPPER FLOOR PLAN

SCALE: 1/8"=1'-0"

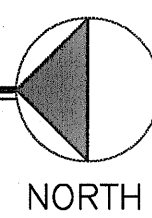

4TH FLOOR HOSE TOWER

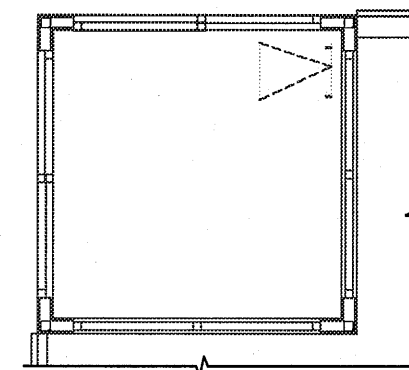

5TH FLOOR HOSE TOWER

