



Project Number:	23357	
Issue:	CONFORMANCE SET	
Date:	11.26.2024	
Drawn By:	MDG	
Checked By:	RIG	
Revisions:		
Rev.	Description	Date:
1	Addendum #1	2024.08.15
3	Addendum #3	2024.08.25

Sheet title:
BASEMENT MECHANICAL
EQUIPMENT PLAN

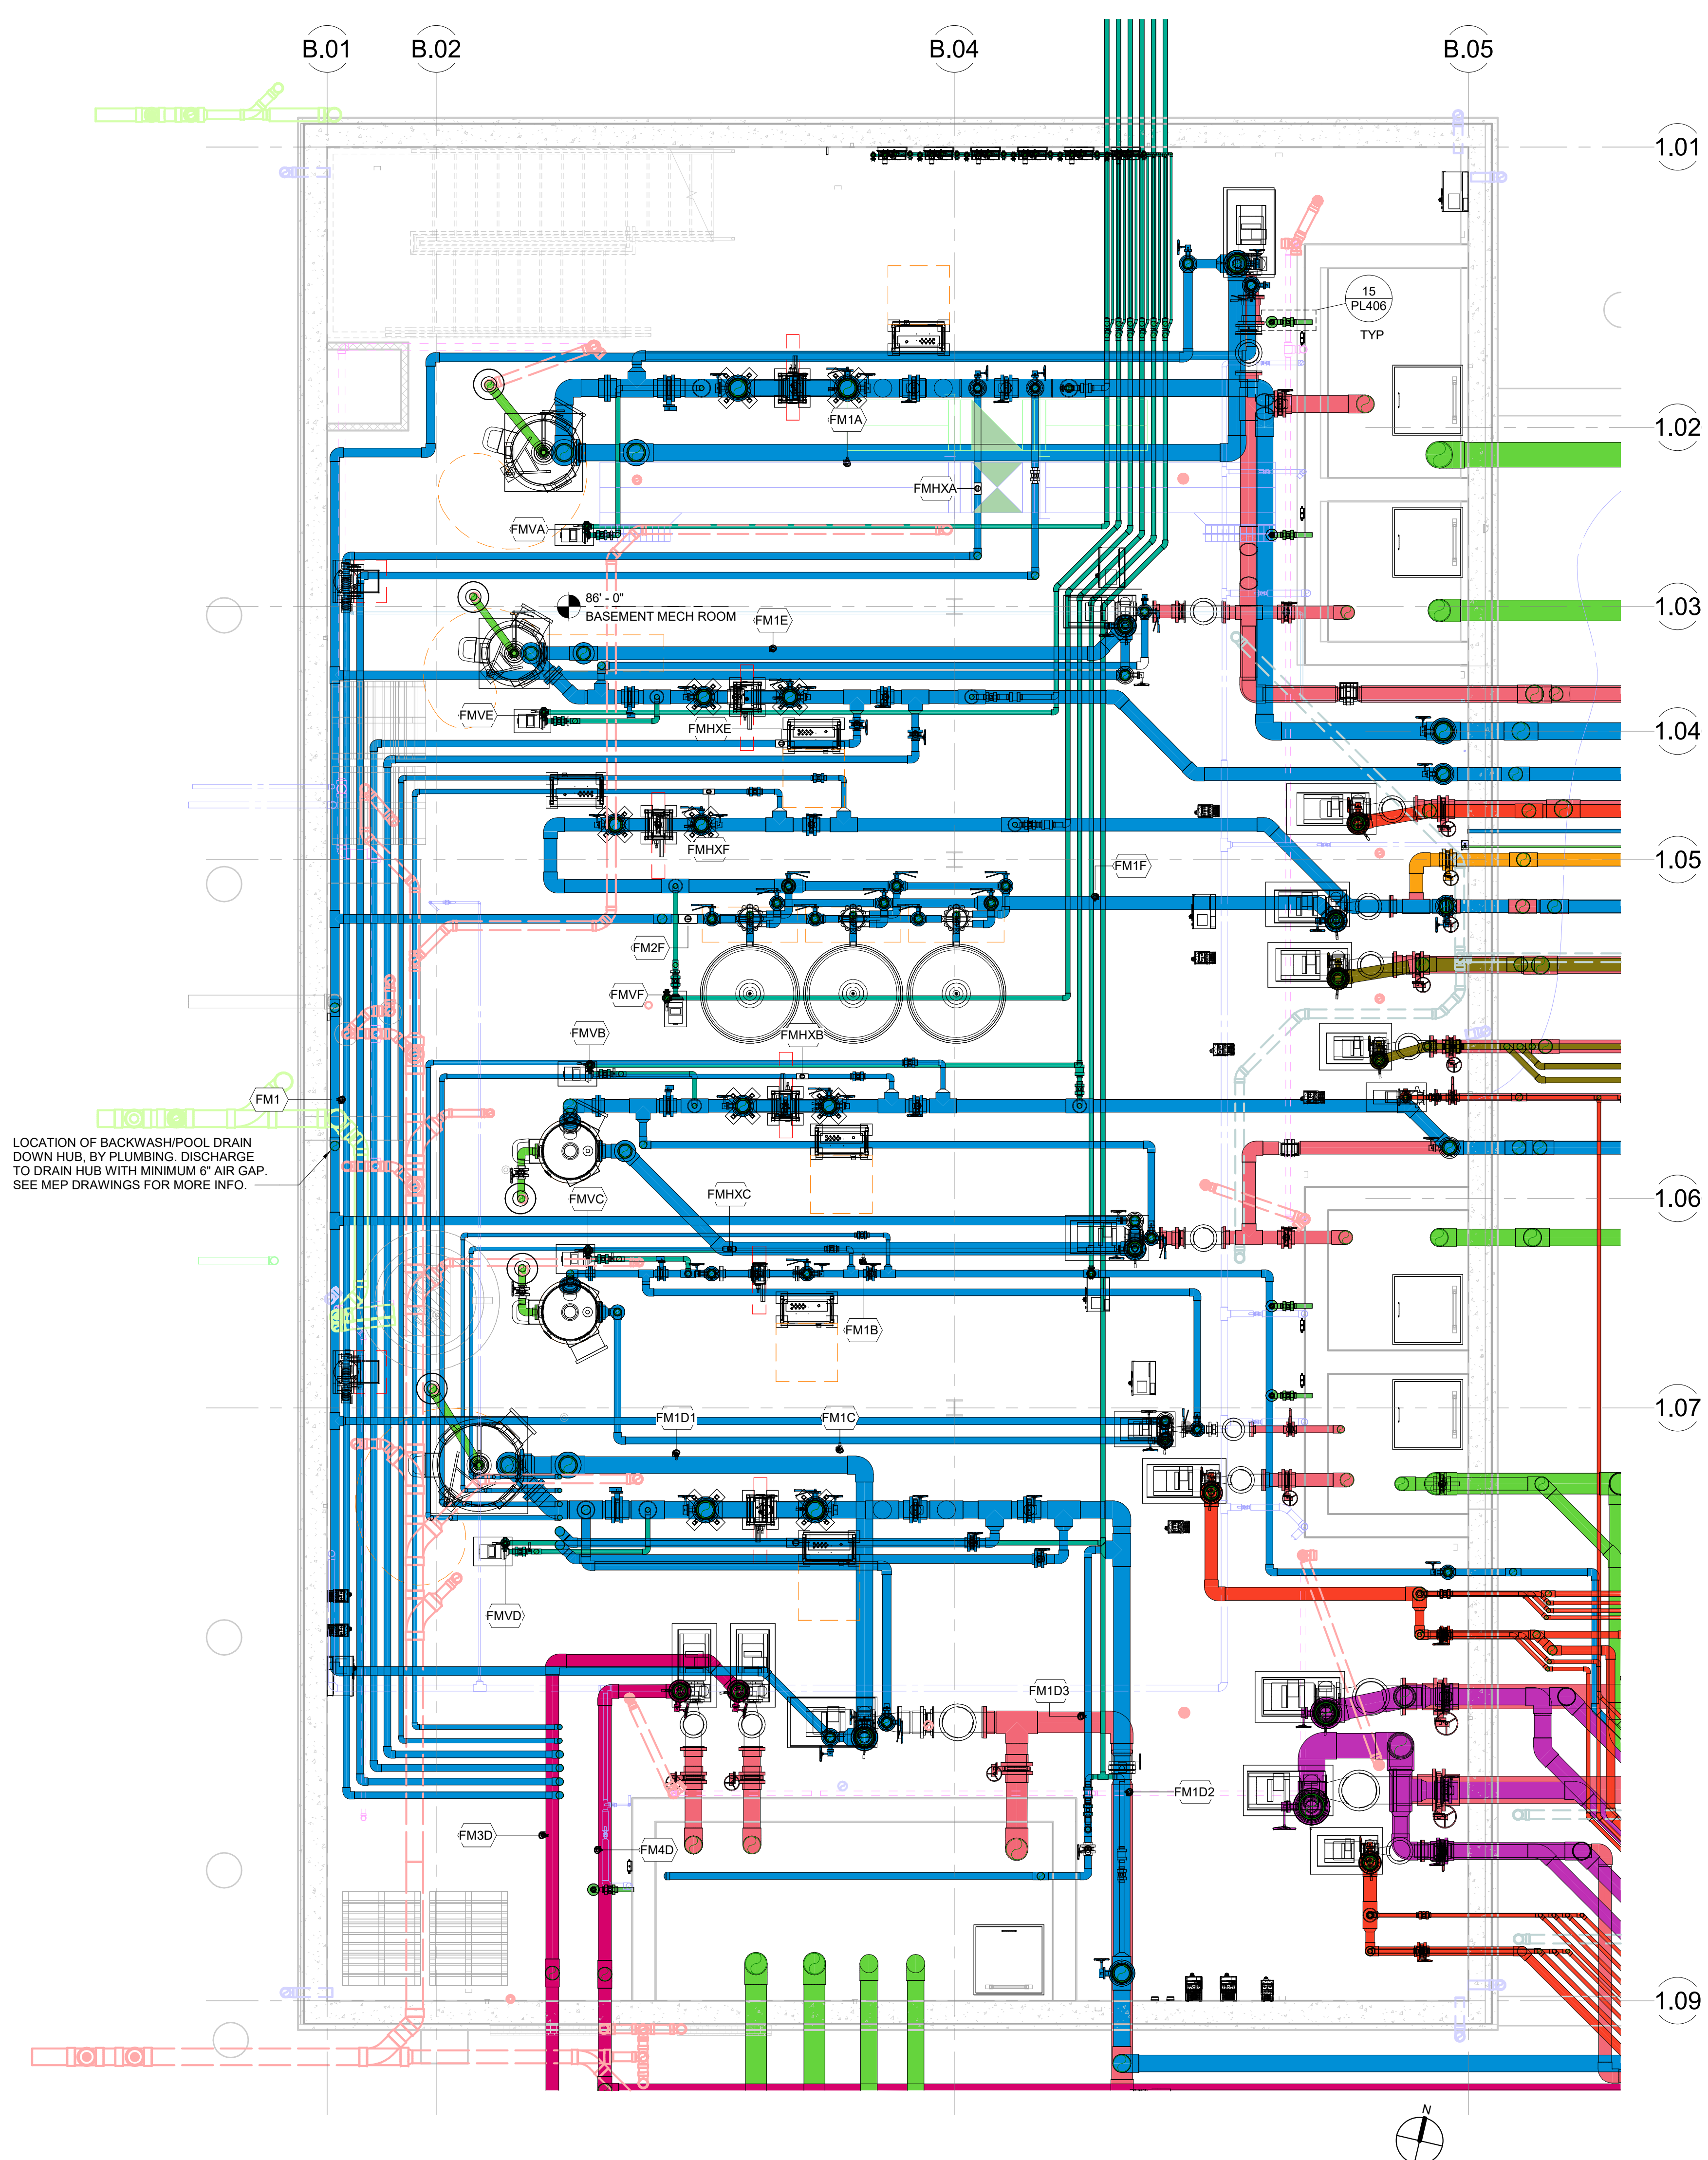

2 | BASEMENT MECHANICAL PIPING PLAN
PLAN VIEW
1/4" = 1'-0"

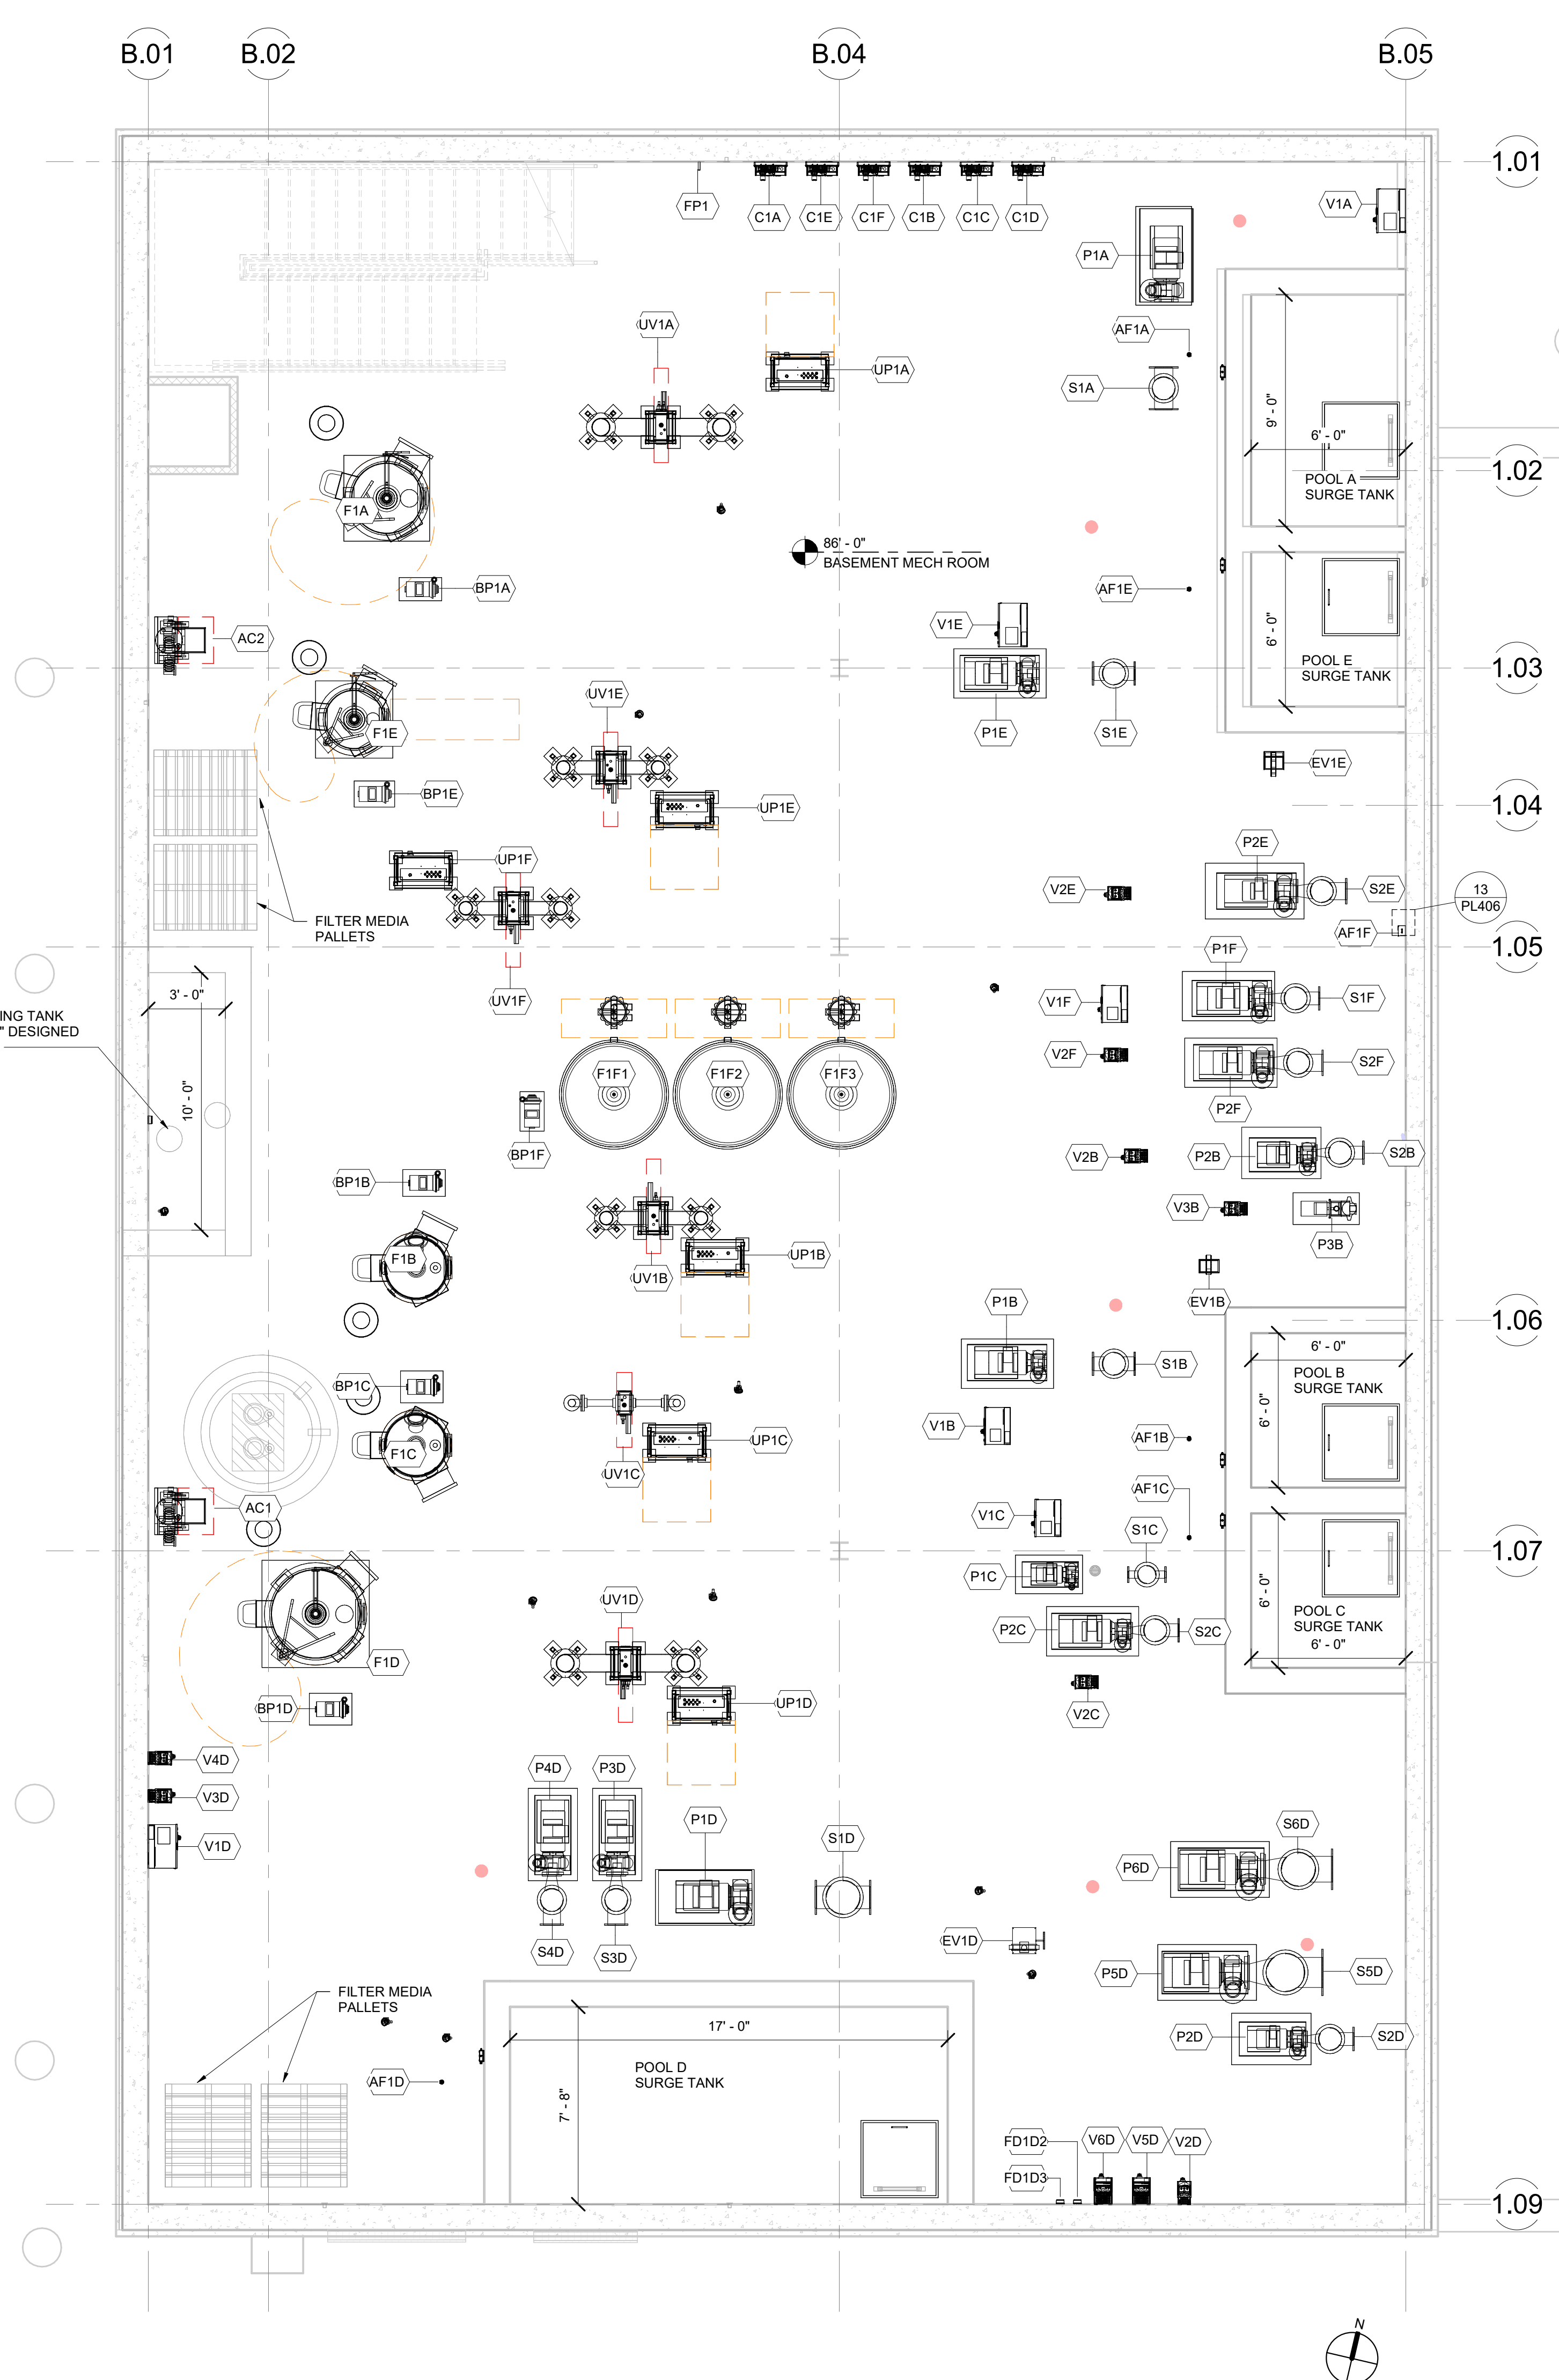

1 | BASEMENT MECHANICAL EQUIPMENT PLAN
PLAN VIEW
1/4" = 1'-0"

11/25/2024 4:55:09 PM Autodesk Docs://Grand Junction Community Recreation Center/23357_GJCRC_Aquatics_R24.rvt