

KEY MAP
SCALE 1" = 40'

PLAN CLARIFIER NO. 1
SCALE 3/16" = 1'-0"

NOTE: CLARIFIER NO. 2 SIMILAR & OPPOSITE HAND SEE KEY PLAN



DATE	DESCRIPTION	BY	APPROVED
11/17/84	AS SHOWN	PH	
11/18/84	DIMENSION CHANGED	PH	

AS RECORDED FROM INFORMATION PROVIDED BY THE CONTRACTOR DATE: 11/18/84

GRAND JUNCTION / MESA COUNTY, COLORADO
PERSIGO WASH WASTE WATER TREATMENT PLANT


SECTION V PROCESS
FINAL CLARIFIER PLAN

HENNINGSON, DURHAM & RICHARDSON, INC.
ENGINEERS PLANNERS CONSULTANTS
DENVER COLORADO GRAND JUNCTION COLORADO

DESIGNED BY: PH
CHECKED BY: PH
APPROVED BY: HENNINGSON
DATE: 11/18/84


734510
DWG 112 OF 191

07089711.tif

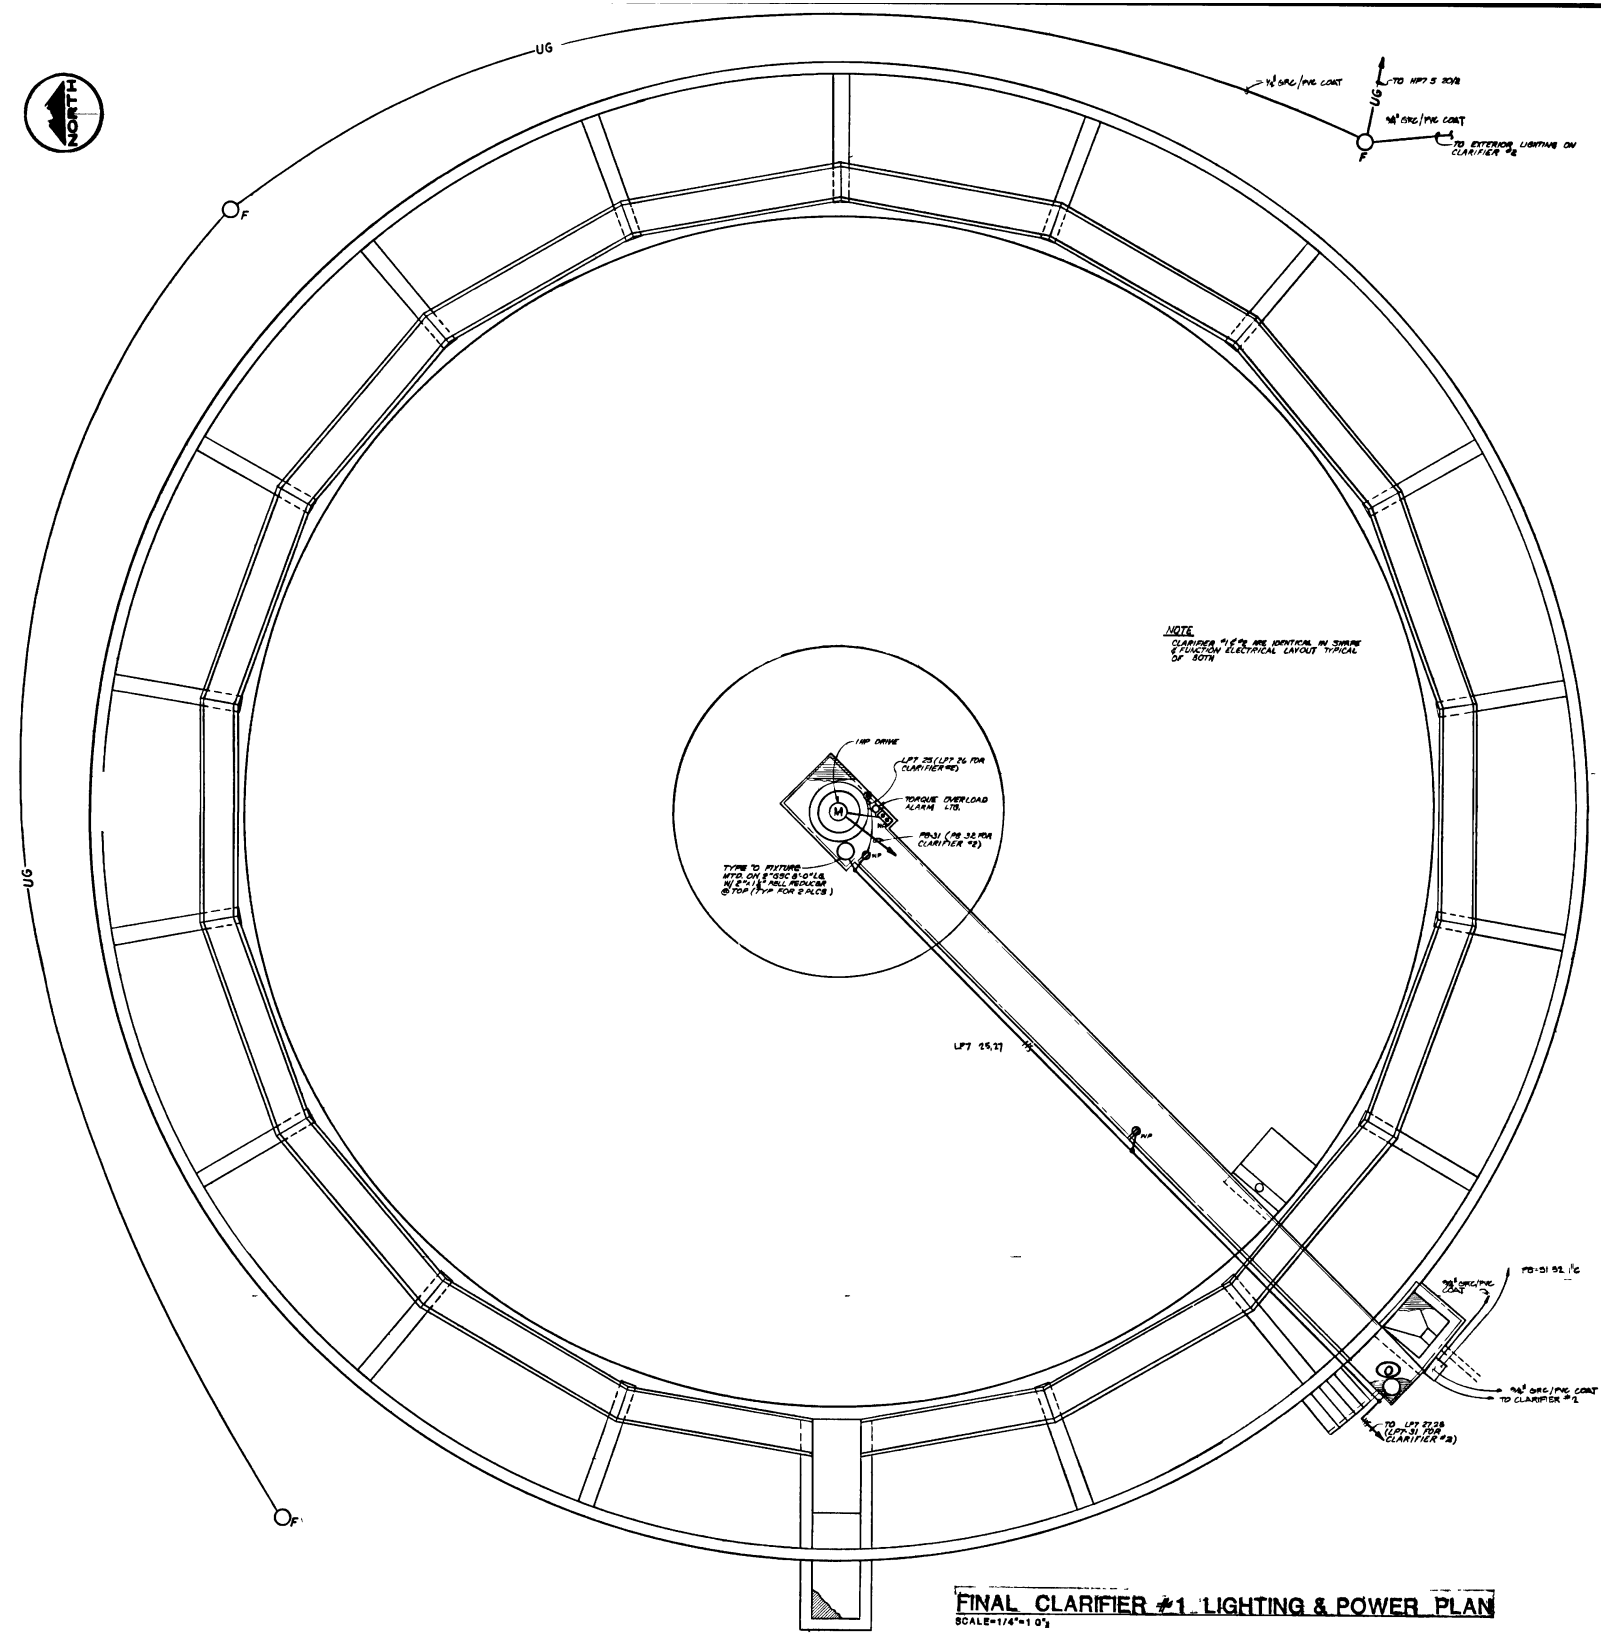

NOTE:
CLARIFIER #1 & #2 ARE IDENTICAL IN SIZE
& FUNCTION. ELECTRICAL LAYOUT TYPICAL
OF BOTH

FINAL CLARIFIER #1 LIGHTING & POWER PLAN
SCALE=1/4"=1'-0"

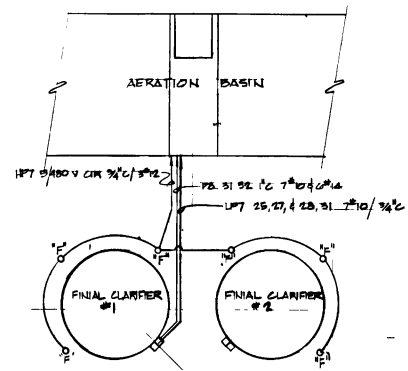



BRAND JUNCTION / MESA COUNTY,
COLORADO
**PERBGO WASH
WASTEWATER TREATMENT
PLANT**
SECTION VII ELECTRICAL
**FINAL CLARIFIER NO 1 & NO 2
LIGHTING & POWER PLAN**

"AS RECORDED"
FROM INFORMATION
PROVIDED BY THE
CONTRACTOR
DATE: 08/15/88


DATE	DESCRIPTION	BY	APPROVED
12/15/84	AS BUILT	D.S.	
4-10-88	REVISED PER FINAL REVIEW	J.M.	C.C.M.

SHANNON RINK & ASSOCIATES, INC.
ENGINEERS PLANNERS CONSULTANTS
DENVER COLORADO GRAND JUNCTION COLORADO
JOB NUMBER: 734510 SHEET: 02-12
ISSUED: RDM APPROVED: SCS DATE: 08/15/88
734510 ISSUED: RDM DATE: 08/15/88


07087963.tif

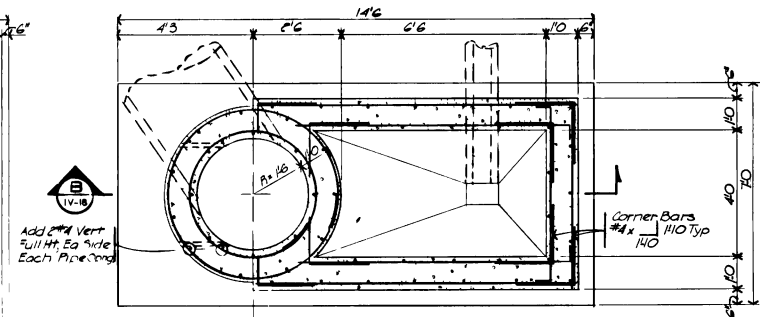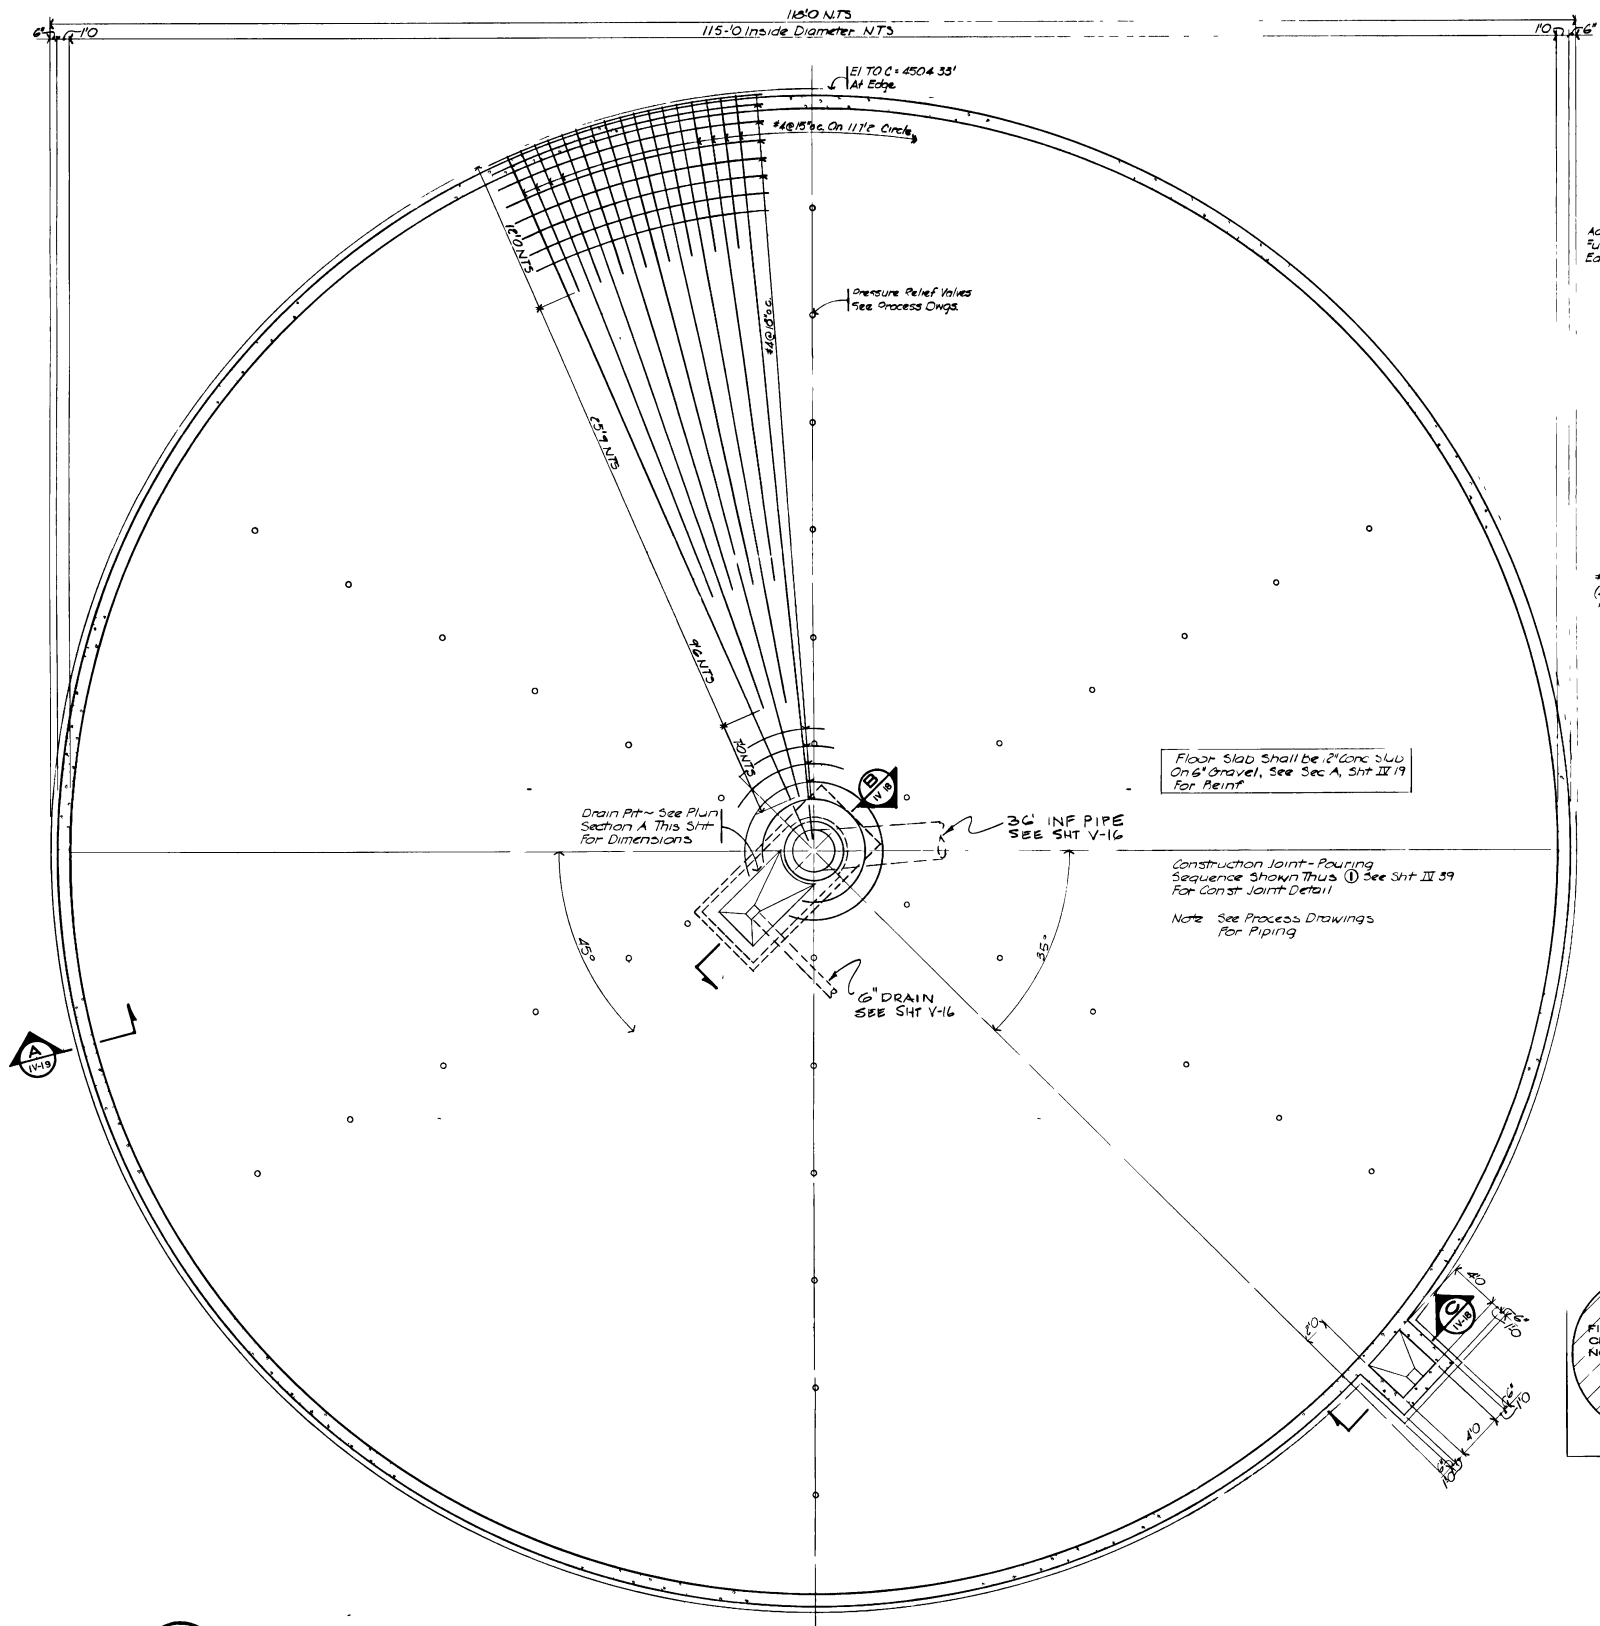


SECTION A
SCALE: 1/2" = 1'-0"
IV-18

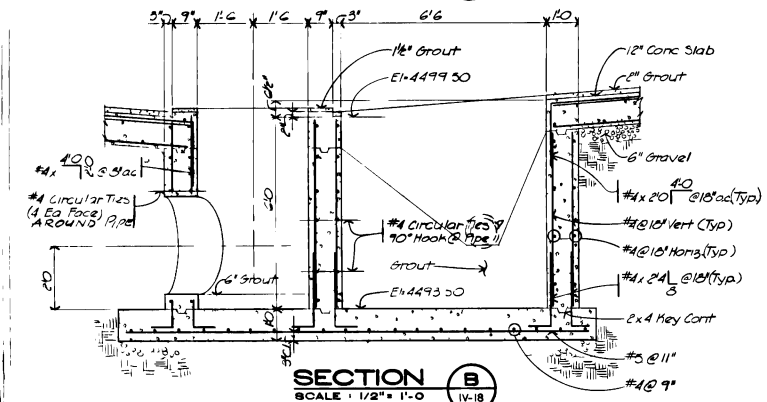


SECTION B
SCALE: 1/2" = 1'-0"
IV-18

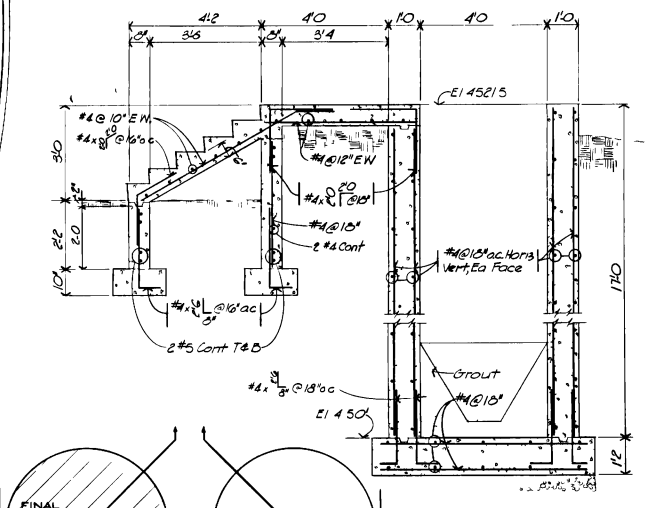

SECTION C
SCALE: 1/2" = 1'-0"
IV-18

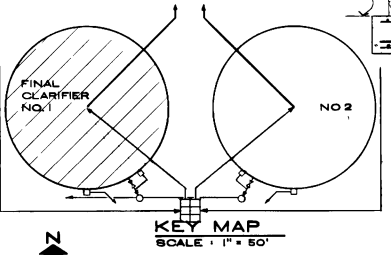

"AS RECORDED"
FROM INFORMATION
PROVIDED BY THE
CONTRACTOR
DATE: 11/1/04

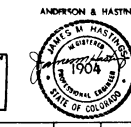

FLOOR PLAN
SCALE: 3/16" = 1'-0"

NOTE: CLARIFIER NO 2 SIMILAR
AND OPPOSITE HAND

07087874.tif

ANDERSON & HASTINGS

GRAND JUNCTION / MESA COUNTY, COLORADO
PERSIGO WASH WASTE WATER TREATMENT PLANT
SECTION IV STRUCTURAL


FINAL CLARIFIER
FLOOR PLAN AND SECTIONS

HINNINGSON, DURHAM & RICHARDSON, INC.
ENGINEERS PLANNERS CONSULTANTS
DENVER COLORADO GRAND JUNCTION COLORADO

DATE	DESCRIPTION	BY	CHKD	APPROV	DATE
11/1/04	As Built				

734510
DESIGNED: RLS
CHECKED: JKH
DATE: 11/1/04


DWG: 75 OF 131

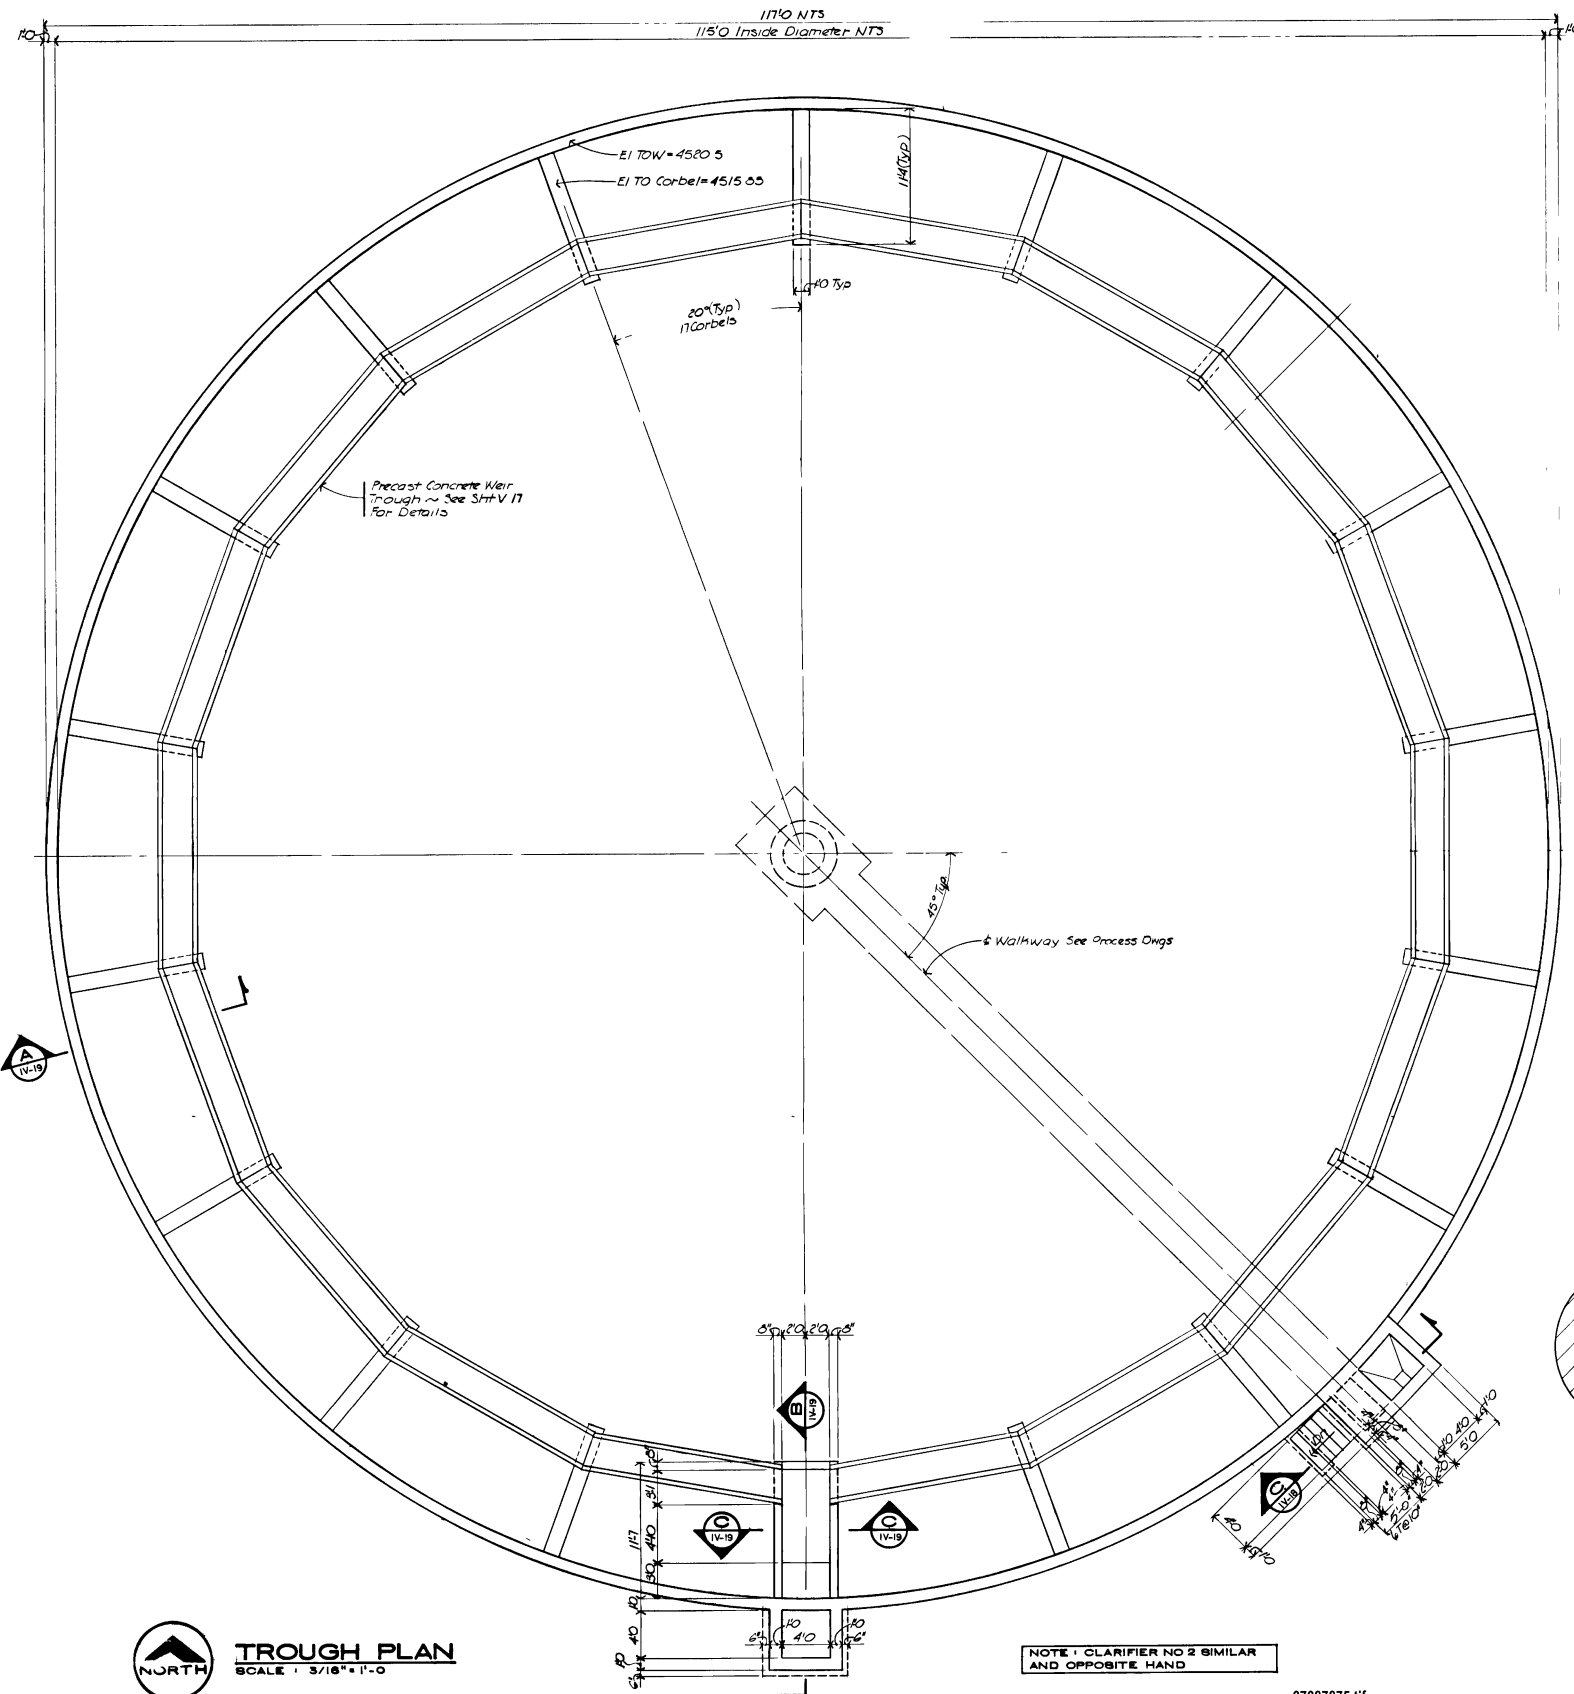


TROUGH PLAN
SCALE: 3/16" = 1'-0"

NOTE: CLARIFIER NO 2 SIMILAR AND OPPOSITE HAND


07087875.tif

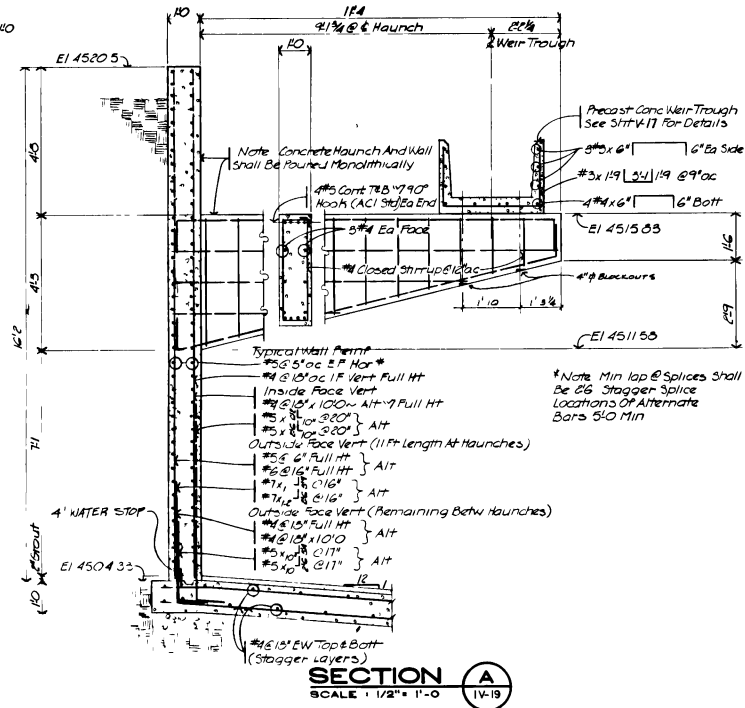

SECTION A
SCALE: 1/2" = 1'-0"

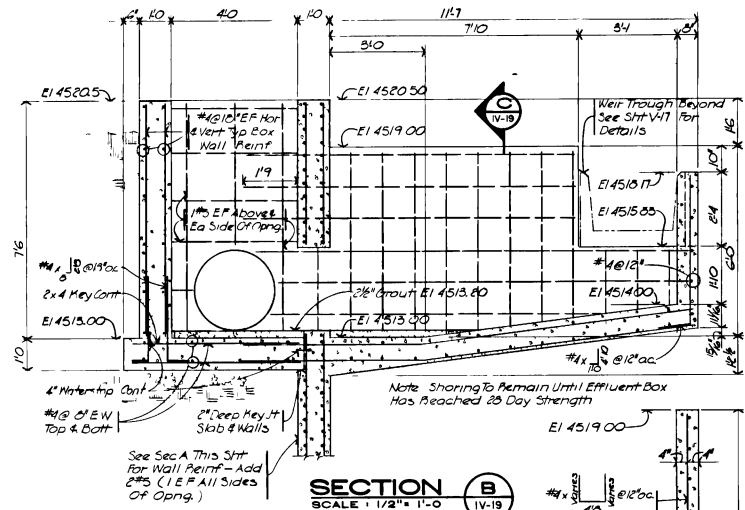

SECTION B
SCALE: 1/2" = 1'-0"

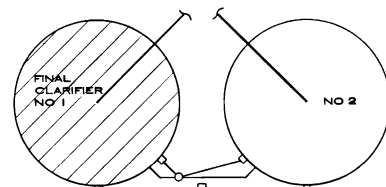

KEY MAP
SCALE: 1" = 50'-0"



"AS RECORDED" FROM INFORMATION PROVIDED BY THE CONTRACTOR DATE: MAY 1985

GRAND JUNCTION / MESA COUNTY, COLORADO
PERIGO WASH WASTEWATER TREATMENT PLANT


SECTION IX STRUCTURAL

FINAL CLARIFIER
TROUGH PLAN AND SECTIONS


HINNINGSON, DURHAM & RICHARDSON, INC.
BUSINESS PLANNERS CONSULTANTS
DENVER COLORADO GRAND JUNCTION COLORADO

NO.	DATE	DESCRIPTION	BY	APPROVED
1	10/17/84	As Drawn		


JOB NO. 734510
DATE: 10/17/84
SHEET IV-19 OF 191

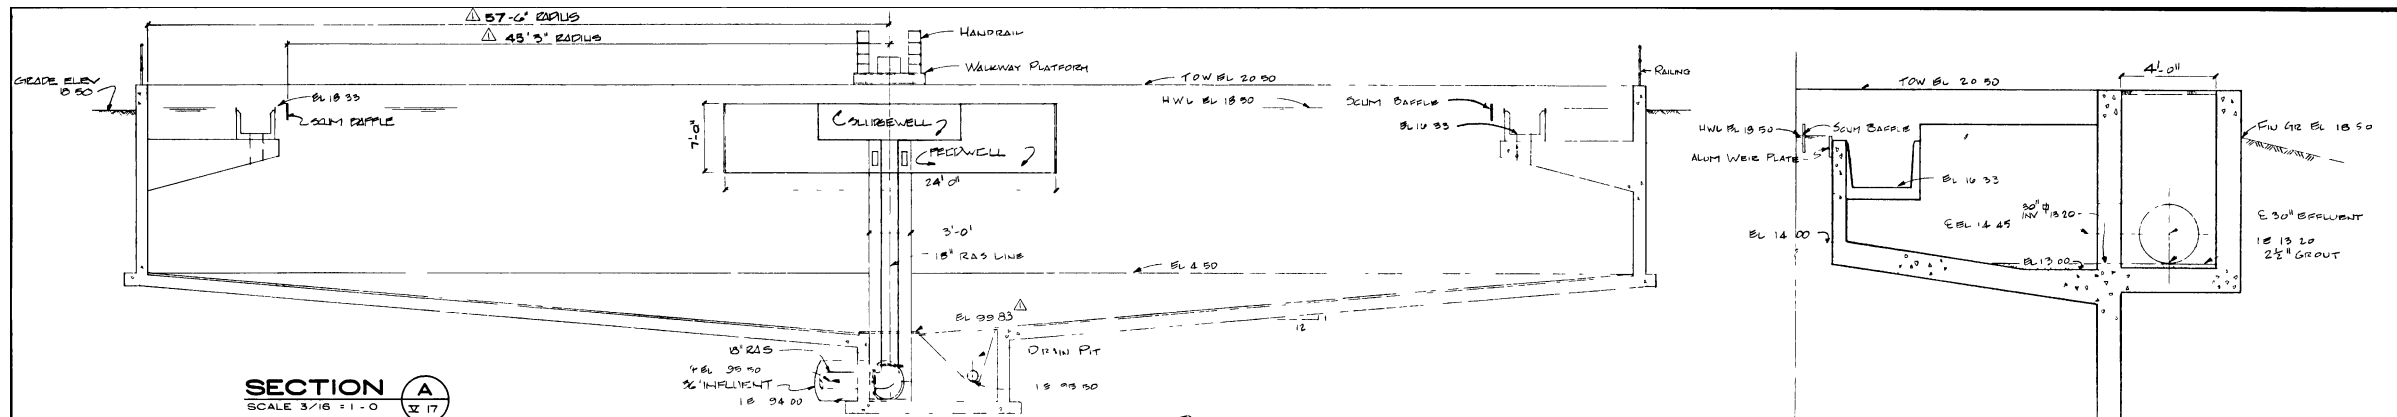


SECTION A
SCALE 3/8" = 1'-0"
X-17

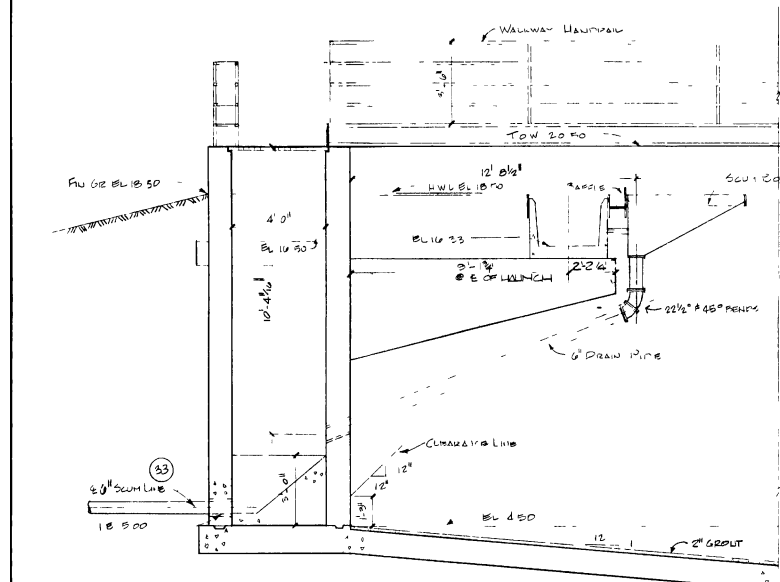


SECTION B
SCALE 3/8" = 1'-0"
X-17

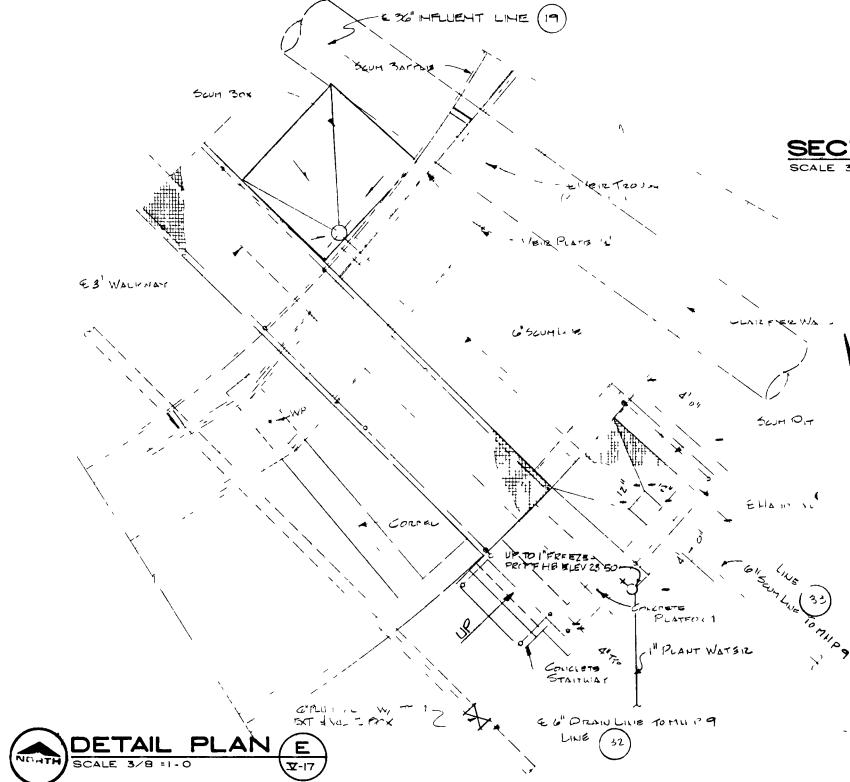


DETAIL PLAN E
SCALE 3/8" = 1'-0"
X-17

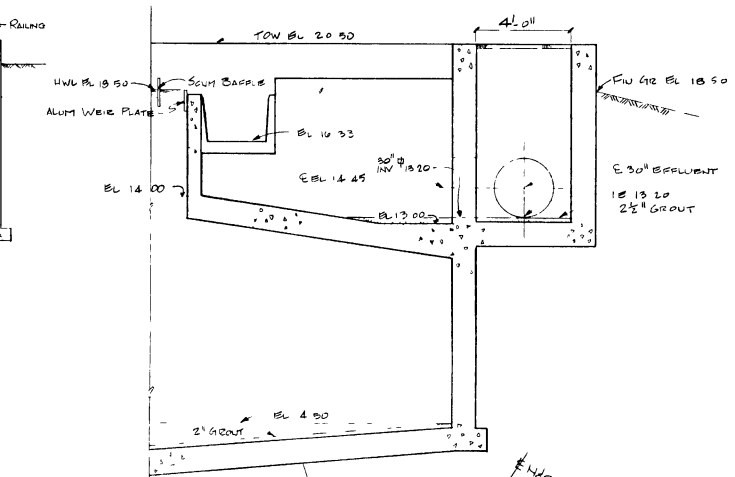


SECTION C
SCALE 3/8" = 1'-0"
X-17

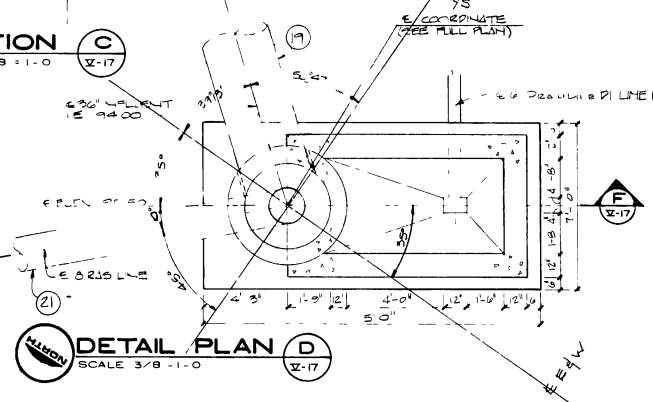


DETAIL PLAN D
SCALE 3/8" = 1'-0"
X-17

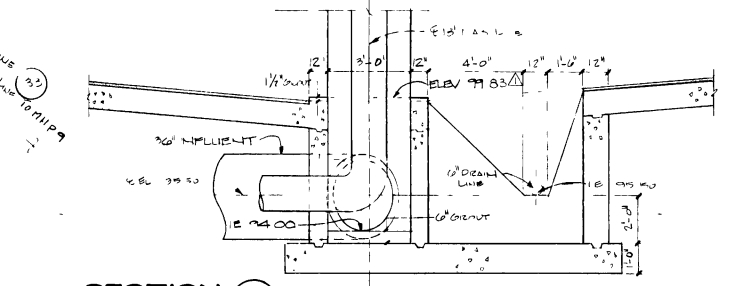


SECTION F
SCALE 3/8" = 1'-0"
X-17

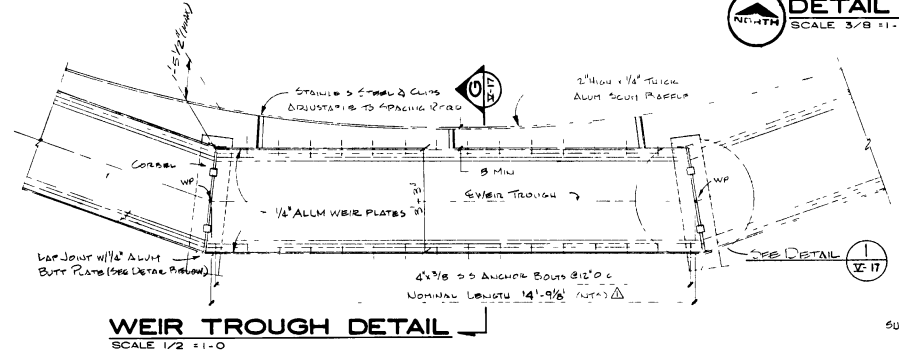


WEIR TROUGH DETAIL
SCALE 1/2" = 1'-0"

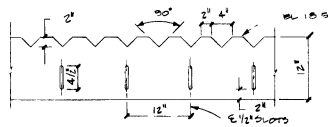

WEIR PLATE DETAILS
NO SCALE

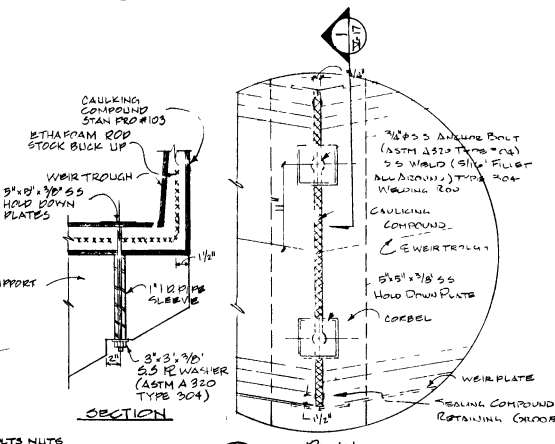

DETAIL I
SCALE 1/2" = 1'-0"
X-17

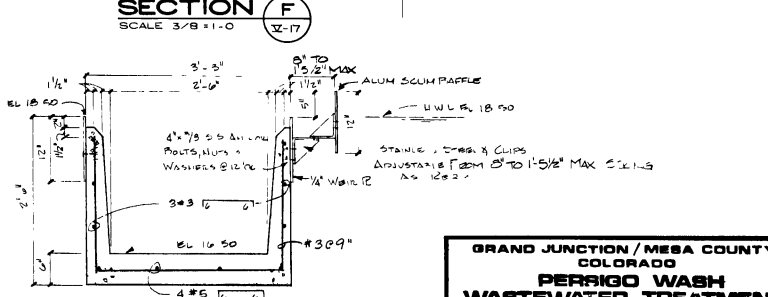

SECTION G
SCALE 1" = 1'-0"
X-17

GRAND JUNCTION / MESA COUNTY,
COLORADO
**PERRIGO WASH
WASTEWATER TREATMENT
PLANT**

SECTION X PROCESS


FINAL CLARIFIER

PLANS SECTIONS DETAILS

HINNINGSON, DURHAM & RICHARDSON, INC.
ENGINEERS PLANNERS CONSULTANTS
DENVER COLORADO GRAND JUNCTION COLORADO

JOB NO. 734510
DESIGNED BY: [Name]
CHECKED BY: [Name]
DATE: [Date]

SHEET X-17 OF 191
DWG. 113

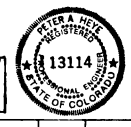

AS RECORDED
FROM INFORMATION
PROVIDED BY THE
CONTRACTORS
DATE: [Date]

07087912.tif