


4775
4770
4765
4760
4755
4750
4745
4740
4735

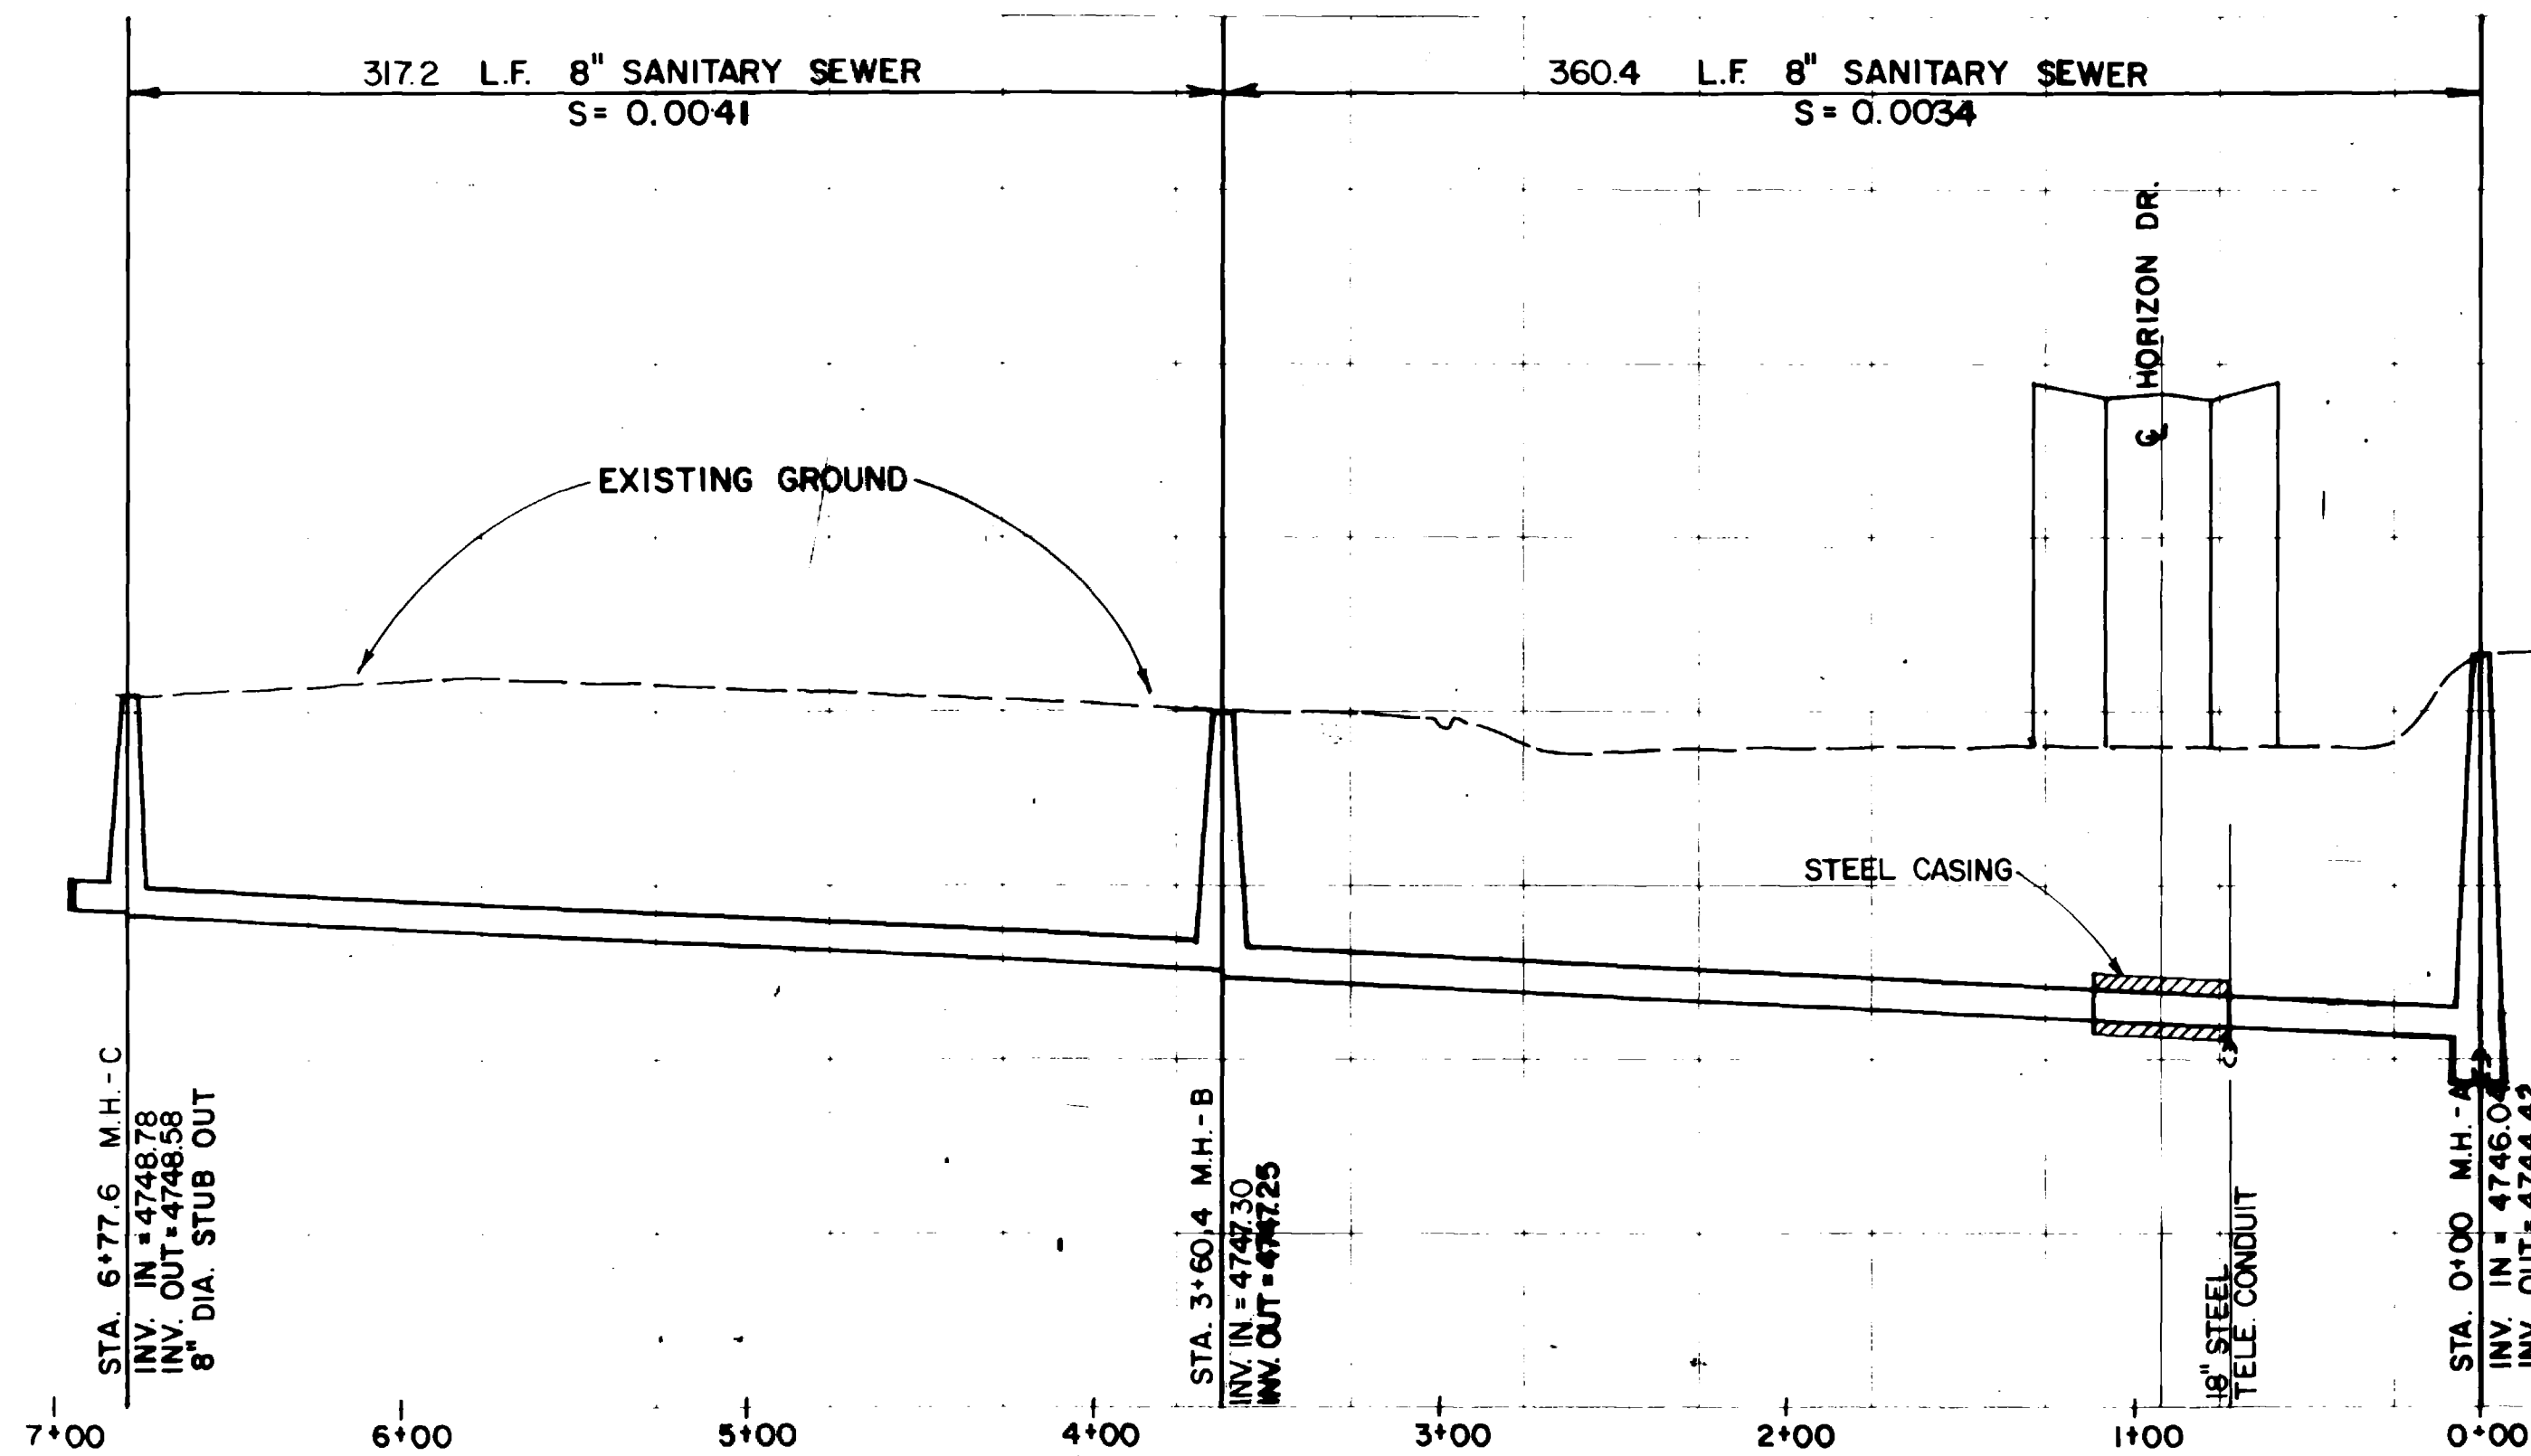

HORIZ SCALE 1" = 50'
VERT. SCALE 1" = 5'

4775
4770
4765
4760
4755
4750
4745
4740
4735


AS-BUILT

NOTE: THE INFILTRATION RATE DOES NOT EXCEED 200 GALLONS PER INCH OF NOMINAL PIPE DIAMETER PER DAY PER MILE OF SEWERLINE.

NOTE:
ALL CONSTRUCTION SHALL BE IN ACCORDANCE WITH CITY OF GRAND JUNCTION STANDARD SPECIFICATIONS FOR CONSTRUCTION OF WATERLINES, SANITARY SEWERS, STORM DRAINAGE AND IRRIGATION SYSTEMS, 1981 AND STANDARD DRAWING SS-1 FOR SANITARY SEWER DETAILS.
REFER TO DRAWING SS-1 FOR TRENCH DETAILS AND TYPICAL MANHOLE CONSTRUCTION.
CONTRACTOR SHALL CONTACT THE CITY UTILITIES SUPERINTENDENT, MR. RALPH STERRY 244-1568 PRIOR TO ANY WORK INVOLVING THE EXISTING LINE. EXISTING SEWER FLOWS MUST BE MAINTAINED AT ALL TIMES.

A Professional Corporation
ARIX
Engineers Architects Planners
Crealey, Colorado
Grand Junction, Colorado
Riverton, Wyoming

THIS DRAWING IS THE PROPERTY OF ARIX, AND IS NOT TO BE REPRODUCED, MODIFIED OR USED FOR ANY OTHER PROJECT OR EXTENSION OF THIS PROJECT EXCEPT BY AGREEMENT WITH SAID COMPANY.

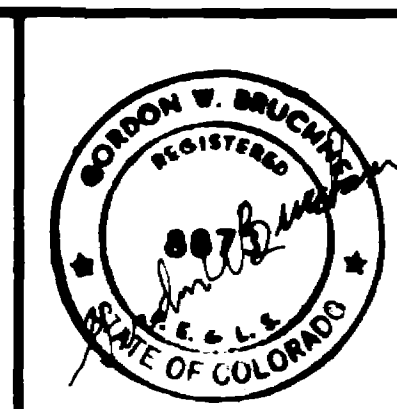

SCALE AS SHOWN
DRAWN DDC
CHECKED [Signature]
APPROVED [Signature]
DATE JULY 1981
PROJECT NO. 80170-00

ENTRANCE CH FOUR COMMERCIAL PARK
OXY OCCIDENTAL OIL SHALE, INC.
SANITARY SEWER IMPROVEMENT