
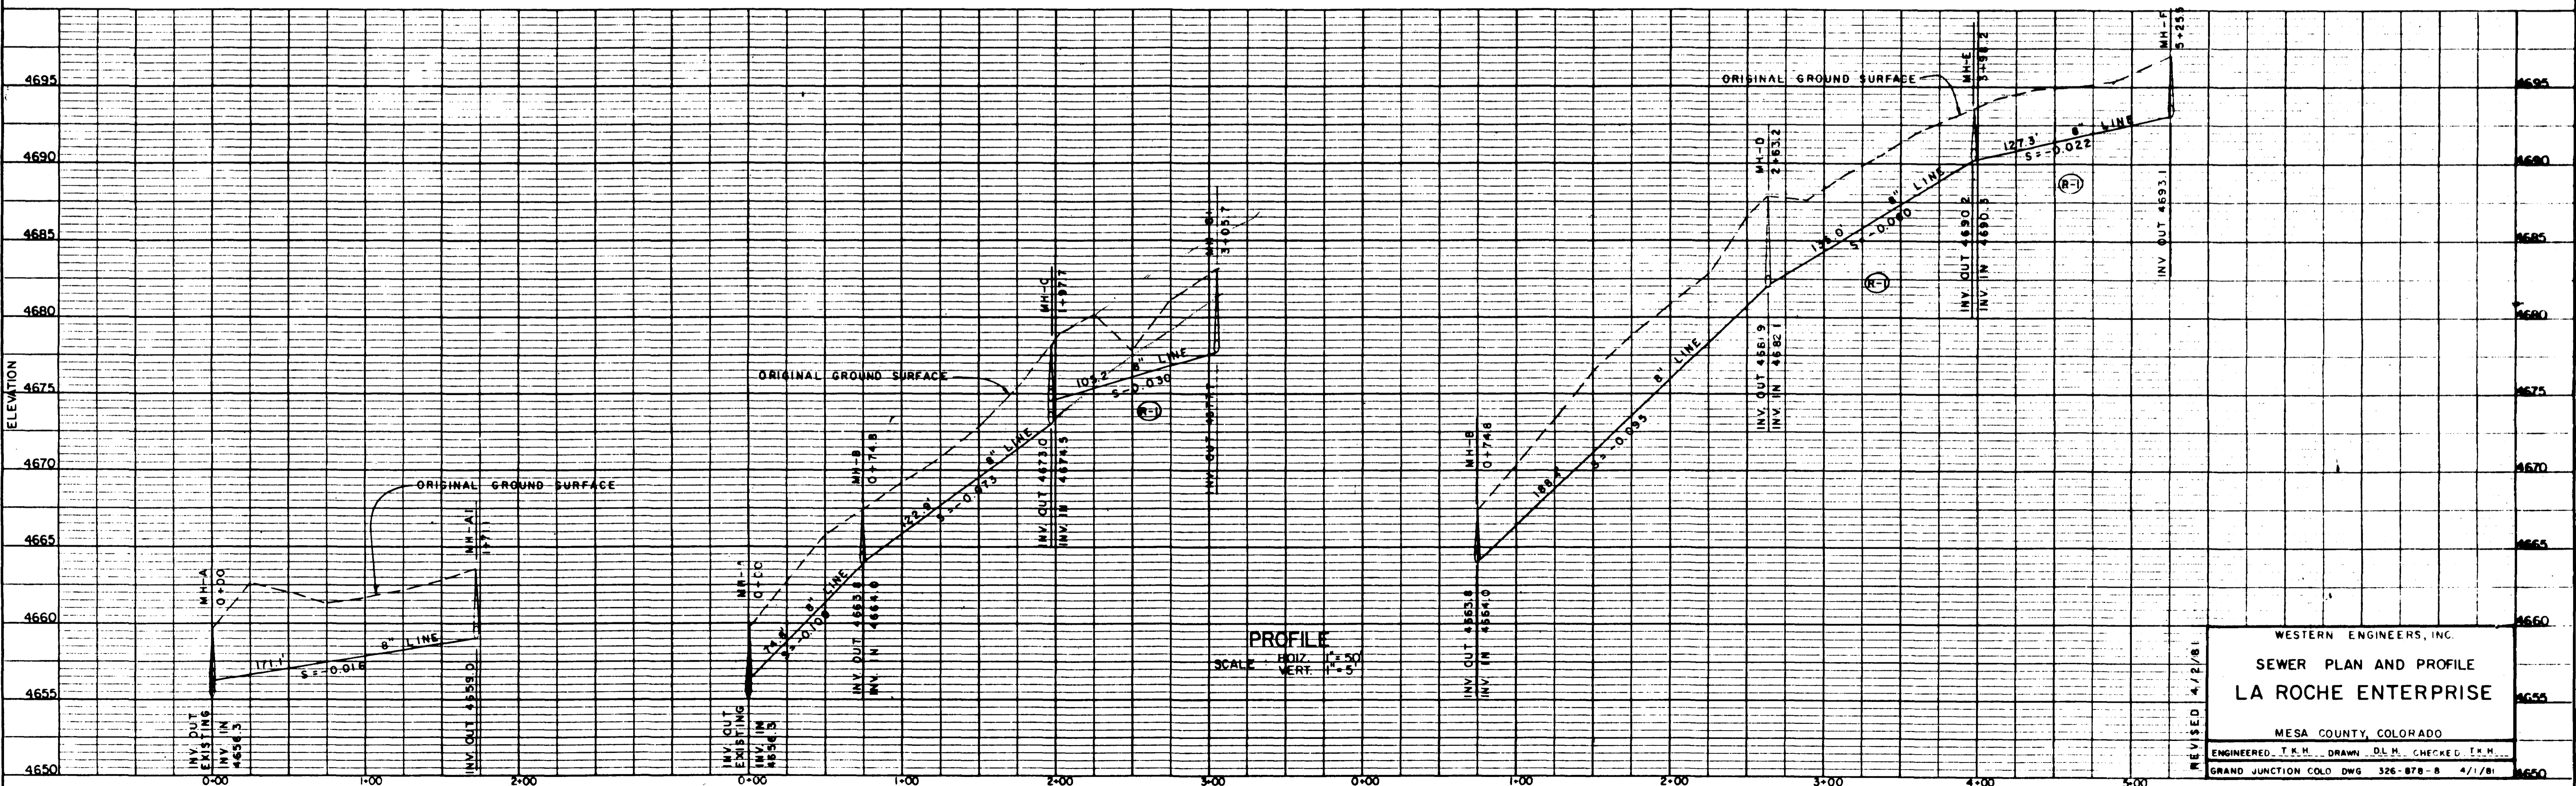


PLAN
SCALE: 1" = 50'

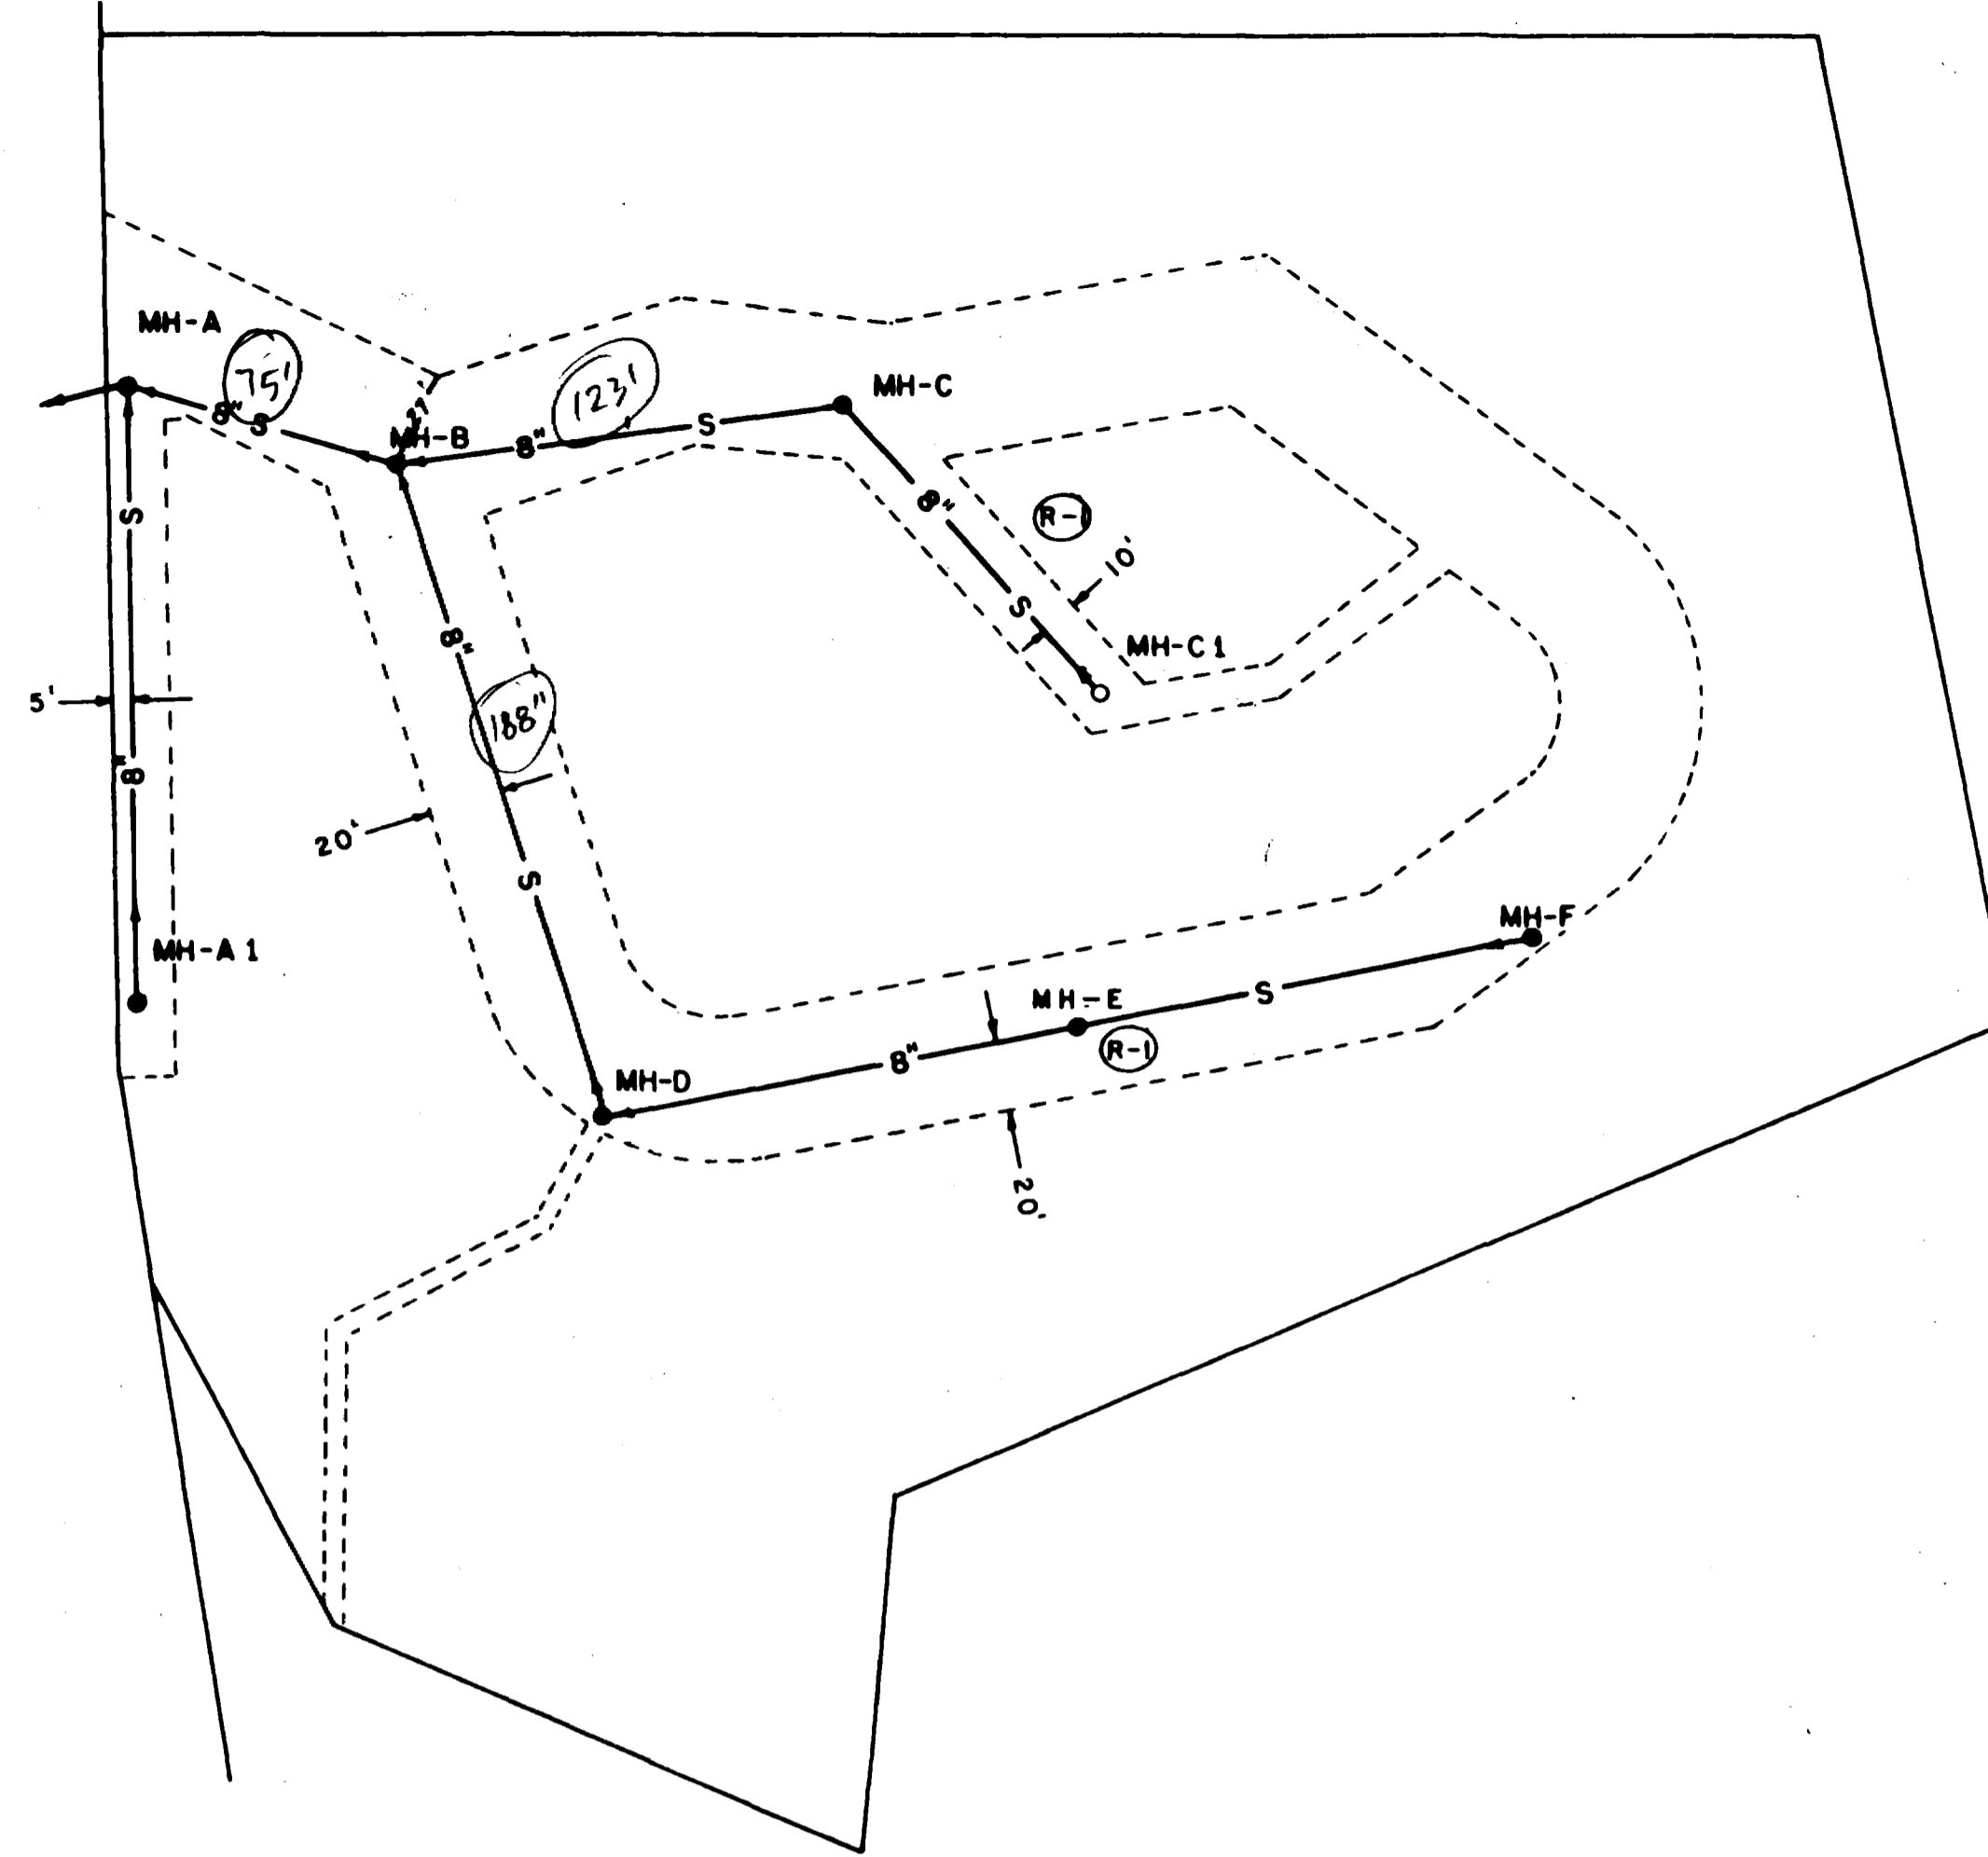

PROFILE
SCALE: HOIZ. 1" = 50'
VERT. 1" = 5'

WESTERN ENGINEERS, INC.
SEWER PLAN AND PROFILE
LA ROCHE ENTERPRISE
MESA COUNTY, COLORADO
ENGINEERED: T.K.H. DRAWN: D.L.M. CHECKED: T.K.H.
GRAND JUNCTION COLO. DWG. 326-878-B 4/1/81

REVISED 4/12/81