

NOTE
All Manholes are City of Grand Junction Standard

City of GRAND JUNCTION
APPROVED _____
City Engineer

REVISIONS		
BY _____	DATE _____	DESCR _____
BY _____	DATE _____	DESCR _____
BY _____	DATE _____	DESCR _____

DATE June 1970 DRAWN TL PROJECT NO _____
 SCALE As Shown CHECKED JP APPROVED JP 70.11.115




NELSON - HALEY - PATTERSON AND QUIRK
ENGINEERING CONSULTANTS
GREELEY - GRAND JUNCTION COLORADO

SANITARY SEWER
PLAN AND PROFILE

PATTERSON GARDENS
SUBDIVISION

1 SHEET
1 SHEETS

02094201.tif

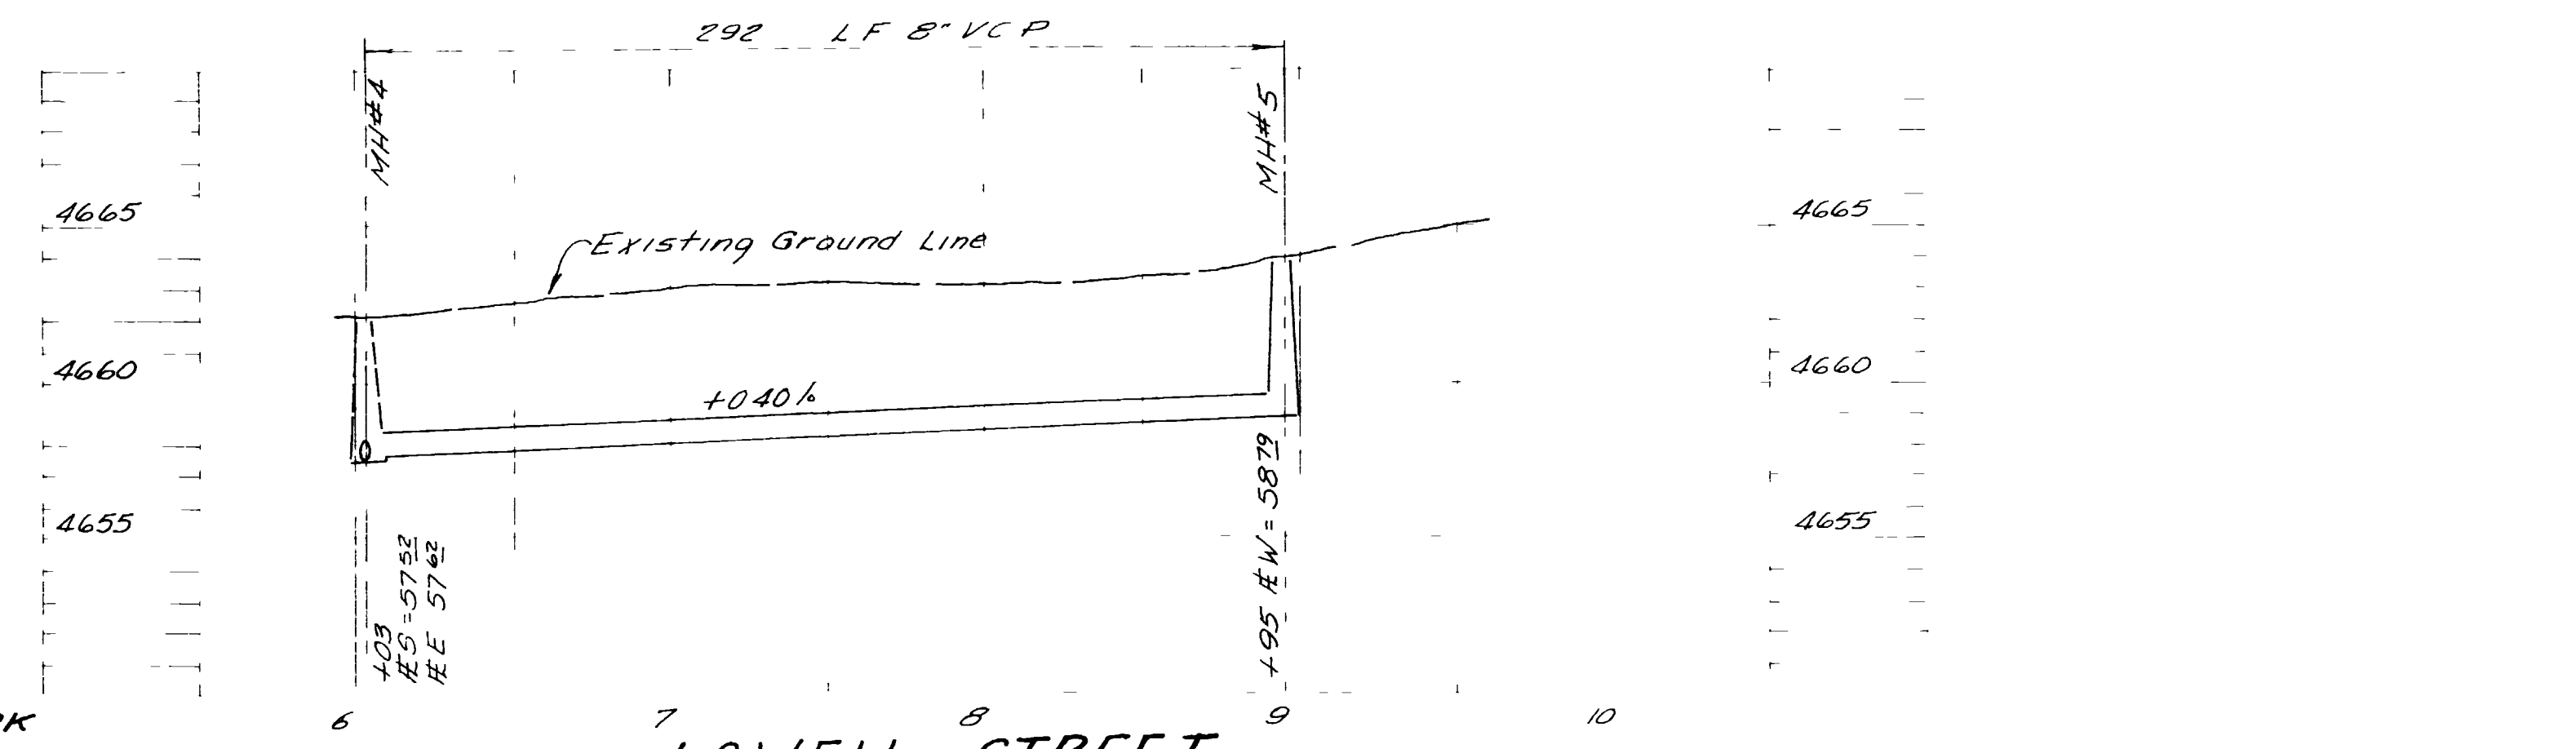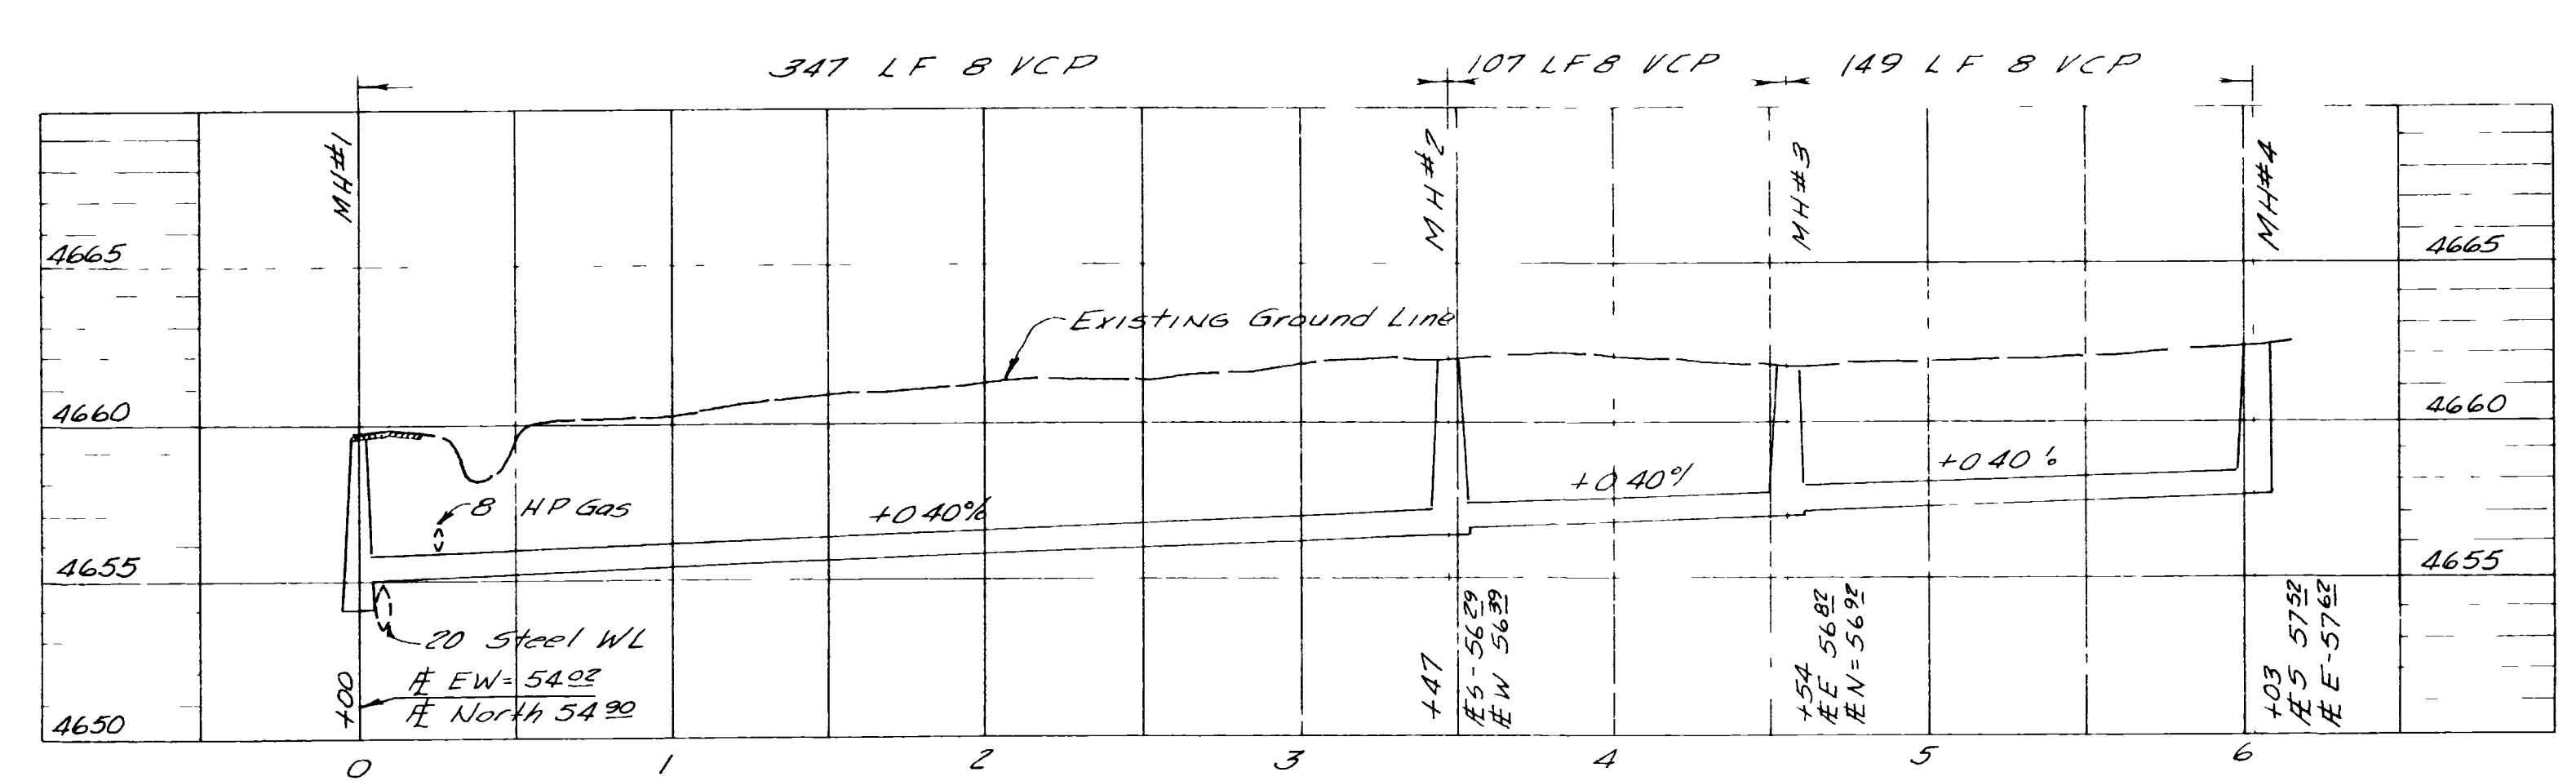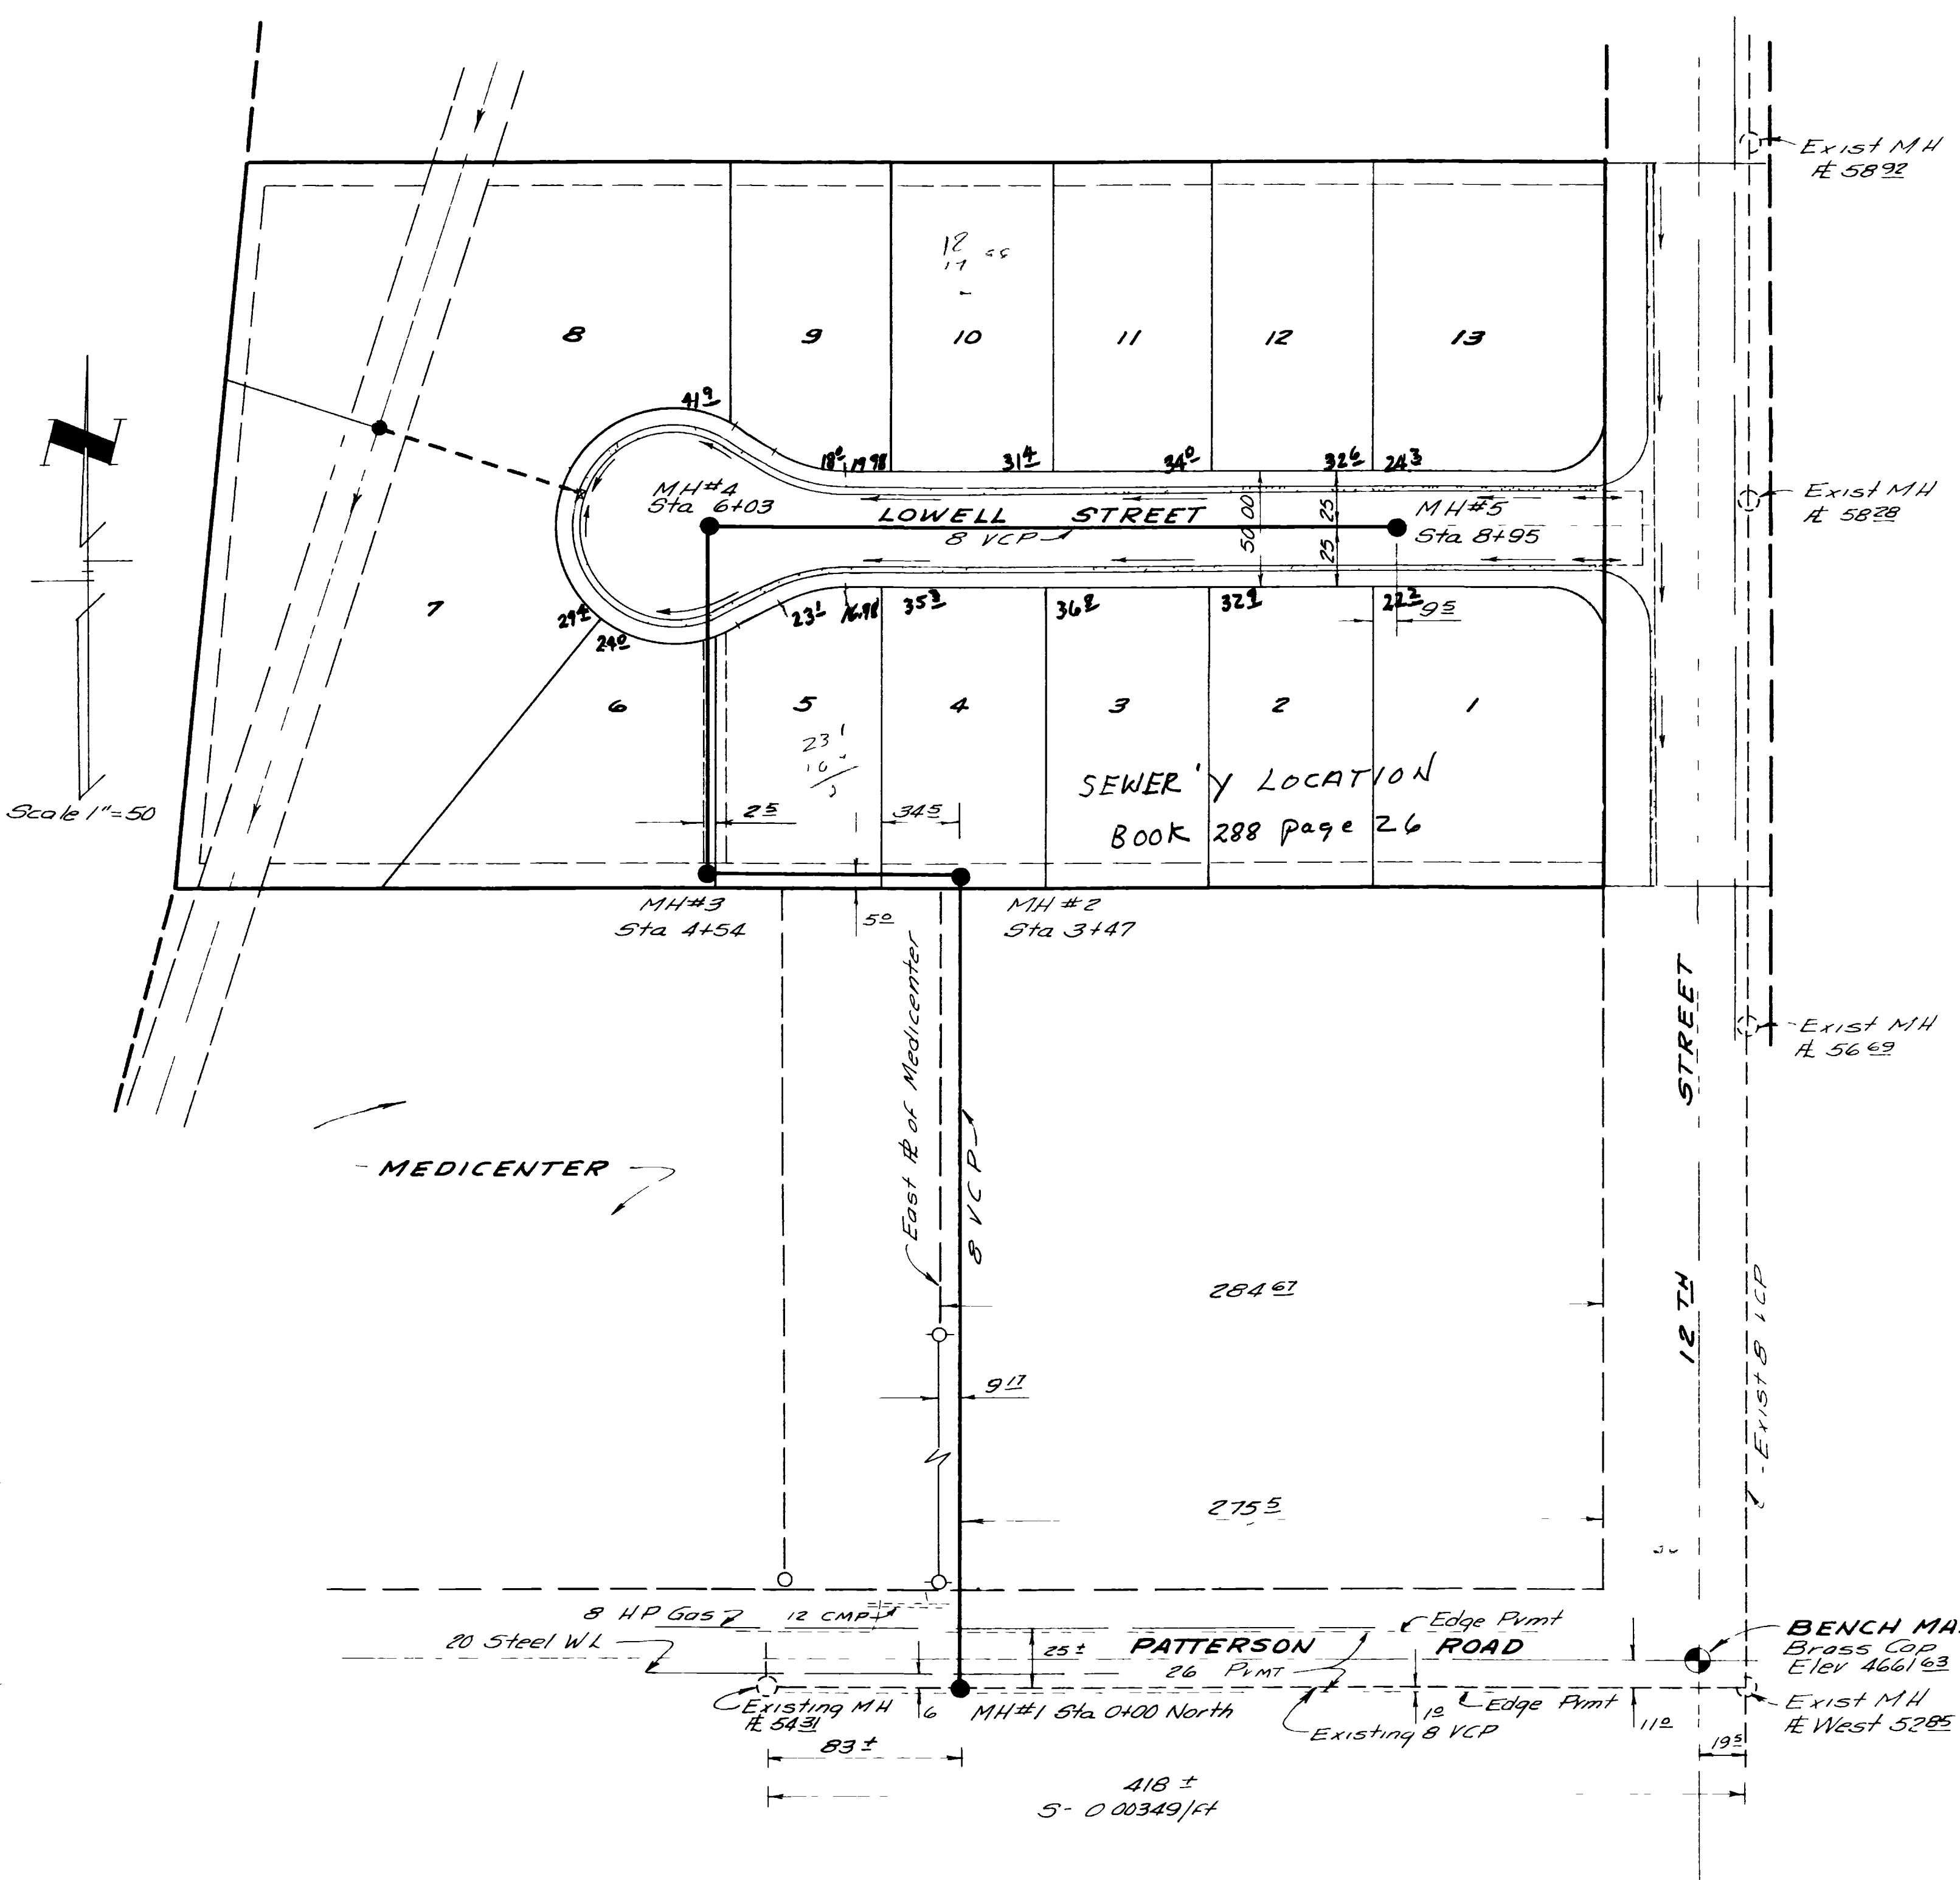


NOTE
All Manholes are City of Grand Junction Standard

AS BUILT

City of GRAND JUNCTION

APPROVED _____
City Engineer

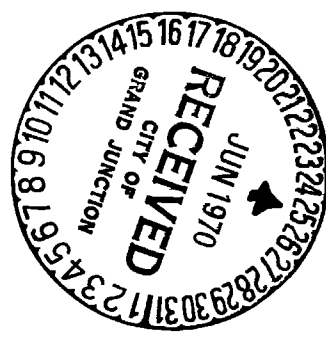

REVISIONS DATE DESCR DATE DESCR DATE DESCR		DATE June 1970 SCALE As Shown	DRAWN T.L. CHECKED J.P. APPROVED J.P.	PROJECT NO 70 11 115	NELSON - HALEY - PATTERSON AND QUIRK ENGINEERING CONSULTANTS GREELEY - GRAND JUNCTION COLORADO	SANITARY SEWER PLAN AND PROFILE	PATTERSON GARDENS SUBDIVISION	02094202.tif 1 SHEETS
---	--	----------------------------------	---	-------------------------	--	------------------------------------	----------------------------------	--------------------------