


**SANITARY SEWER LINE A**  
 HORIZONTAL SCALE: 1"=50'  
 VERTICAL SCALE: 1"=5'

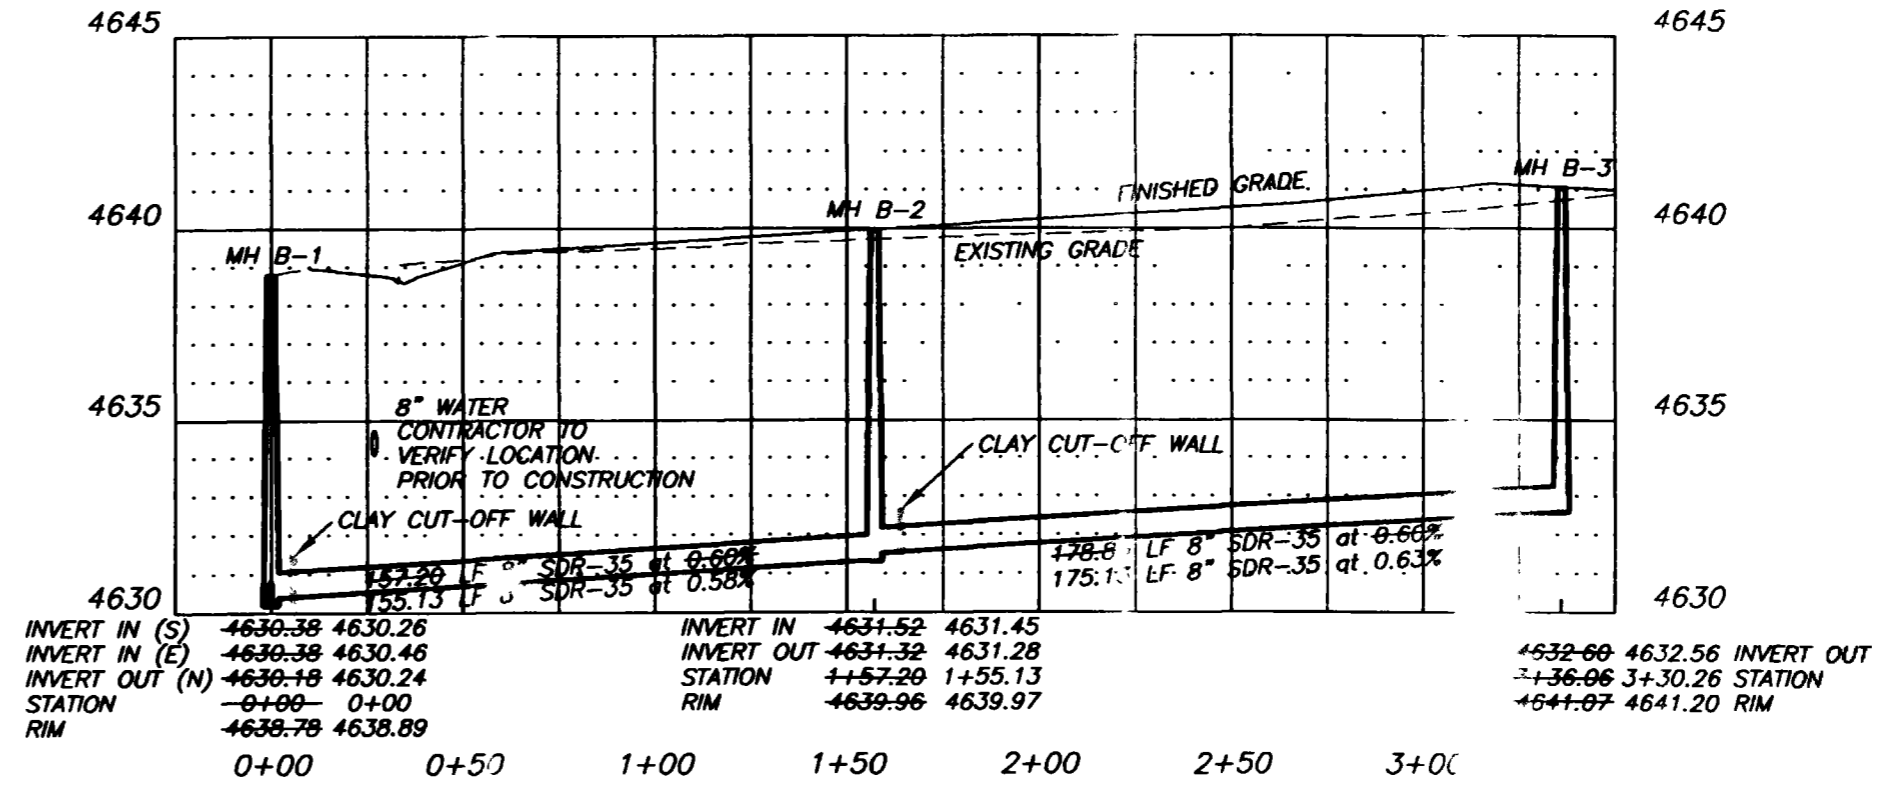

**SANITARY SEWER LINE B**  
 HORIZONTAL SCALE: 1"=50'  
 VERTICAL SCALE: 1"=5'

# RECORD DRAWING

CERTIFICATION OF THESE RECORD DRAWINGS BY A REGISTERED PROFESSIONAL ENGINEER DOES NOT CONSTITUTE CERTIFICATION THAT THE IMPROVEMENTS SHOWN ON THESE DRAWINGS WERE BUILT IN ACCORDANCE WITH THE APPROVED PLANS OR IN ACCORDANCE WITH THE STANDARDS AND REQUIREMENTS OF THE ACCEPTING AGENCY OR ENTITY. THE INTENT OF THESE RECORD DRAWINGS IS TO PROVIDE REPRESENTATION OF THE PHYSICAL LOCATION OF THE IMPROVEMENTS AND THE TYPES OF MATERIALS INSTALLED.

SEWER COLLECTION SYSTEM IMPROVEMENTS SHOWN ON THIS SHEET WERE INSTALLED FEBRUARY-MARCH 2001 BY TRAVIS JORDAN EXCAVATING, INC. OF FRUITA, COLORADO

CITY OF GRAND JUNCTION	
APPROVED FOR CONSTRUCTION FOR ONE YEAR FROM THIS DATE.	
BY: _____	DATE: _____
ACCEPTED AS CONSTRUCTED	
BY: _____	DATE: _____

BY: \_\_\_\_\_ REVISION: \_\_\_\_\_  
 DATE: 05-02-01 NO. 1 RECORD DRAWING  
 PROJECT NO. 200011 FILE NAME: 011-SP445-RECORD  
 DRAWN: CJM  
 CHECKED: BCH  
 DATE: 05-02-01  
**SANITARY SEWER PLAN AND PROFILES RECORD DRAWING**  
**MONUMENT VILLAGE SUBDIVISION FILING 6**  
**LANDesign**  
 ENGINEERS • SURVEYORS • PLANNERS  
 244 NORTH 7th STREET  
 GRAND JUNCTION, COLORADO 81501 (970) 745-4099  
 COLORADO REGISTERED PROFESSIONAL ENGINEER  
 BRIAN C. HARRIS  
 12/27/01  
 SHEET 3 OF 6