


RECORD DRAWING

NOTES

1. CERTIFICATION OF THESE RECORD DRAWINGS BY THE REGISTERED PROFESSIONAL ENGINEER SHOWN DOES NOT CONSTITUTE CERTIFICATION THAT THE IMPROVEMENTS SHOWN ON THESE DRAWINGS WERE BUILT IN ACCORDANCE WITH THE APPROVED PLANS OR IN ACCORDANCE WITH THE STANDARDS AND REQUIREMENTS OF THE ACCEPTING AGENCY OR ENTITY. THE INTENT OF THESE RECORD DRAWINGS IS TO PROVIDE REPRESENTATION OF THE PHYSICAL LOCATION OF THE IMPROVEMENTS AND THE TYPES OF MATERIALS INSTALLED.
2. CERTIFICATION OF THESE RECORD DRAWINGS BY THE REGISTERED PROFESSIONAL ENGINEER SHOWN DOES NOT INCLUDE CERTIFICATION OF THE AS-BUILT ELEVATIONS SHOWN. THE AS-BUILT ELEVATIONS OF IMPROVEMENTS SHOWN ON THESE DRAWINGS WERE PROVIDED BY THE SURVEY DEPARTMENT AT LANDesign, LLC.

SEWER COLLECTION SYSTEM IMPROVEMENTS SHOWN ON THIS SHEET WERE INSTALLED SEPTEMBER 2003 BY ERWIN CONSTRUCTION OF VANCOUVER, WASHINGTON.

PROJECT BENCH MARK:
 2-1/2" BRASS CAP
 PLS 6762 MCGM
 SE CORNER, SW1/4 SW1/4
 SECTION 6, T1S, R1E,
 UTE MERIDIAN
 N: 3677.58
 E: 11271.46

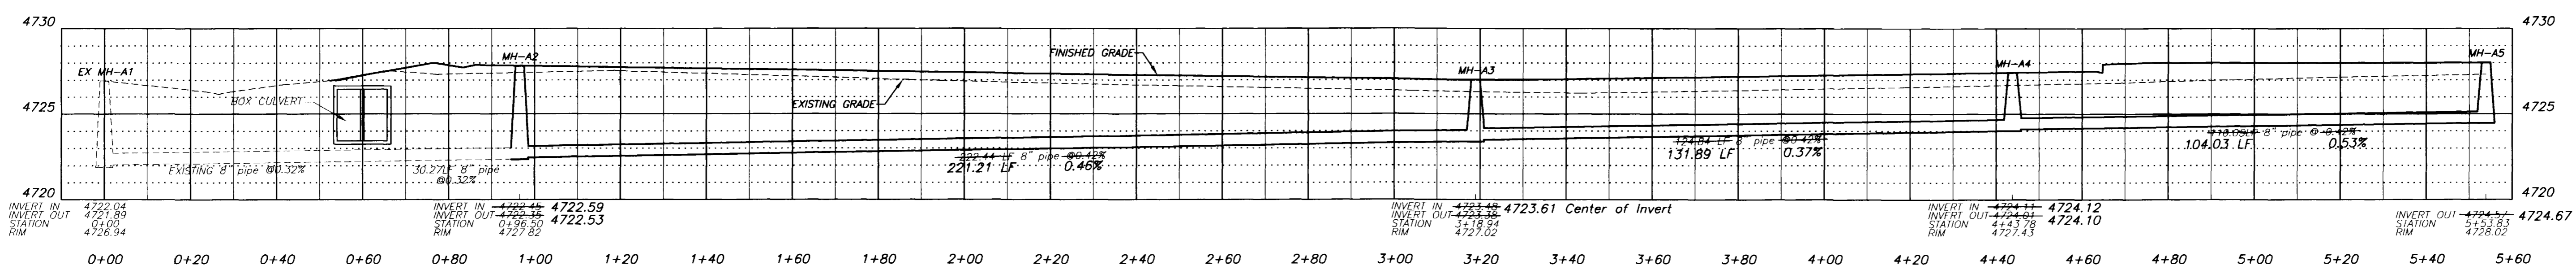

SANITARY SEWER PROFILE

HORIZONTAL SCALE: 1"=20'
 VERTICAL SCALE: 1"=5'

CALL BEFORE YOU DIG 1-800-922-1987

NOTICE: FIELD VERIFY THE LOCATION OF ALL EXISTING UTILITIES A MINIMUM OF 48 HOURS PRIOR TO CONSTRUCTION.

BY:	
REVISION:	
NO:	
DATE:	

SANITARY SEWER
 PLAN AND PROFILE
 RECORD DRAWING
 DRAWN: TLT
 DATE: 5/06/04
 CHK'D: BCH

JEA SENIOR LIVING
 Management + Development
 PROJECT NO.: 202120 FILE NAME: 202120-sewer-AB

LANDesign
 ENGINEERS • SURVEYORS • PLANNERS
 244 NORTH 7th STREET
 GRAND JUNCTION, COLORADO 81501 (970) 245-4099

